



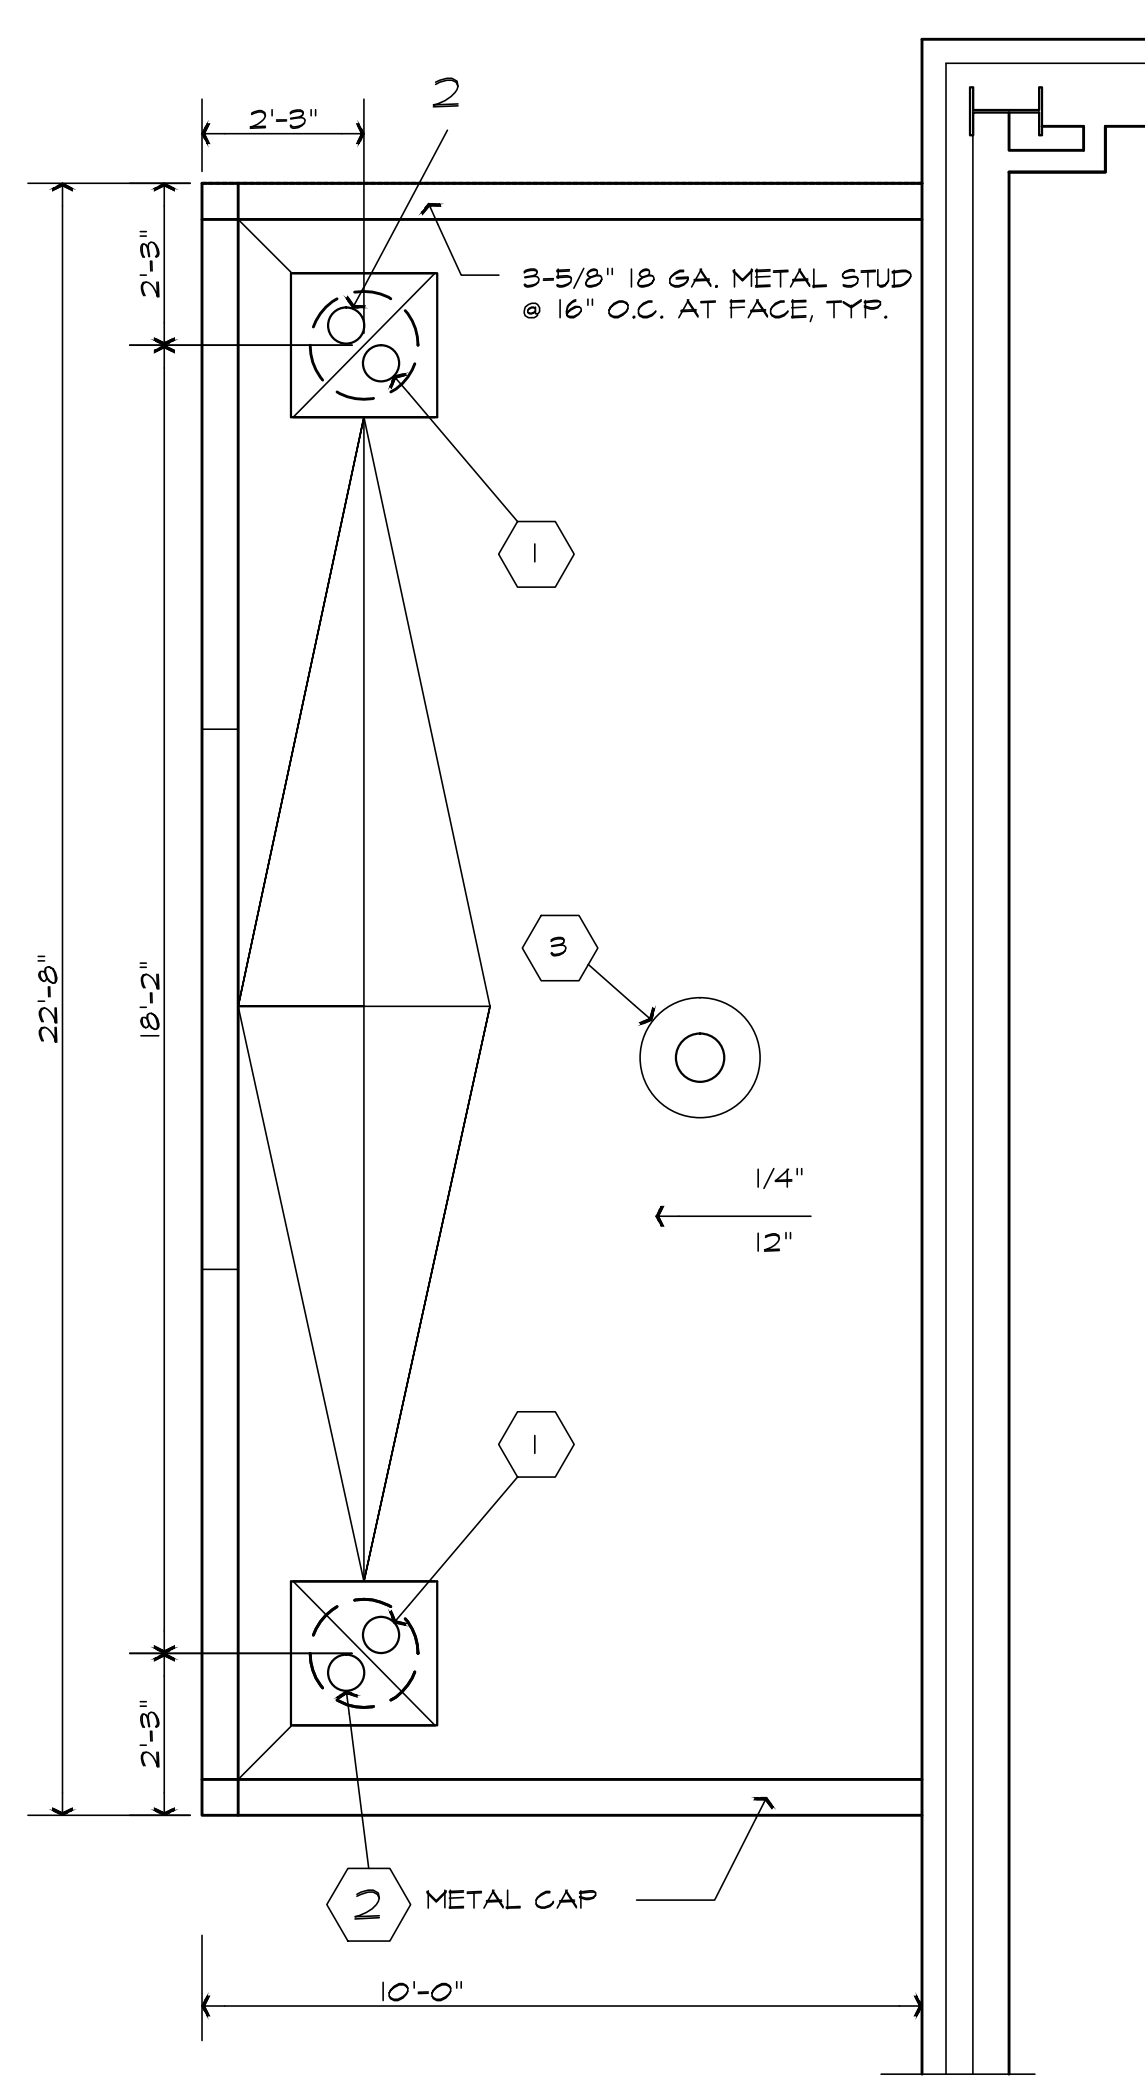

- NOTES:
- 1 INSTALL 3" ROOF DRAIN.
 - 2 INSTALL 3" OVERFLOW ROOF DRAIN.
 - 3 INSTALL 4" VTR PIPE W/DOWNTURN


CANOPY PLAN
SCALE: 3/8" = 1'-0"

F
A-3.3

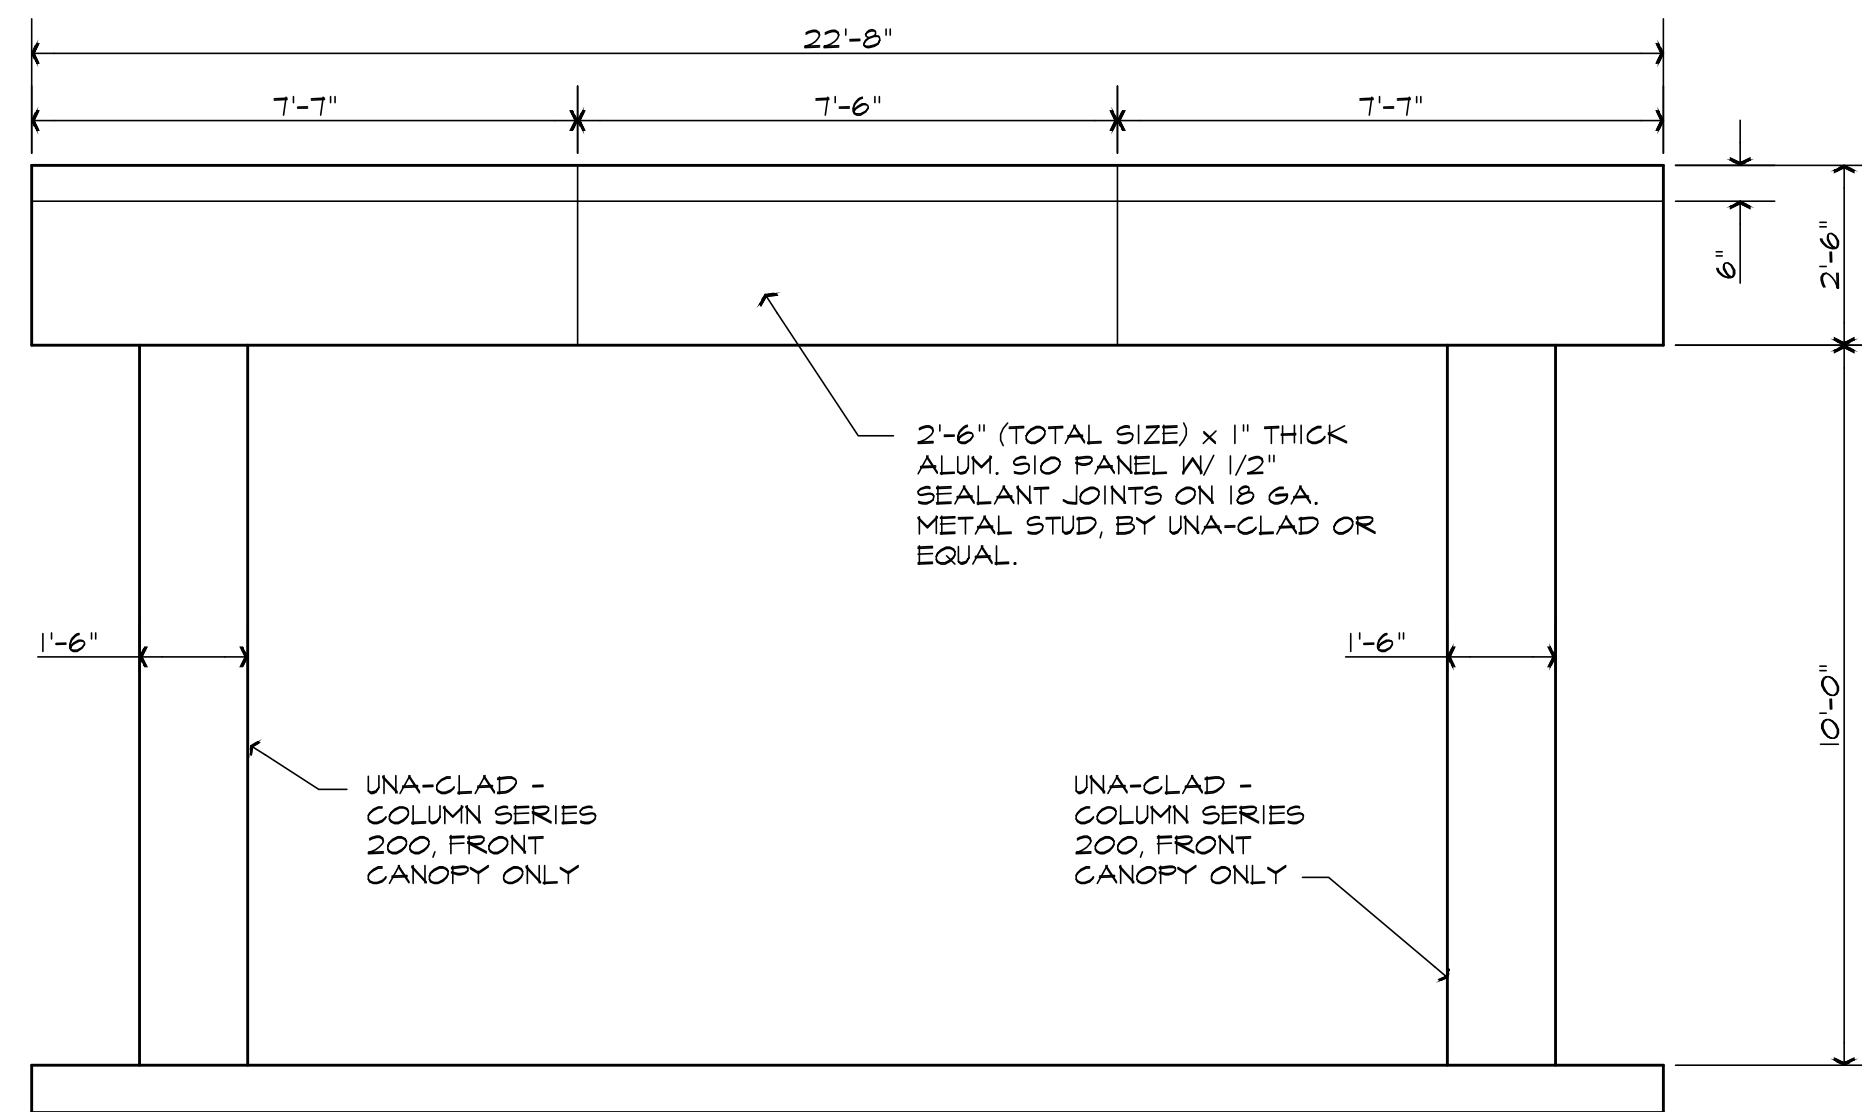


CANOPY ELEVATION
SCALE: 3/8" = 1'-0"

G
A-3.3

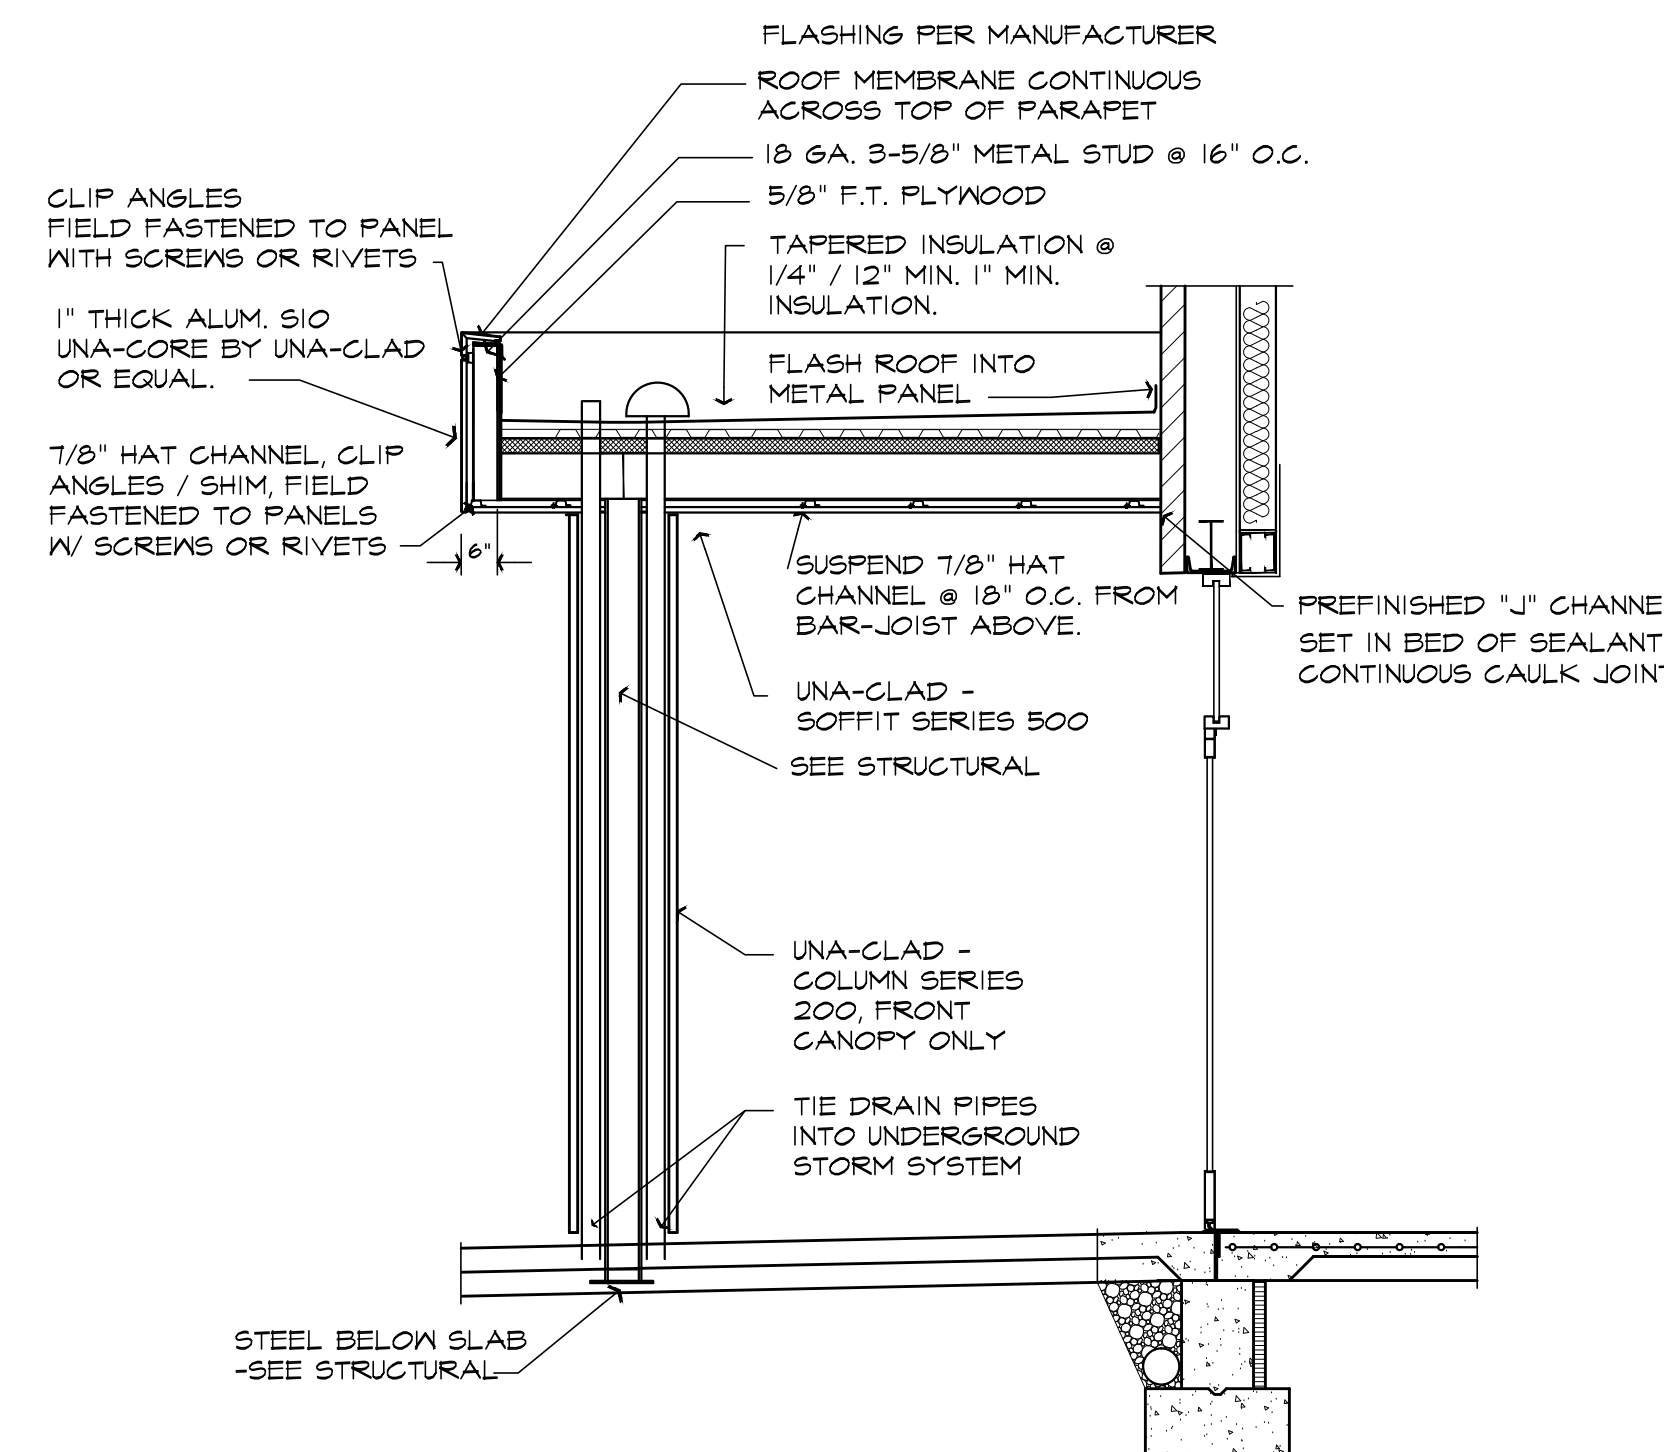


SECTION @ CANOPY
SCALE: 3/8" = 1'-0"

H
A-3.3

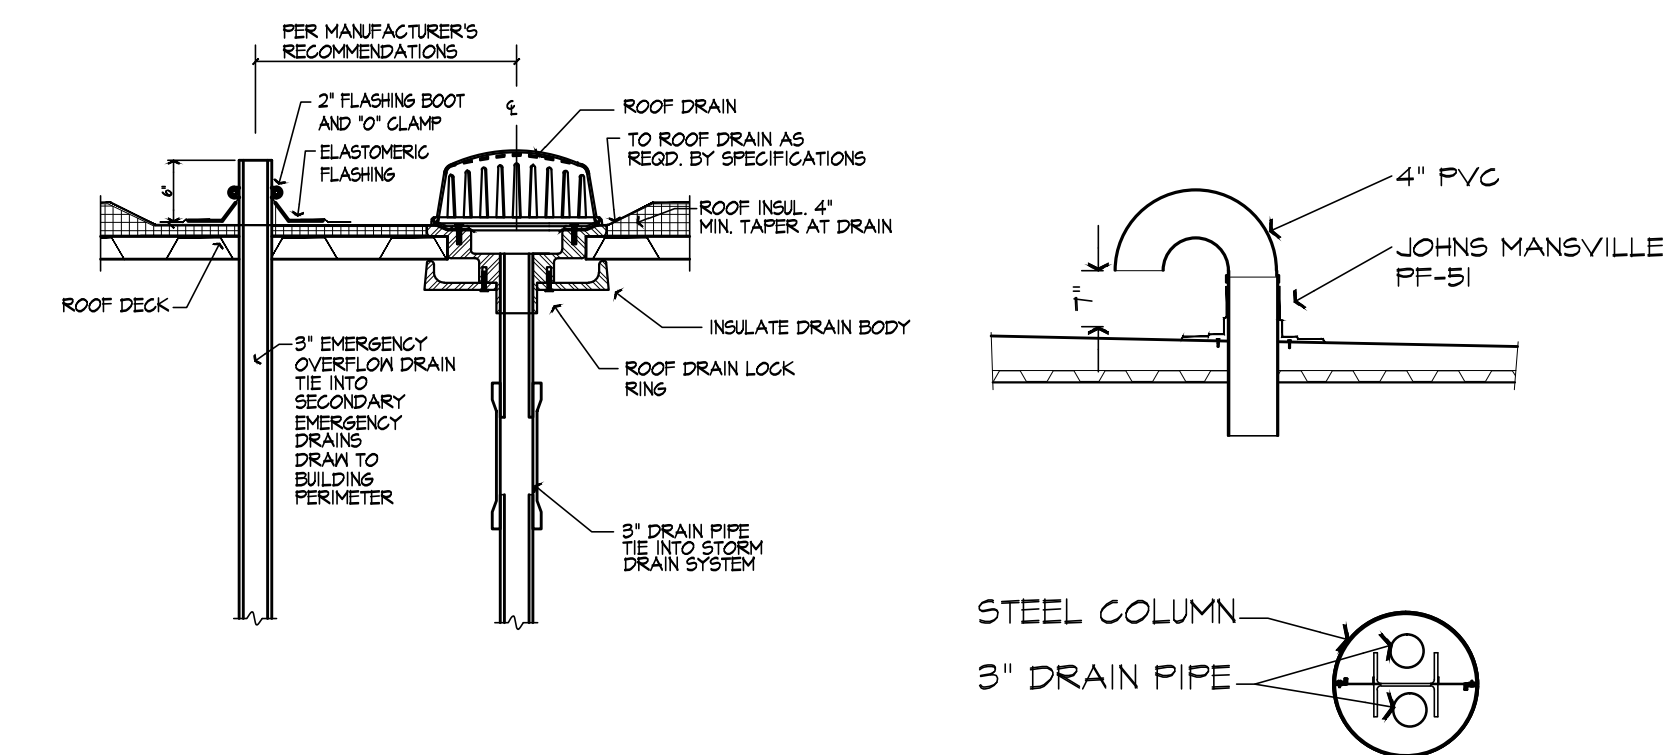


OFFICE CANOPY DETAILS
SCALE: 1/2" = 1'-0"

2
A-5

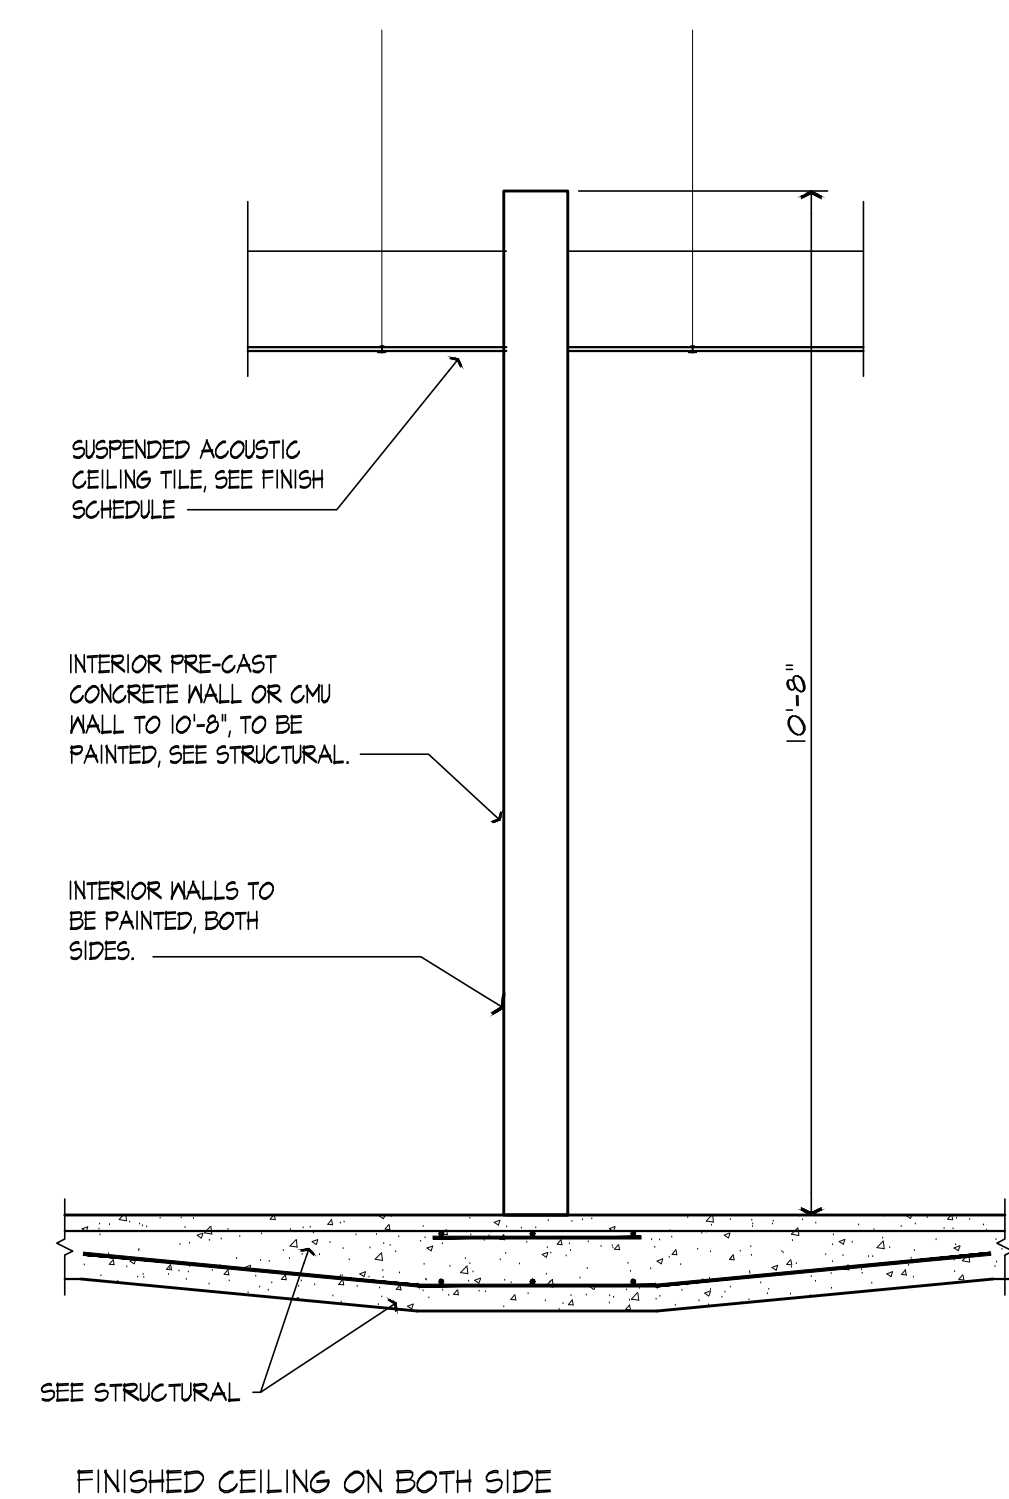


INTERIOR WALL SECTION
SCALE: 1/2" = 1'-0"

A
A-3.3

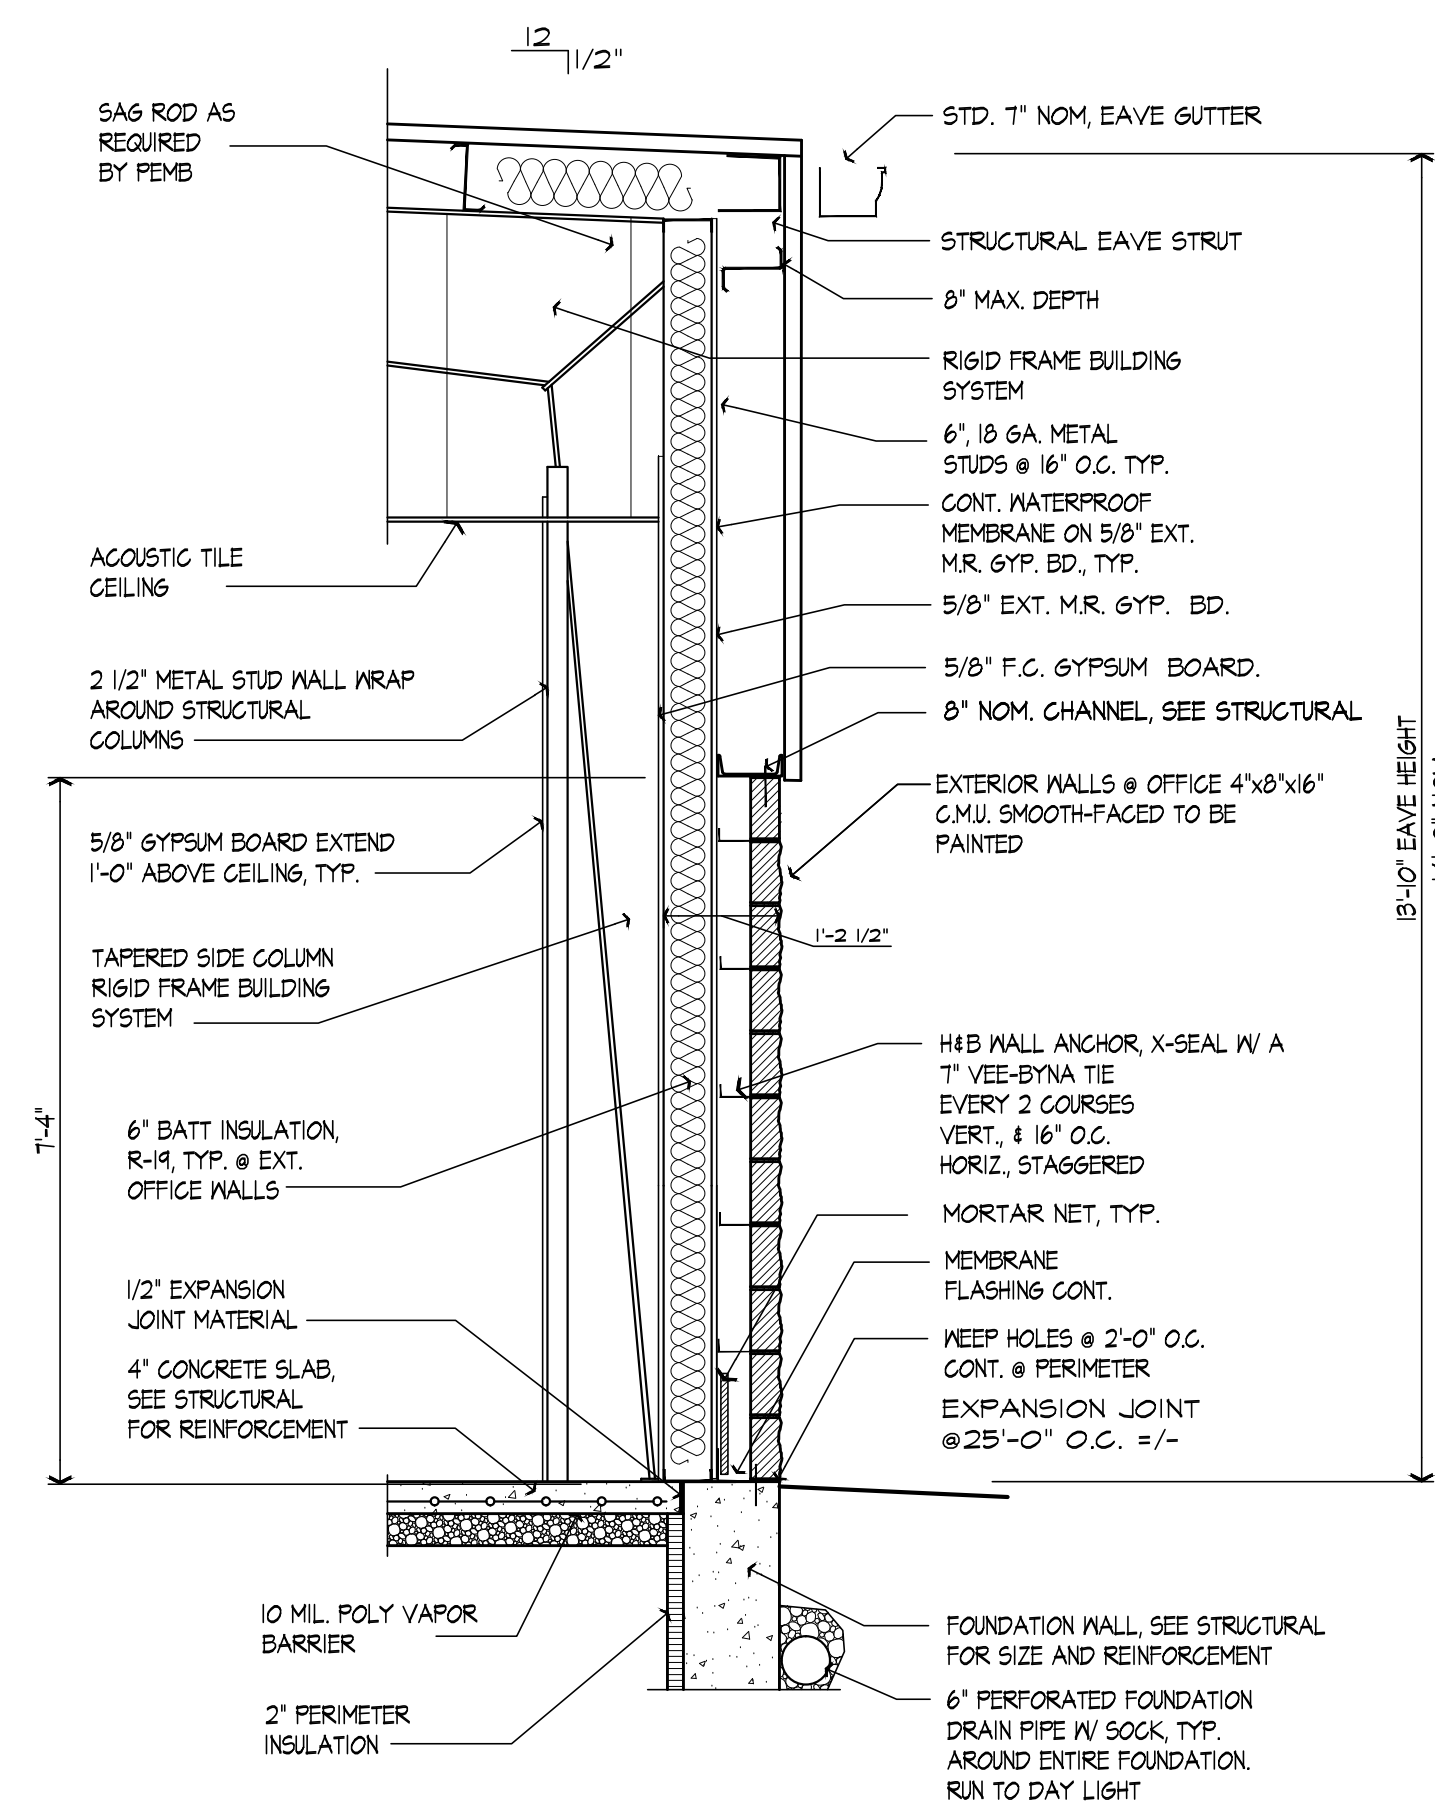


WALL SECTION
SCALE: 1/2" = 1'-0"

B
A-3.3

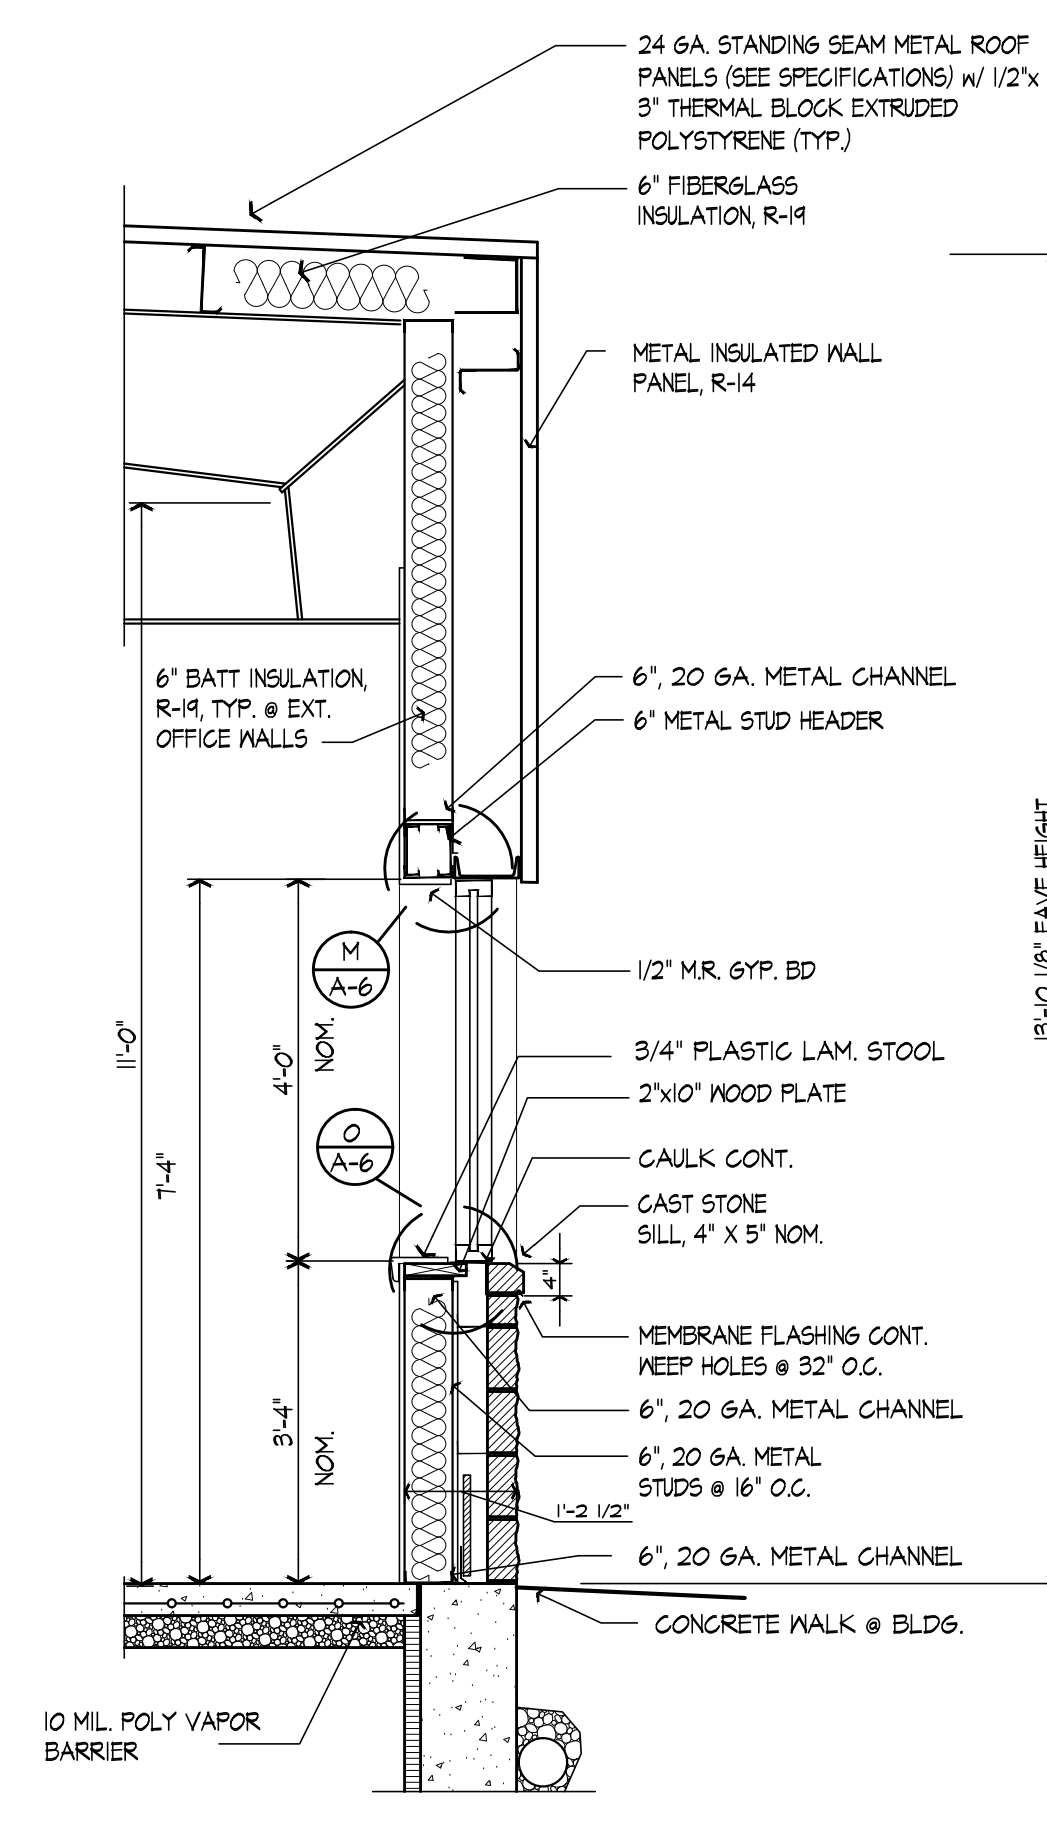


WALL SECT. @ WINDOW
SCALE: 1/2" = 1'-0"

C
A-3.3

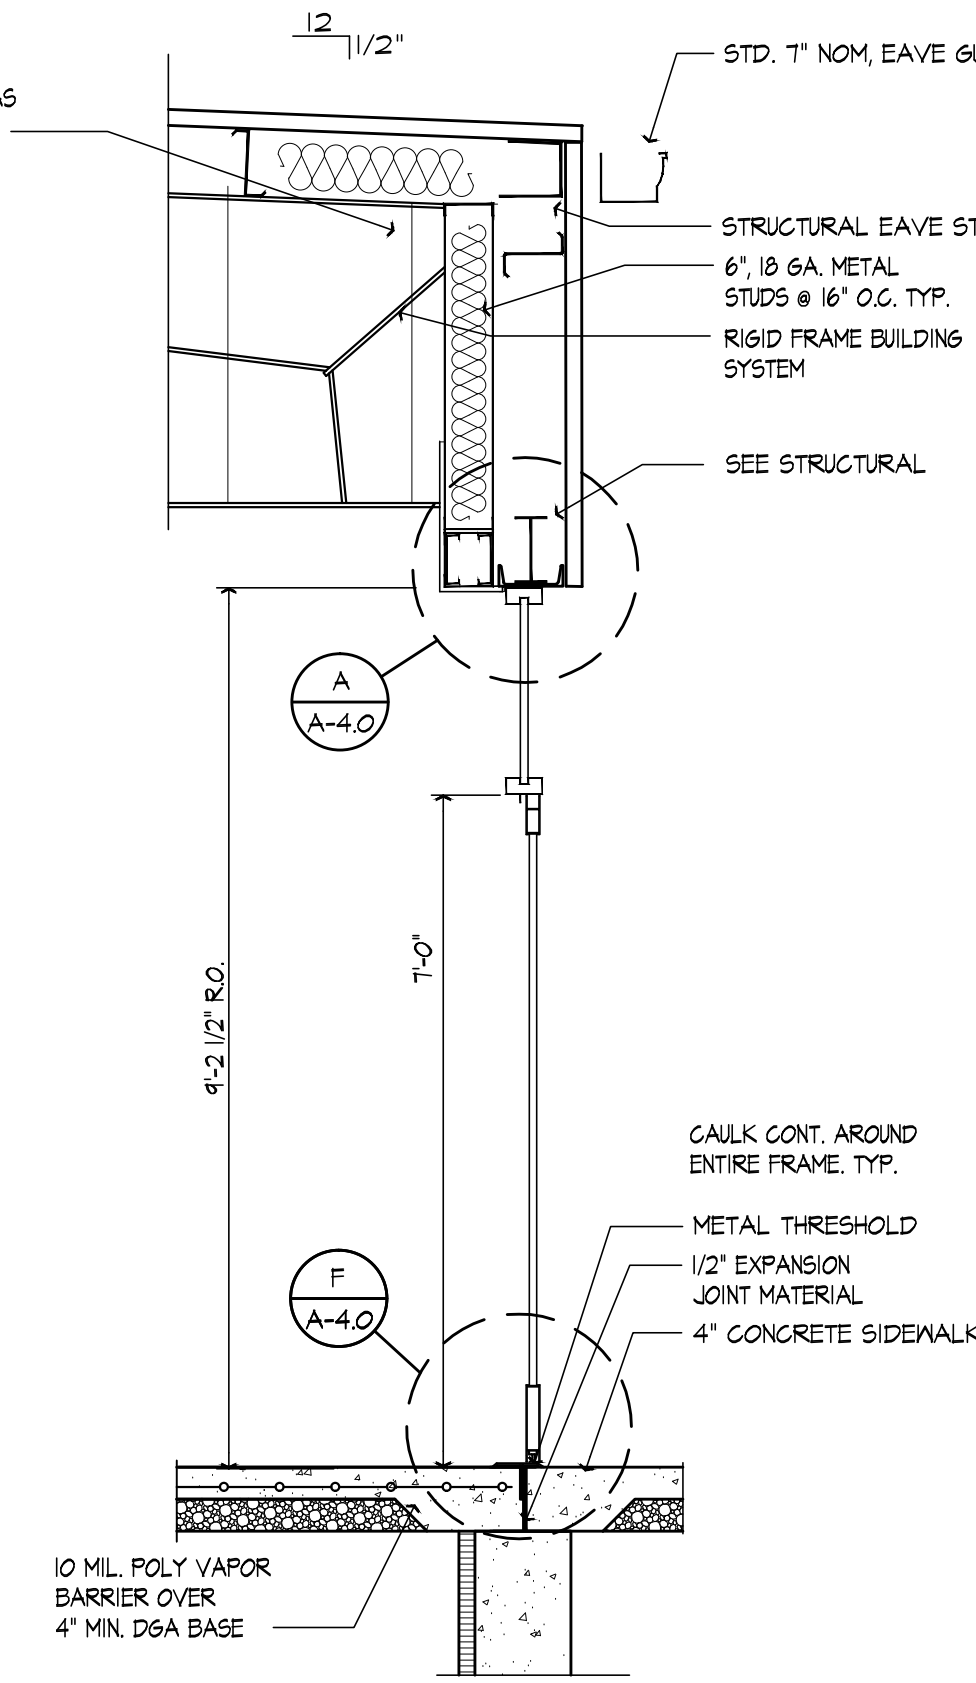


WALL SEC @ ALUM DR.
SCALE: 1/2" = 1'-0"

D
A-3.3

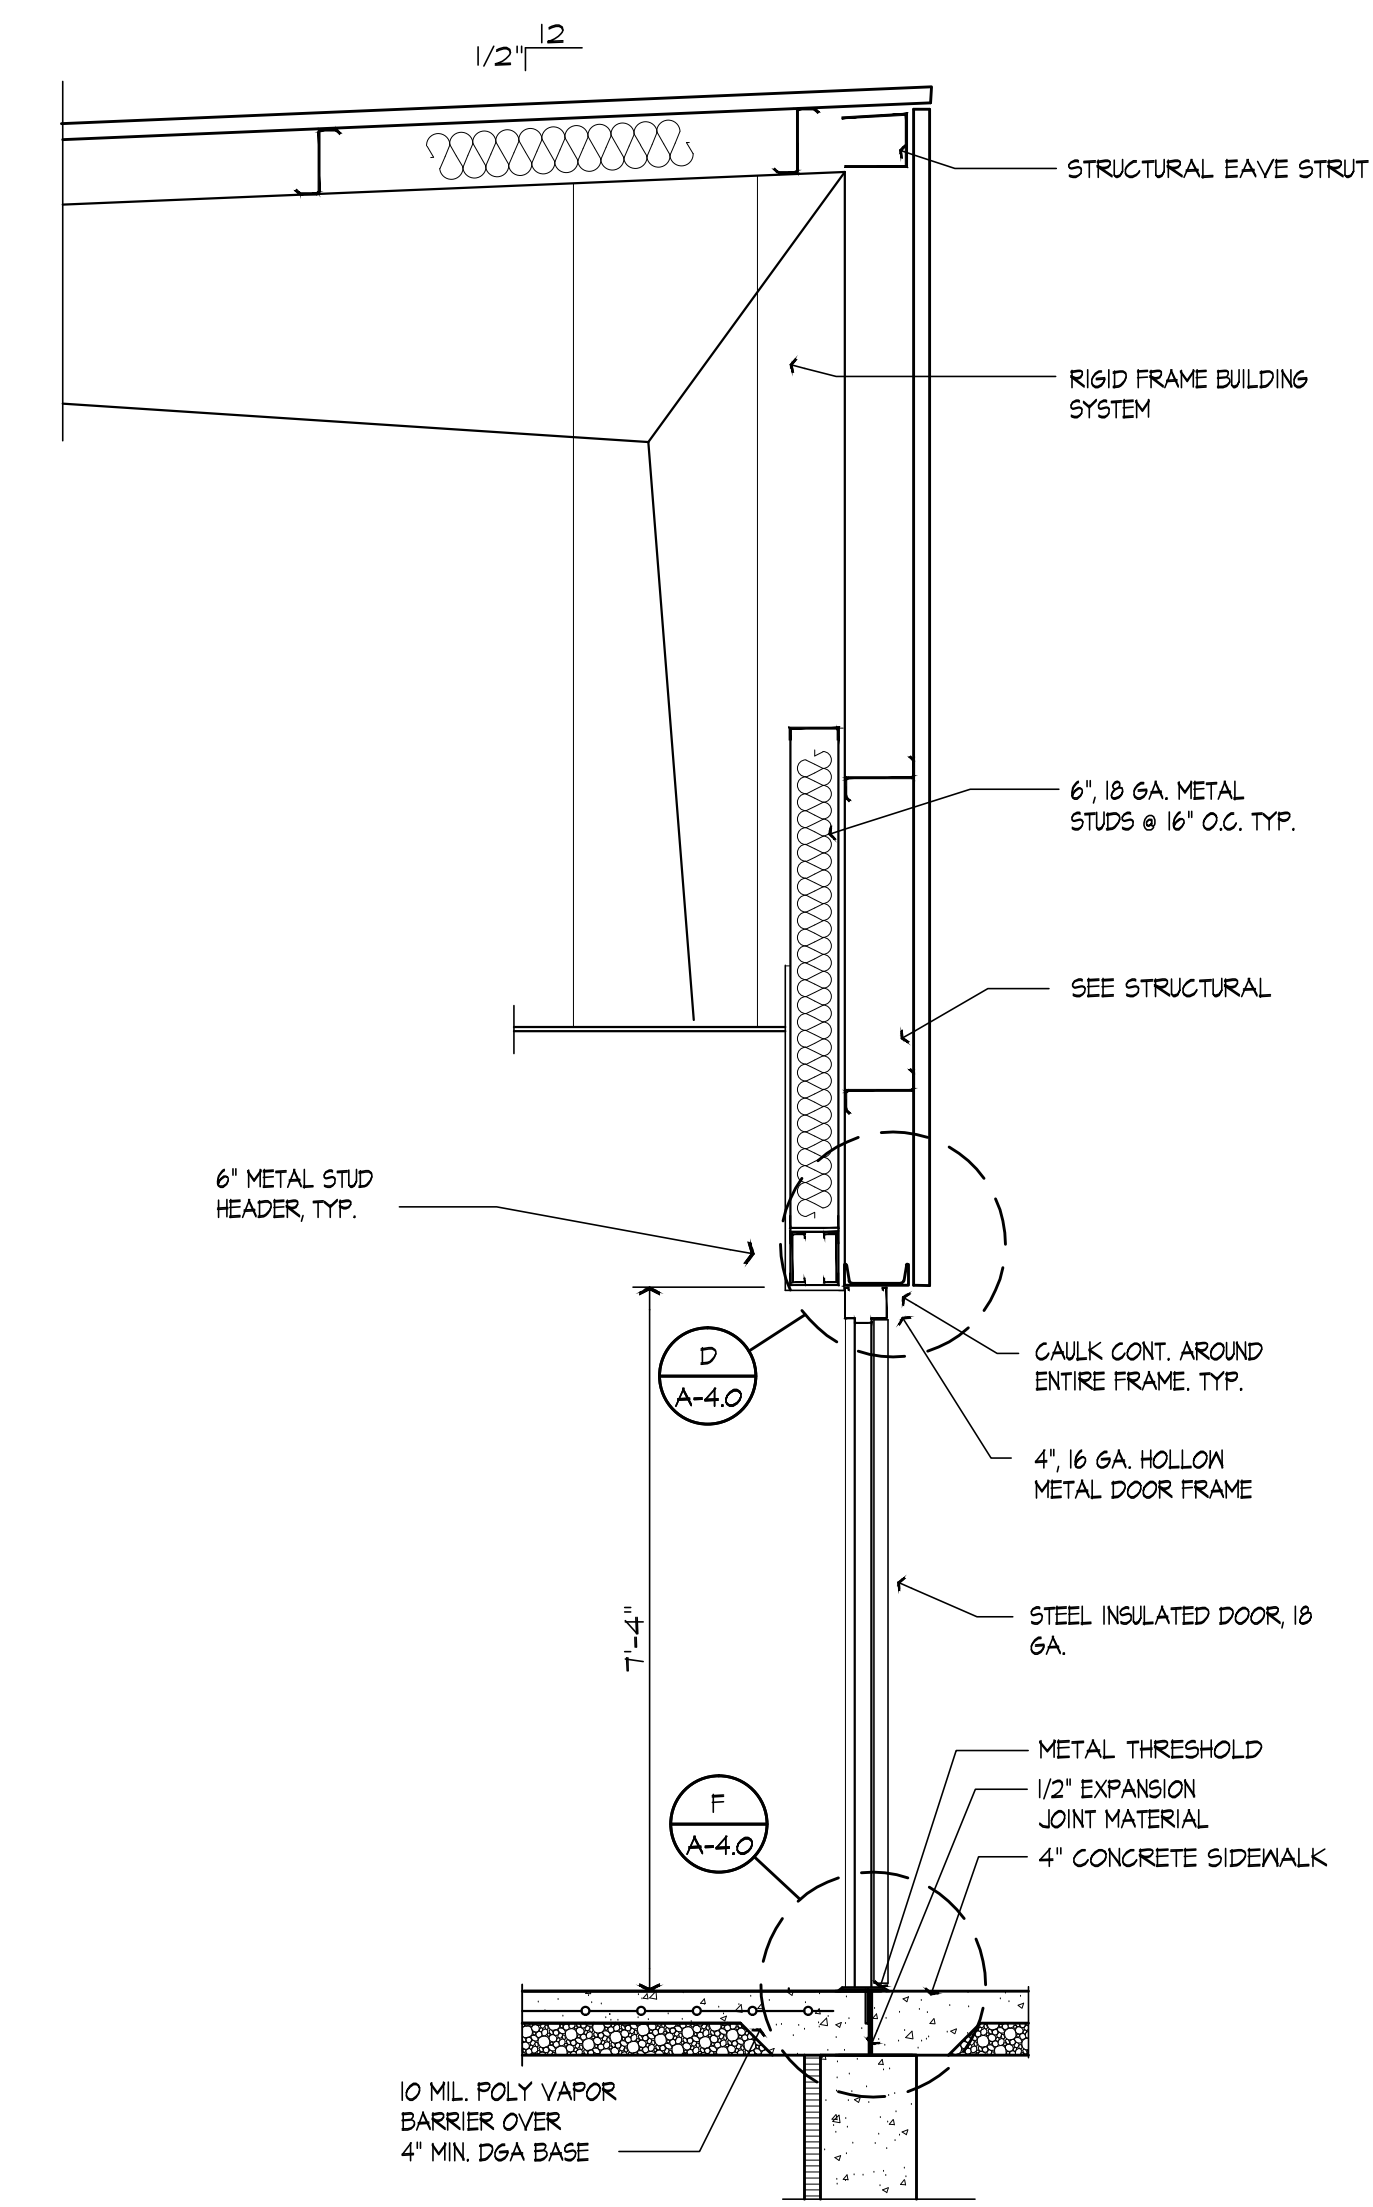

WALL SEC @ HMD DR.
SCALE: 1/2" = 1'-0"

E
A-3.3

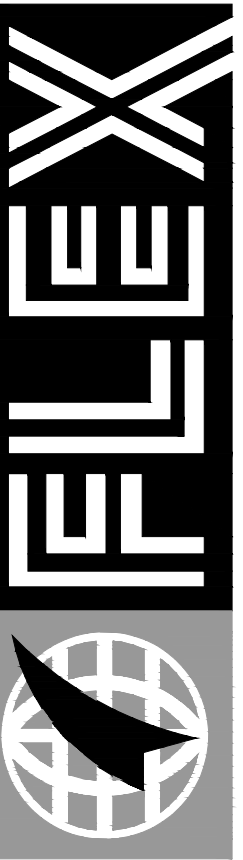

FLEX FILMS (USA) INC.
1221 NORTH BLACK BRANCH ROAD
ELIZABETHTOWN, KENTUCKY 42702
PROJECT L-12 BOPET U.S.A.

DATE	REVISION	BY
12-23-11	REVISION NUMBER THREE, CMU WALLS	
12-23-11	REVISION NUMBER THREE, CMU WALLS	

nse
OF KENTUCKY, INC.
Engineers
Architects
Planners
Phone: (502) 223-5644
624 Wellington Way
Lexington, KY 40505
Fax: (502) 223-2601
www.nseusa.com