
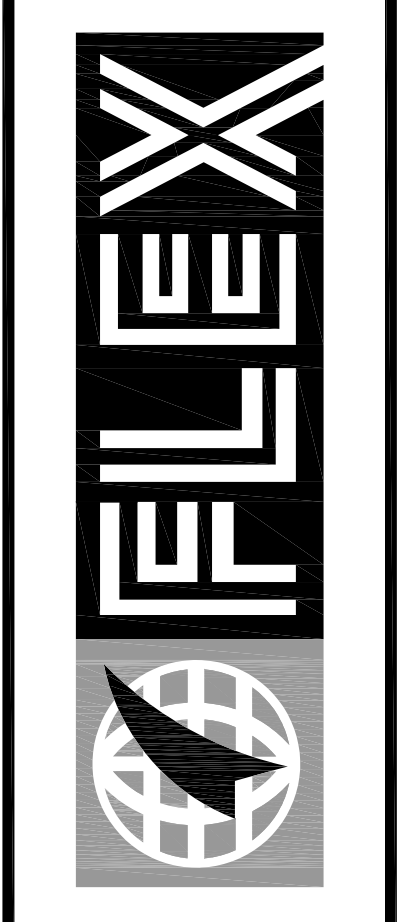
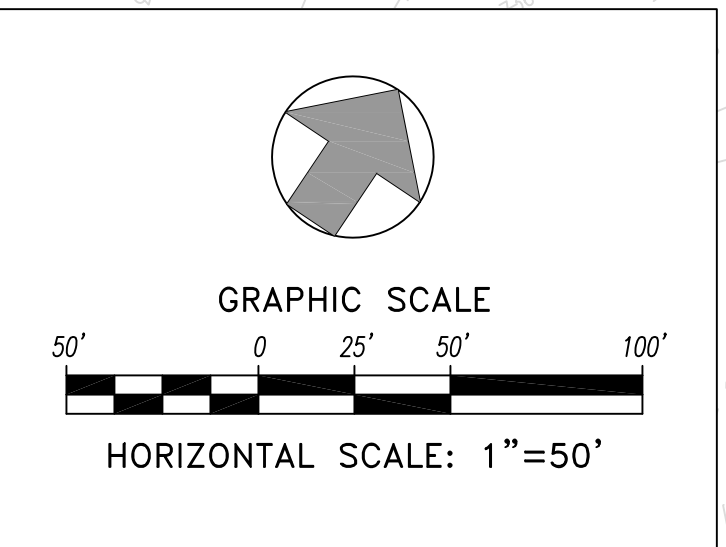


OCT 21 10:20:44-25 FLEX FILM - ELIZABETHTOWN TJ PATTERSON INDUSTRIAL PARK C-109 STORM DRAINAGE PLANNING

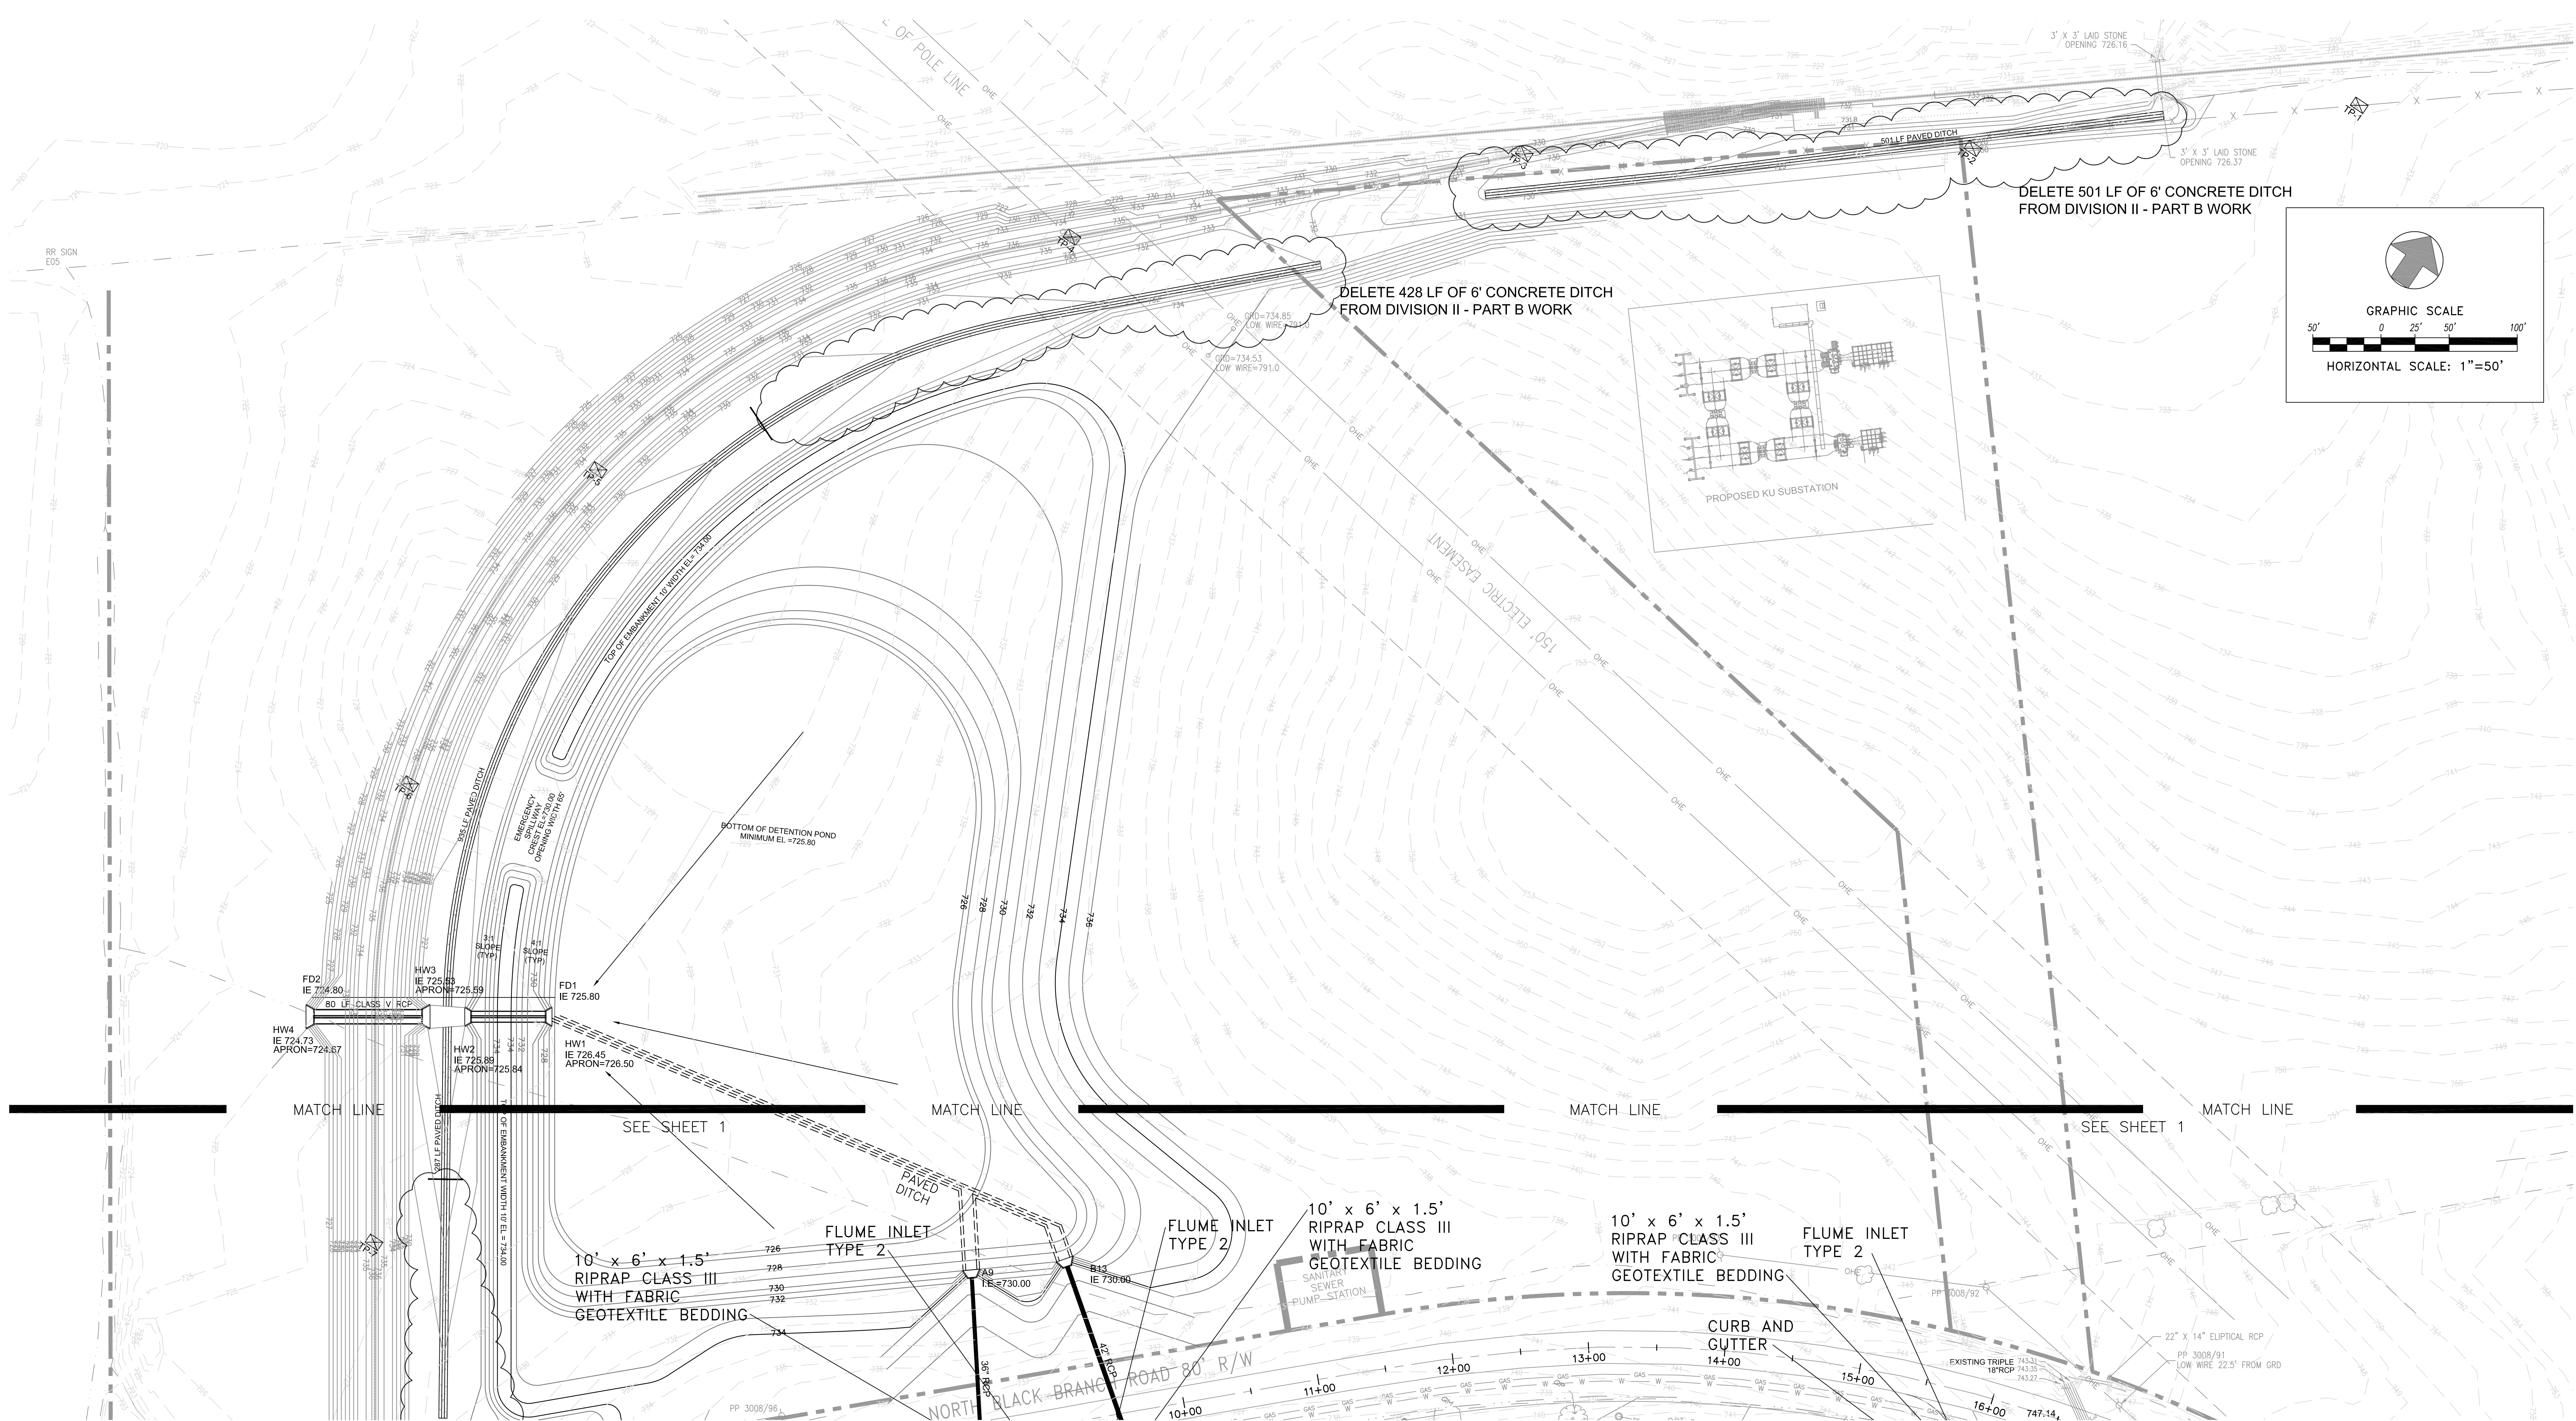

FLEX FILMS (U.S.A.) INC.
 1221 NORTH BLACK BRANCH ROAD
 ELIZABETHTOWN, KENTUCKY 42702
 PROJECT L-12 BOPET U.S.A.

DATE	REVISION	BY
10-2011	POST BID REVISIONS	A.G.

DESIGN DOCUMENTS prepared by and at responsibility of the designer. The user assumes all liability for problems which arise from failure to follow these plans, specifications and the design team's survey.
 One hundred percent of the design is subject to change without notice. The user assumes all liability for problems which arise from failure to follow these plans, specifications and the design team's survey.
 One hundred percent of the design is subject to change without notice. The user assumes all liability for problems which arise from failure to follow these plans, specifications and the design team's survey.

PROJECT NO.	DESIGNED BY	DRAWN BY	CHECKED BY	REVIEWED BY
2064-25	G.A.R.	J.P.M.	G.A.R.	G.A.R.

DATE	SCALE
JUNE 2011	AS SHOWN

MS&P
Engineers
Architects
Planners
OF KENTUCKY, INC.
 624 Wallington Way
 Lexington, KY 40503
 Phone: (859) 222-5884
 Fax: (859) 222-9807
 www.msap.com

DRAWING NO.
UFL-L12
C-109.1

SITE STORM DRAINAGE PLAN (NORTH)