


1st FLOOR PLAN - MACHINE LAYOUT A
 SCALE: 1/32"=1'-0"

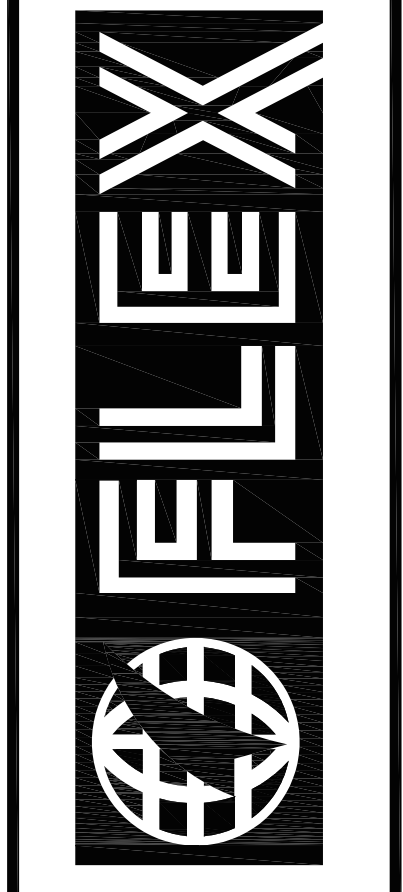

FLEX FILMS (USA) INC.
 1221 NORTH BLACK BRANCH ROAD
 ELIZABETHTOWN, KENTUCKY 42702
 PROJECT L-12 BOPET U.S.A.

DATE	POST	BY	REVISION
10-2011	POST	BY	REVISION

DESIGNED BY: NSE
 DRAWN BY: AJS
 CHECKED BY: GAR
 DATE: JUNE 2011
 SCALE: AS NOTED

DESIGN DOCUMENTS:
 In the event of any discrepancy between the drawings and the physical equipment, the physical equipment shall prevail.
 COPYRIGHT © 2011, Flex Films (USA) Inc. All rights reserved. No part of this document may be reproduced without the written permission of Flex Films (USA) Inc. or its affiliates. This document is the property of Flex Films (USA) Inc. and is to be used only for the purpose intended. Flex Films (USA) Inc. is not responsible for any damage or loss of data resulting from the use of this document.

**Engineers
 Architects
 Planners**

nse
OF KENTUCKY, INC.

524 Washington Way
 Louisville, KY 40203
 www.nseinc.com

Phone: (502) 253-5884
 Fax: (502) 225-2887

DRAWING NO.
**UFL-L12
 ML-001**

MACHINE LAYOUT OVERALL PLAN