


SHEET NOTES:



- PANEL TO BE PROVIDED BY MACHINE PROVIDER. ELECTRICIAN TO INSTALL MACHINE CABLING ON ALL MACHINE PANELS PER MACHINE DRAWING.
- CONTRACTOR TO PROVIDE TRENCH CONDUIT PER KENTUCKY UTILITIES STANDARD, MIN. DEPTH OF 42". KENTUCKY UTILITIES TO PULL CABLE.
- CIRCUIT REQUIRES A NEUTRAL.
- WIRE # 2-20 M.A. G-480V AND G-60HZ WIRES FROM EACH INCOMING SERVICE BREAKER TO PANEL CONTROL PANEL # 11 IN MAIN CONTROL ROOM F-12E.

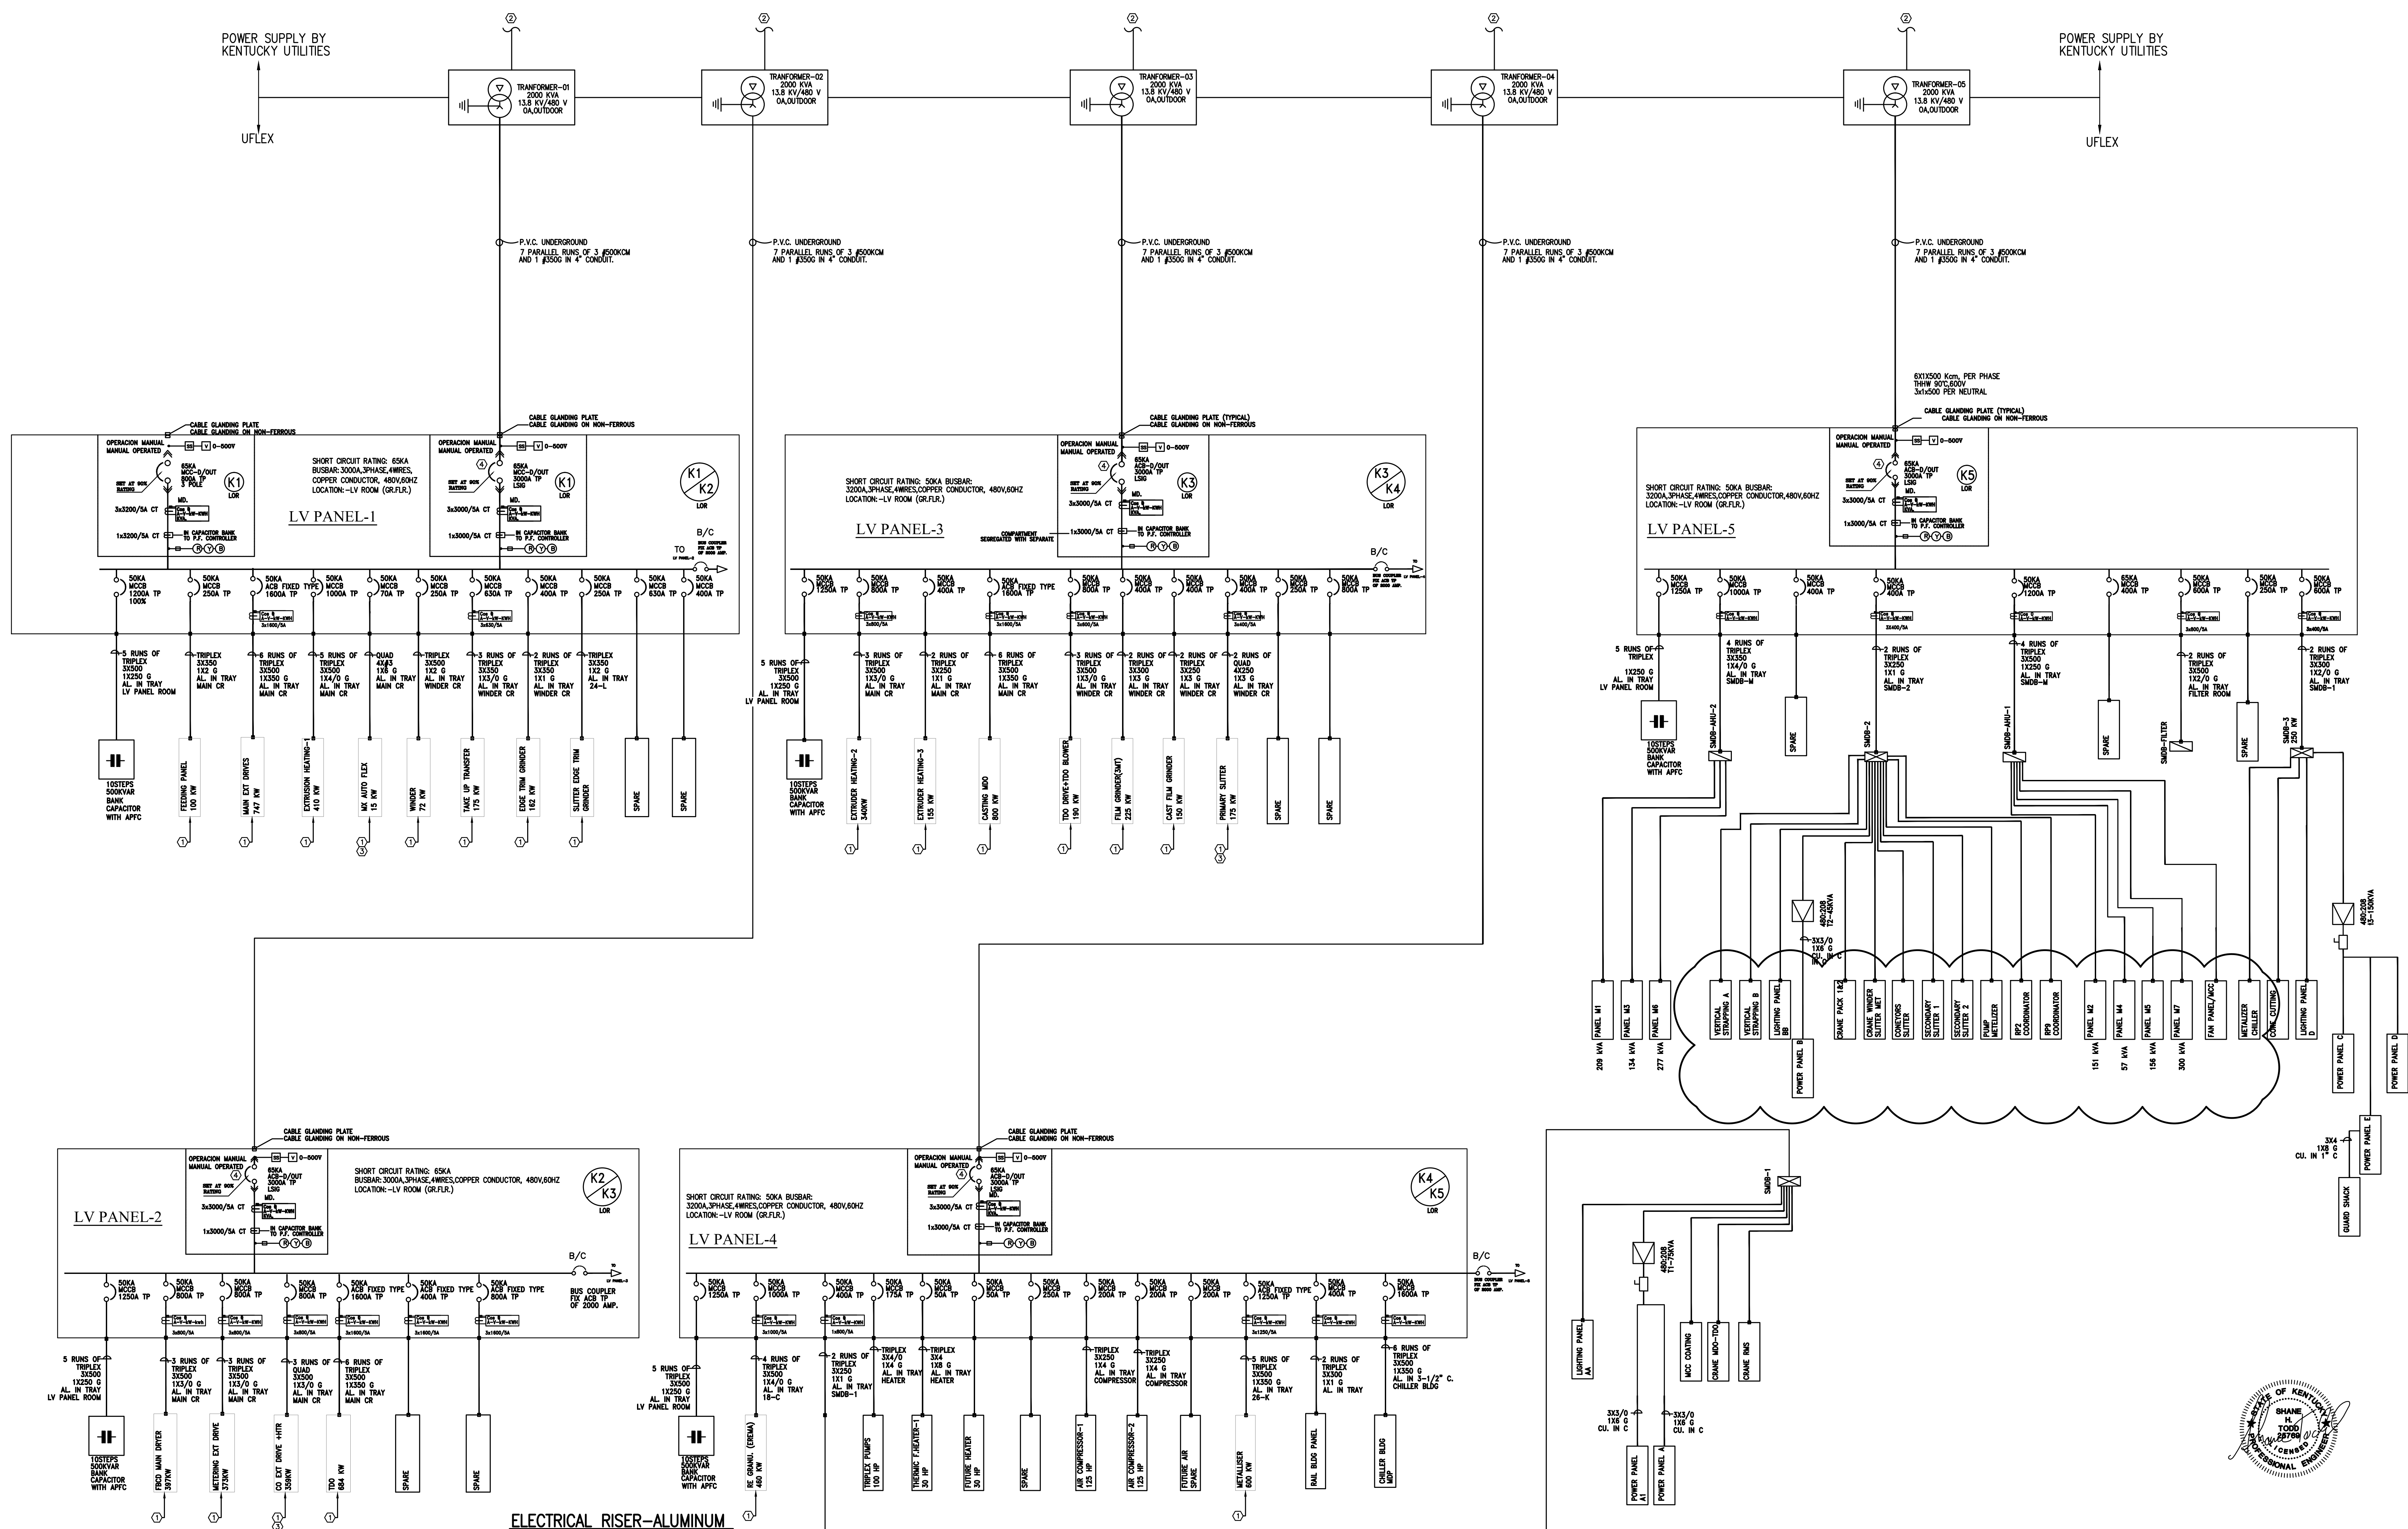

ELECTRICAL RISER-ALUMINUM

ELECTRICAL RISER-ALUMINUM


VALUE ENGINEERING RE-DESIGN DOCUMENT, NOVEMBER 11, 2011

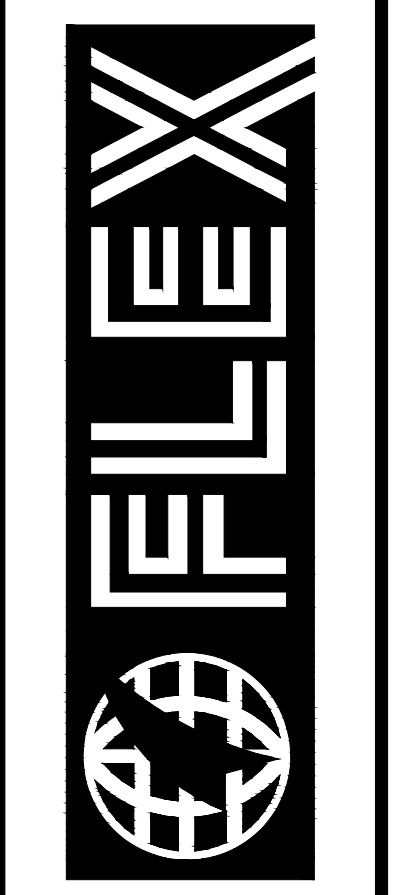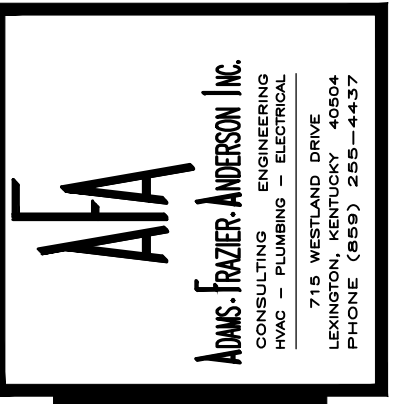

FLEXFILMS, U.S.A., LLC
 1221 NORTH BLACK BRANCH ROAD
 ELIZABETHTOWN, KENTUCKY 42702
 PROJECT L-12 BOPET U.S.A.

DATE	REVISION
NOV. 1, 11	VALUE ENGINEERING RE-DESIGN DOCUMENT
NOV. 23, 11	ADDENDUM

PROJECT NO. 8529-02
 DESIGNED BY LIE
 DRAWN BY SHT
 CHECKED BY TBT
 REVIEWED BY TBW
 DATE JULY 2011
 SCALE AS NOTED

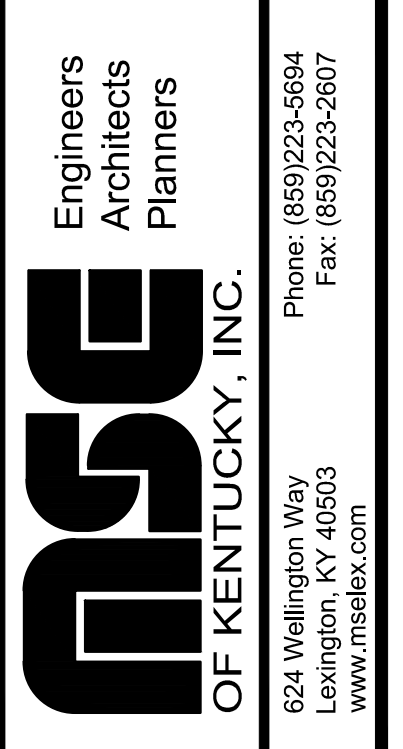

mse OF KENTUCKY, INC.
 Engineers
 Architects
 Planners
 624 Wellington Way
 Lexington, KY 40503
 Phone: (859)223-2684
 Fax: (859)223-2607
 www.mseinc.com

DRAWING NO.
UFL-L12 E-007-B