



DRYER AREA TOWER  
(LEVEL: 52'-0" 11/16")  
SCALE: 1/8" = 1'-0"

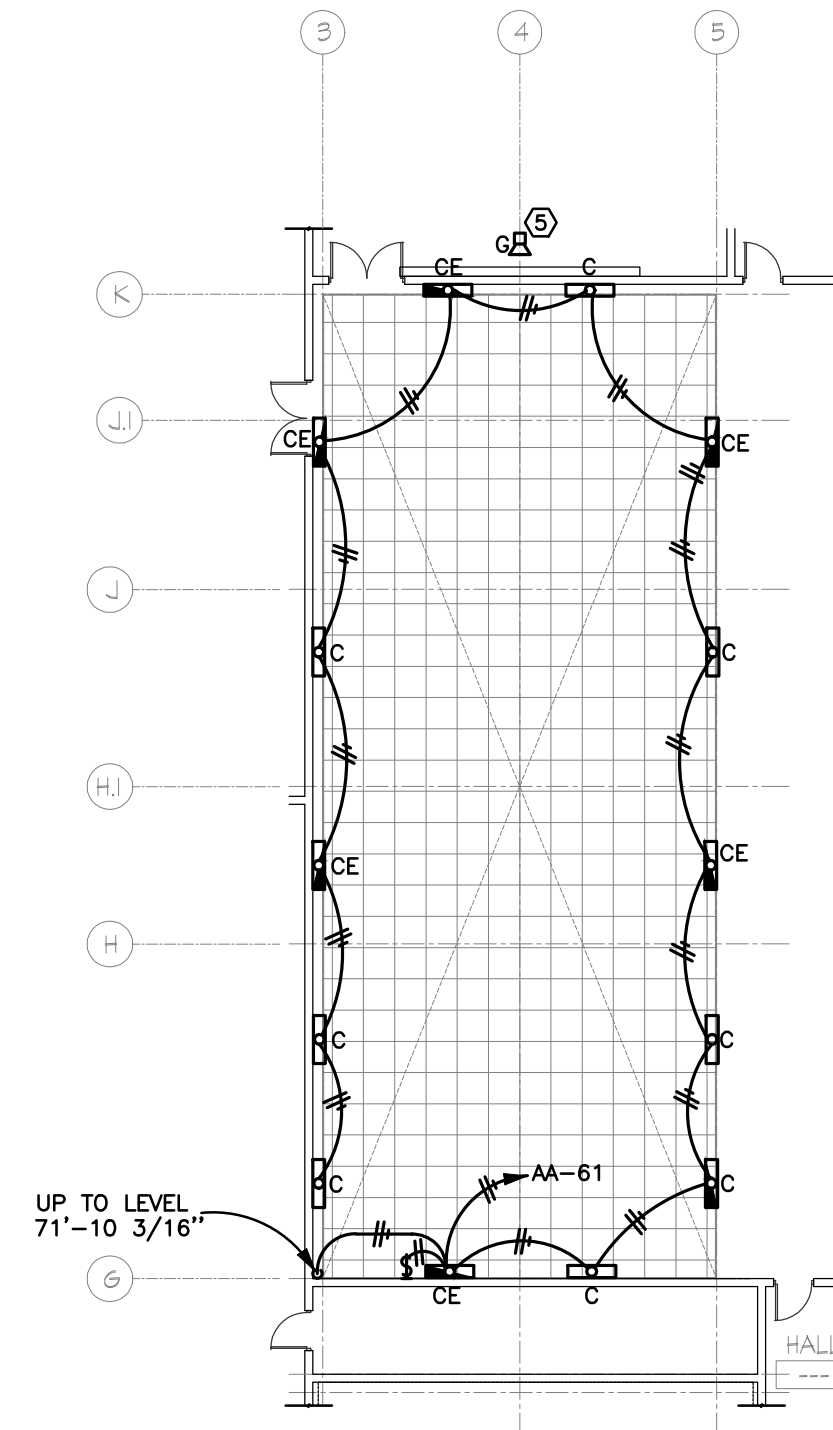


DRYER AREA TOWER  
(LEVEL: 58'-0" 11/16")  
SCALE: 1/8" = 1'-0"

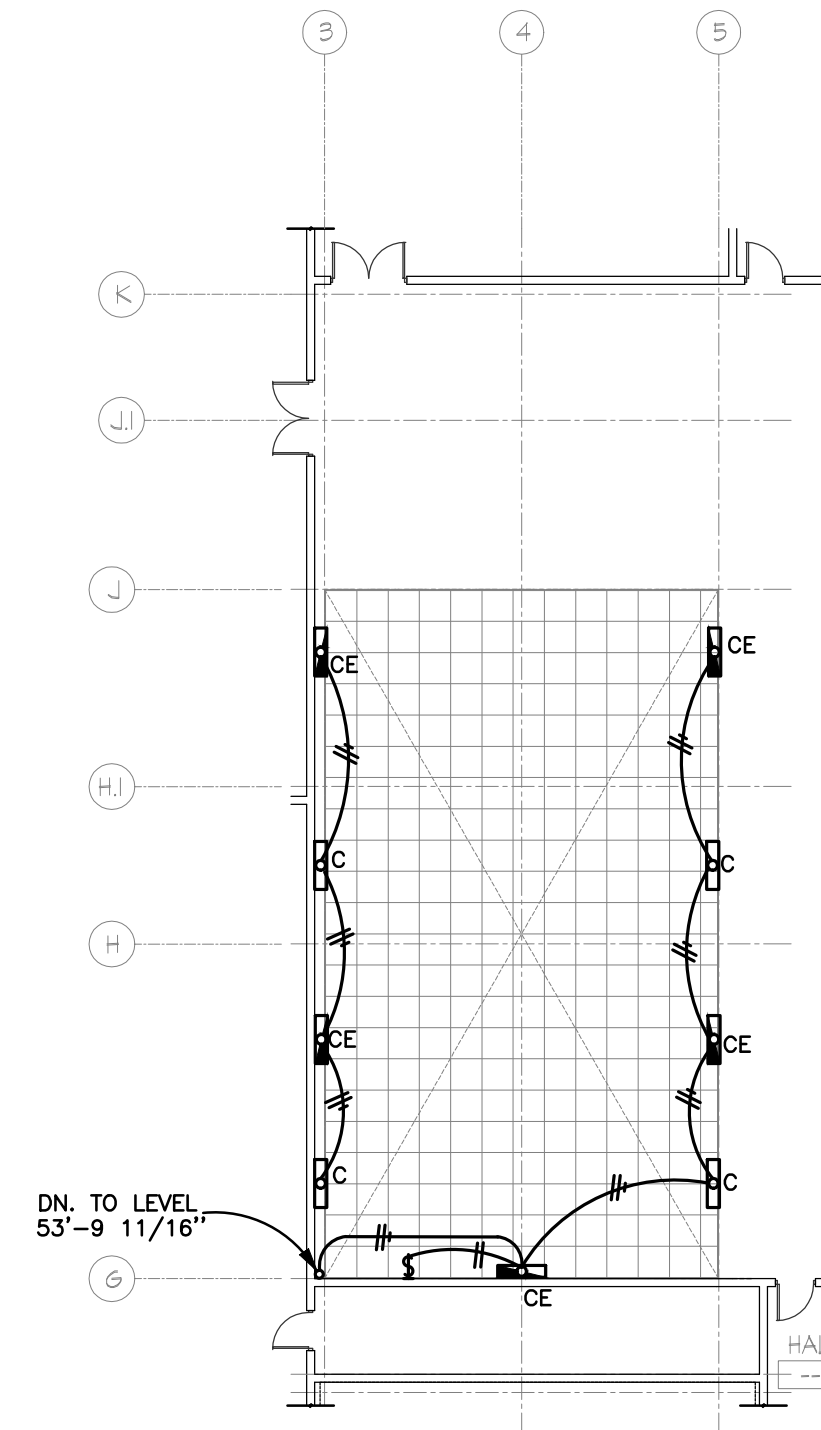

DRYER AREA TOWER  
(LEVEL: 71'-0" 3/16")  
SCALE: 1/8" = 1'-0"



**SHEET NOTES:**

- ① NOTE NOT USED.
- ② NOTE NOT USED.
- ③ NOTE NOT USED.
- ④ NOTE NOT USED.
- ⑤ FINAL MOUNTING HEIGHT OF FLOOD LIGHT FOR SIGN TO BE DETERMINED BY OWNER.
- ⑥ NOTE NOT USED.

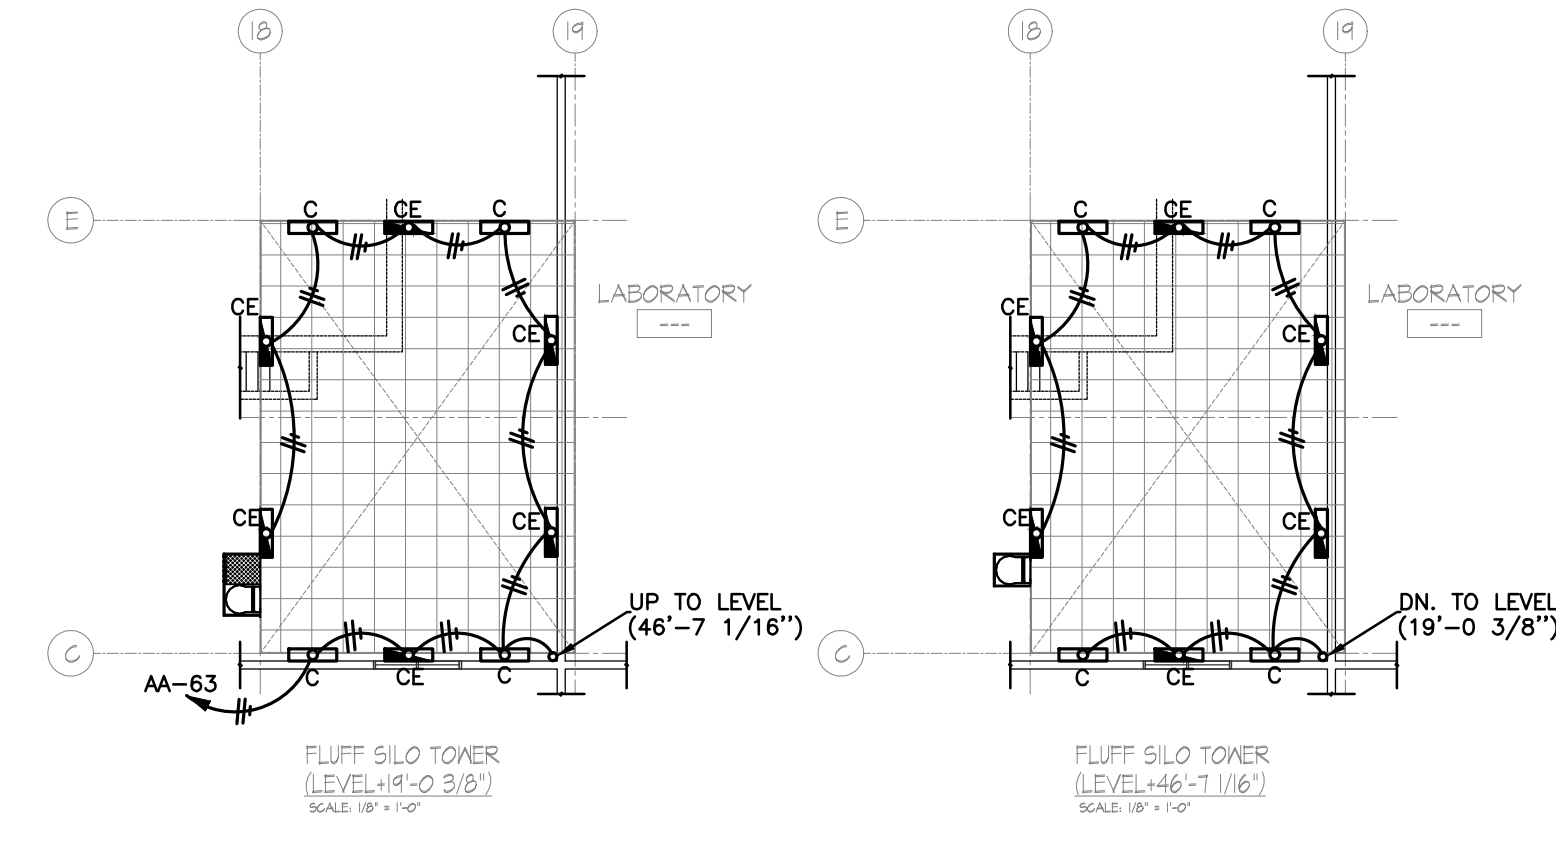

FLUFF SILO TOWER  
(LEVEL: 19'-0" 3/8")  
SCALE: 1/8" = 1'-0"

FLUFF SILO TOWER  
(LEVEL: 46'-1 1/8")  
SCALE: 1/8" = 1'-0"

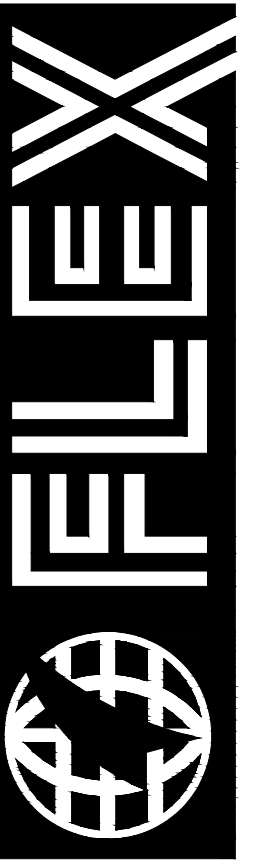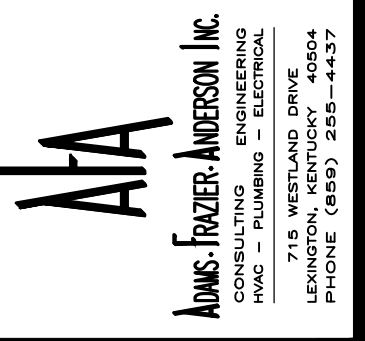


**FLEXFILMS, U.S.A., LLC**  
1221 NORTH BLACK BRANCH ROAD  
ELIZABETHTOWN, KENTUCKY 42702  
**PROJECT L-12 BOPET U.S.A.**

| DATE   | REVISION                             | BY |
|--------|--------------------------------------|----|
| NOV 11 | VALUE ENGINEERING RE-DESIGN DOCUMENT |    |

PROJECT NO. 8529-02  
 DESIGNED BY SHT  
 DRAWN BY JVB  
 CHECKED BY TBW  
 REVIEWED BY SHT  
 DATE JULY 2011  
 SCALE AS NOTED

**nse**  
OF KENTUCKY, INC.  
Engineers  
Architects  
Planners  
Phone: (859)223-5694  
624 Wellington Way  
Lexington, KY 40503  
Fax: (859)223-2607  
www.nselex.com

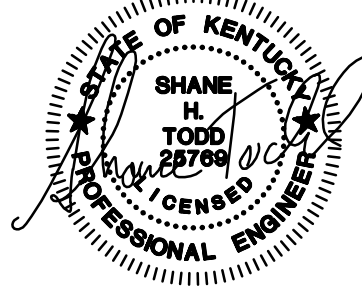

**DRYER AREA TOWER FLOOR LIGHTING PLANS**  
SCALE: 1/16" = 1'-0"

