



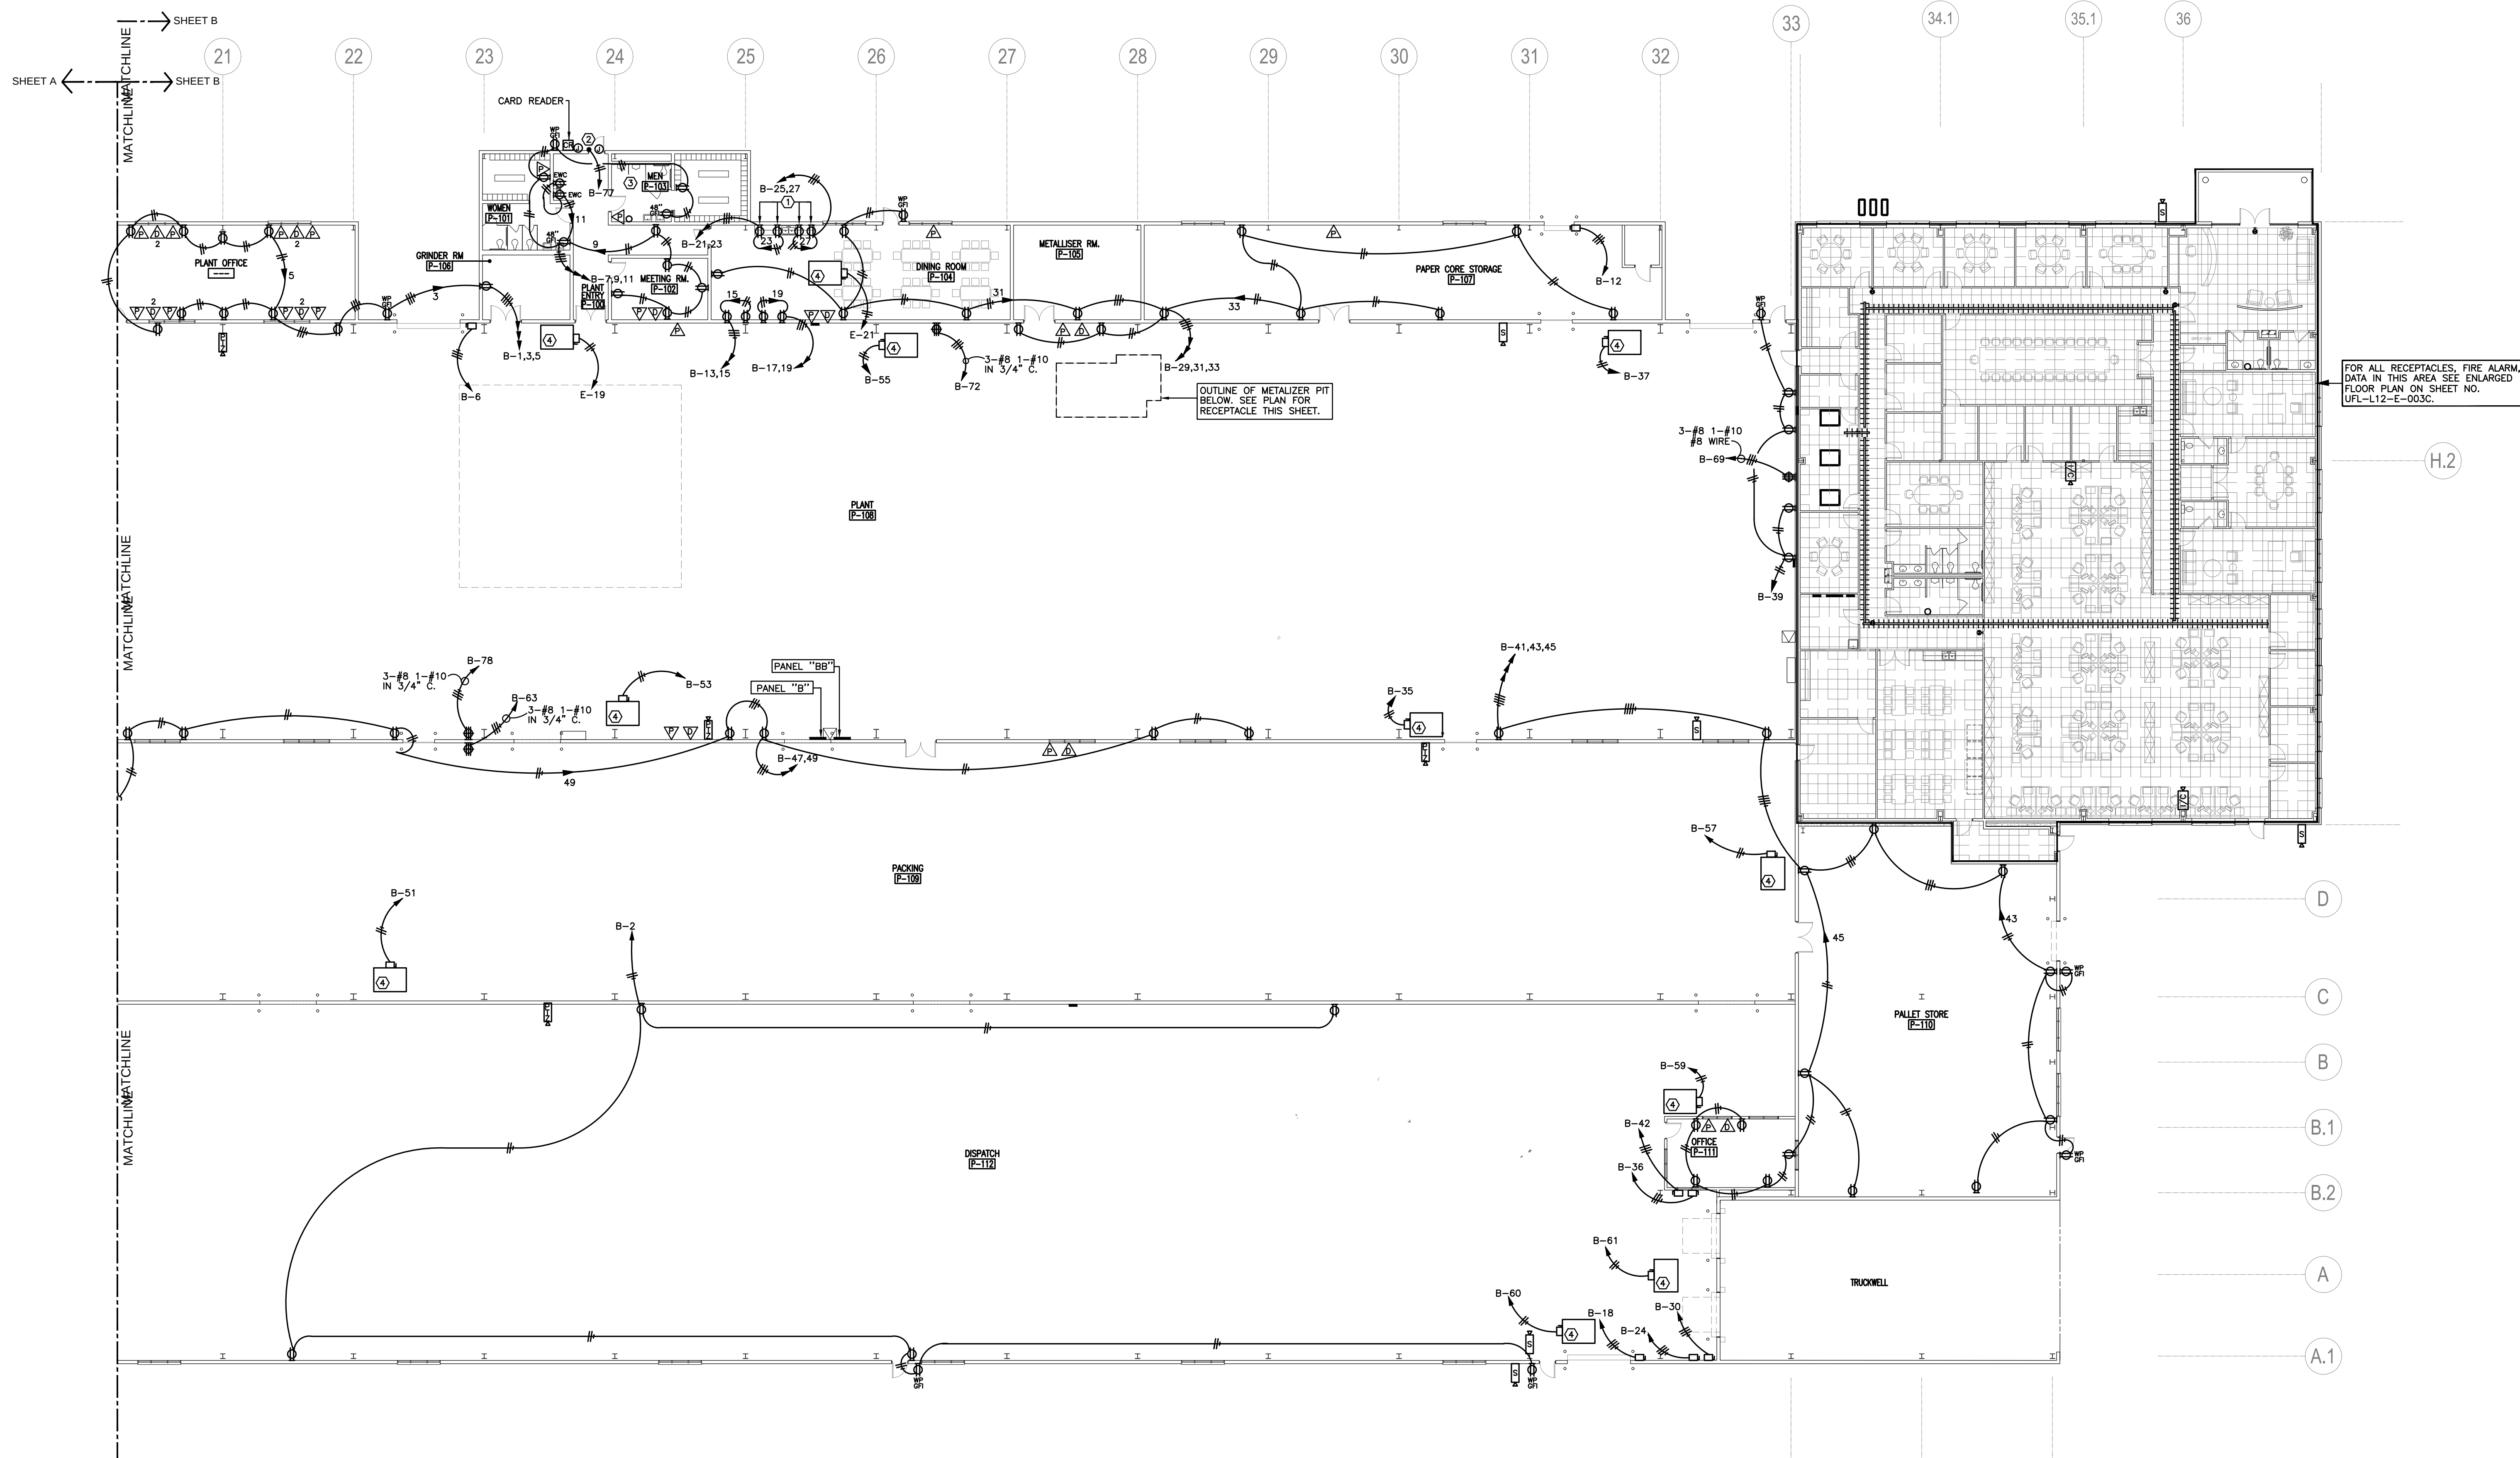


PARTIAL FIRST FLOOR RECEPTABLES, SIGNAL, DATA PLAN
SCALE: 1/16" = 1'-0"

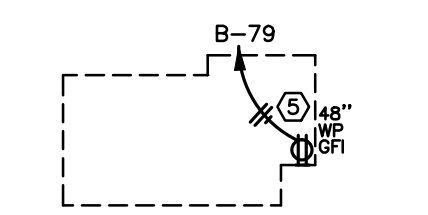

METALIZER PIT RECEPTACLE PLAN
SCALE: 1/16" = 1'-0"

SHEET NOTES:

- ① MOUNT RECEPTACLE BETWEEN TOP OF BASE CABINET AND BOTTOM OF WALL CABINET.
- ② ELECTRIC DOOR STRIKE WITH CARD READER. ACCESS ROUTE CABLING DOWN THROUGH DOOR FROM ELECTRIC STRIKE.
- ③ CONTRACTOR TO PROVIDE & WIRE TRANSFORMER FOR URINAL ELECTRONIC AUTOMATIC FLUSH VALVES.
- ④ INSECTICIDATOR BUG KILLER, SERIES S MODEL 508E OR EQUIVALENT BUG PREVENTION/KILLING DEVICE.
- ⑤ CONTRACTOR TO LOCATE RECEPTACLE AT LADDER, SEE ARCHITECTURAL DETAILS.

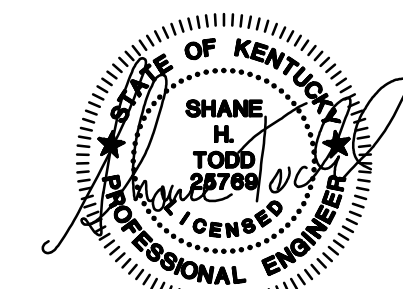

FLEXFILMS, U.S.A., LLC
1221 NORTH BLACK BRANCH ROAD
ELIZABETHTOWN, KENTUCKY 42702

PROJECT L-12 BOPET U.S.A.

**Engineers
Architects
Planners**

OF KENTUCKY, INC.

624 Wellington Way
Lexington, KY 40503
www.mseaz.com

Phone: (859)223-5664
Fax: (859)223-2607

DRAWING NO.

**UFL-L12
E-003B**

PROJECT NO. 8529-02
DESIGNED BY SHT
DRAWN BY JVB
CHECKED BY TBW
REVIEWED BY SHT
DATE JULY 2011
SCALE AS NOTED

DATE NOV 11
BY VALUE ENGINEERING RE-DESIGN DOCUMENT

THIS DOCUMENT IS THE PROPERTY OF M&E ENGINEERING, INC. AND IS NOT TO BE REPRODUCED OR TRANSMITTED IN ANY FORM OR BY ANY MEANS, ELECTRONIC OR MECHANICAL, INCLUDING PHOTOCOPYING, RECORDING, OR BY ANY INFORMATION STORAGE AND RETRIEVAL SYSTEM, WITHOUT THE WRITTEN PERMISSION OF M&E ENGINEERING, INC.