


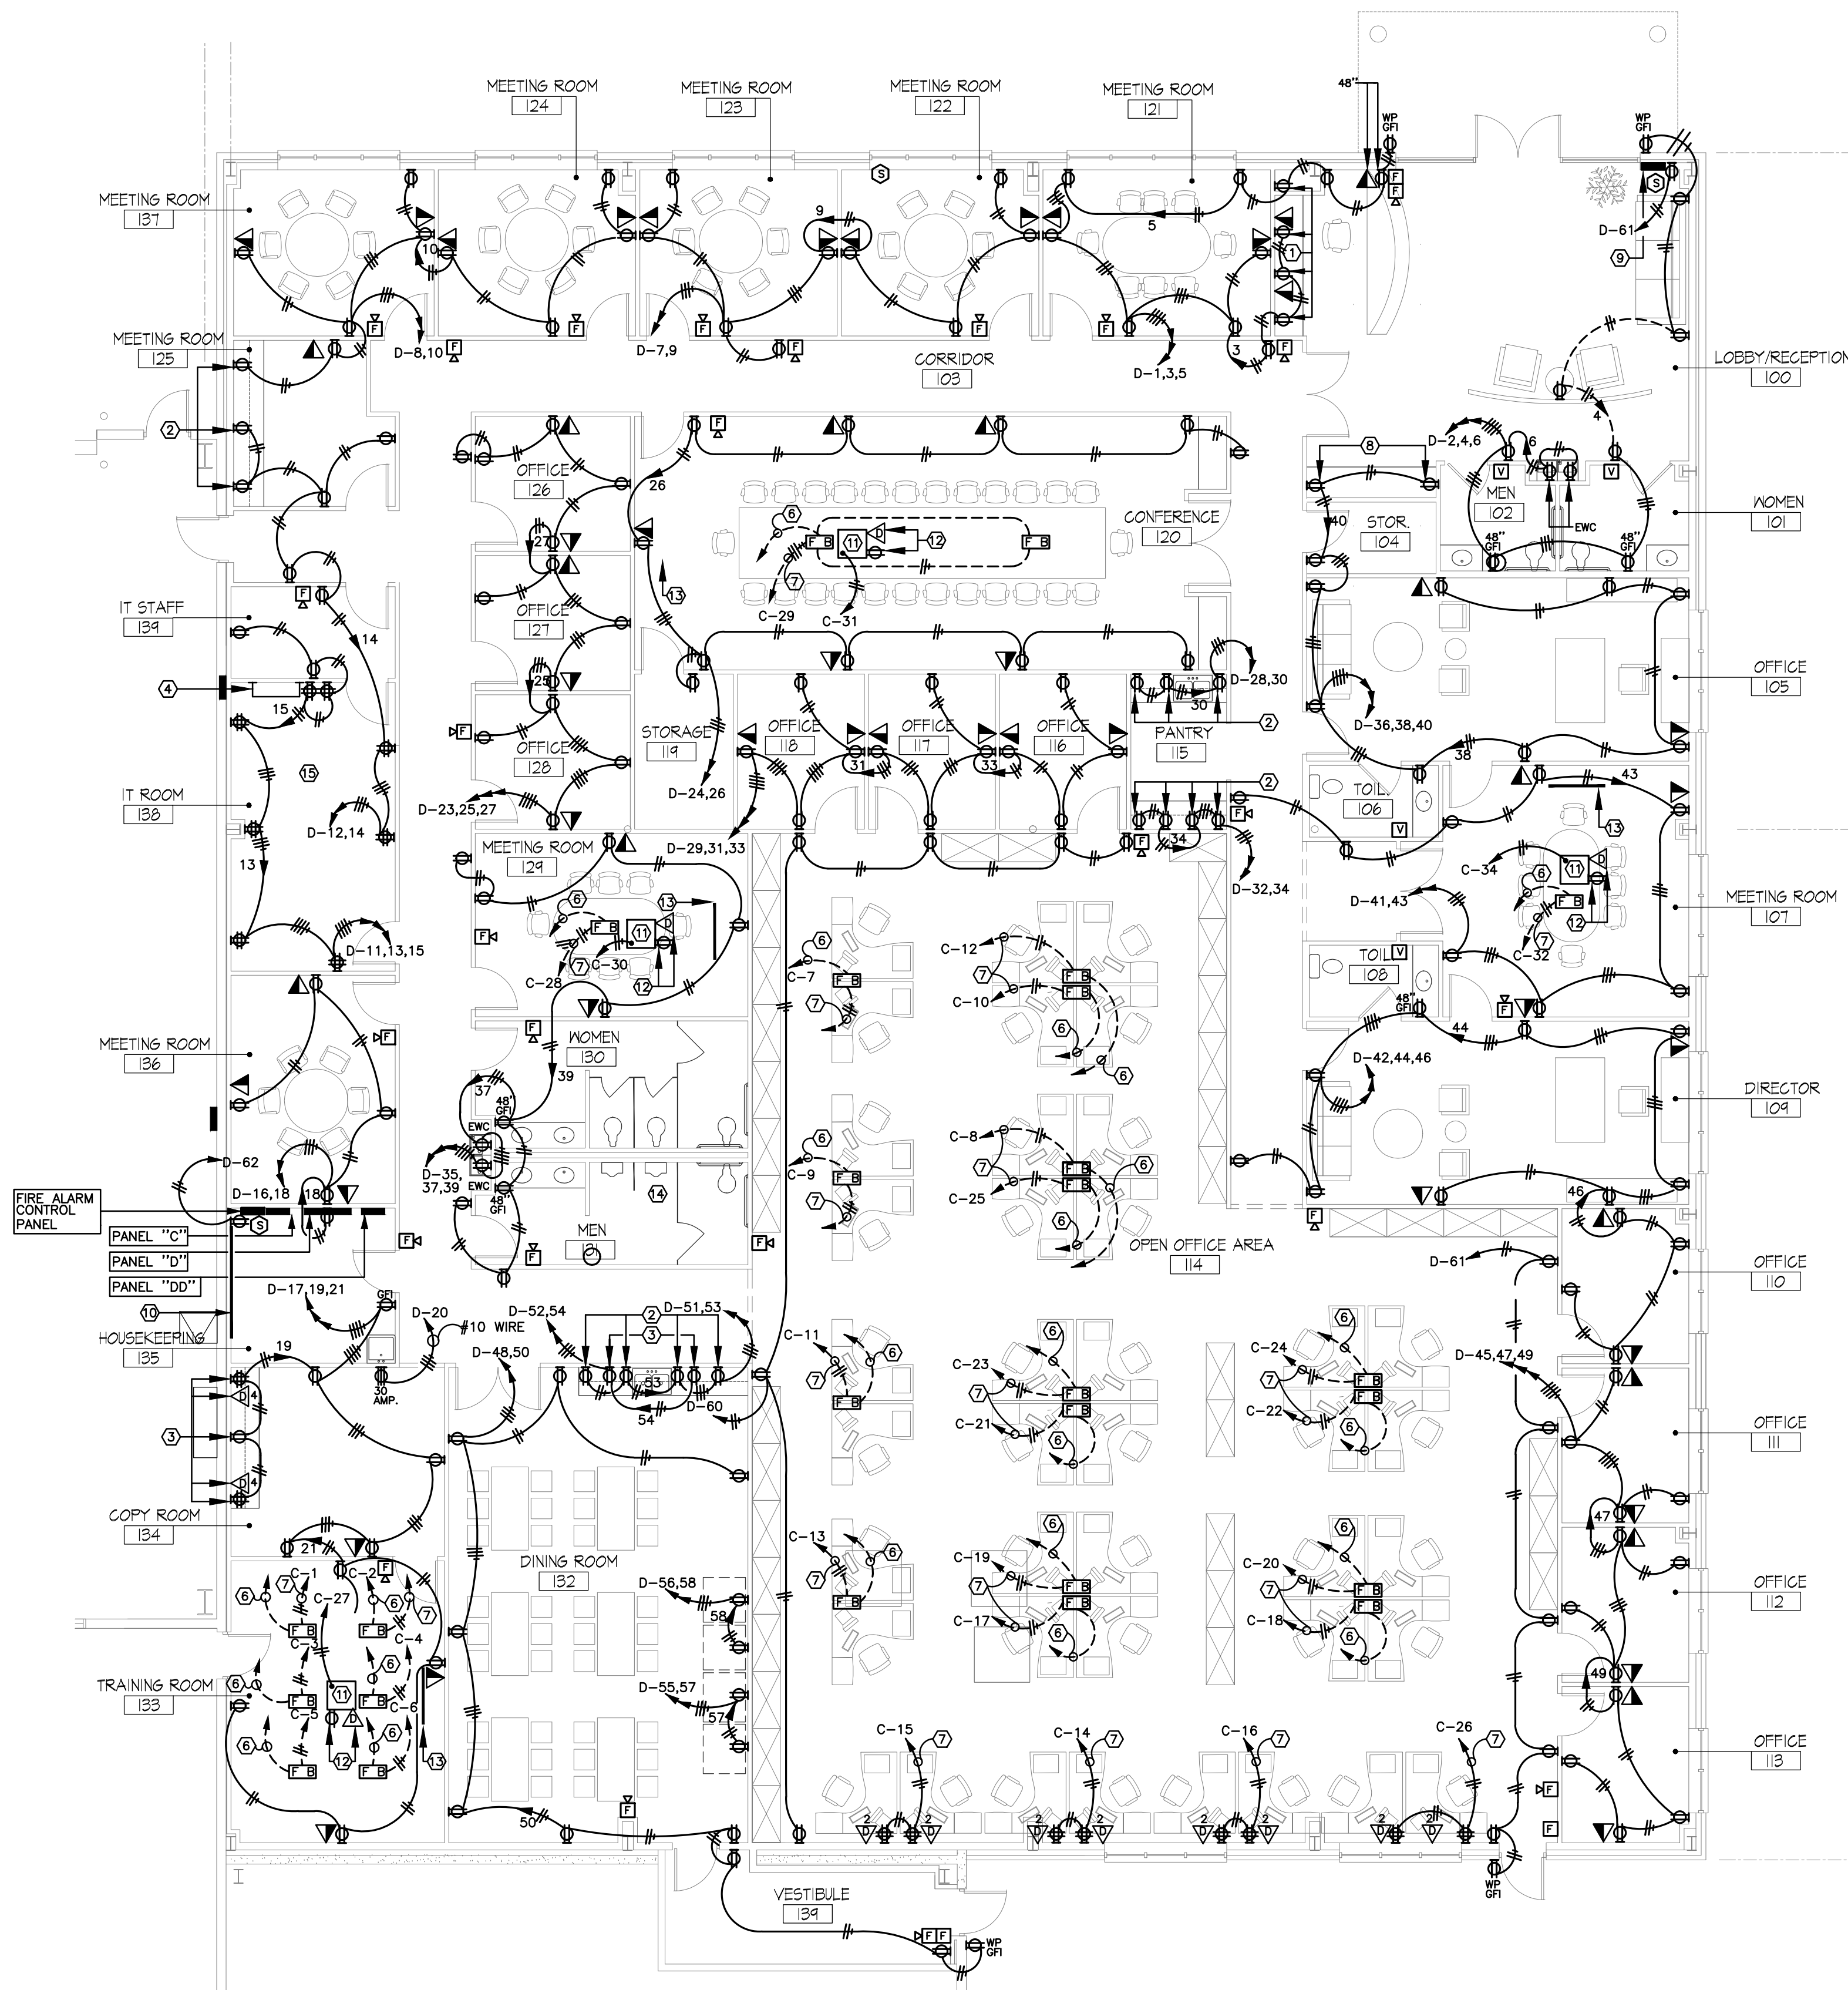


FLUSH FLOOR BOX SPECIFICATION:

- FB** SYMBOL = ONE WALKER RESOURCE RFB FLOOR BOX (4 COMPARTMENT)
 A. EACH FLOOR BOX TO ACCOMMODATE FOUR DUPLEX RECEPTACLES
 B. TWO DUPLEX RECEPTACLES PER COMPARTMENT - TOTAL OF TWO
 C. TWO REMAINING COMPARTMENTS SHALL BE FOR OWNERS VOICE/DATA
 REQUIREMENTS. EACH VOICE/DATA COMPARTMENT SHALL BE INSTALLED
 WITH ONE-1" CONDUIT TO ABOVE CEILING.
 D. EACH FLOOR BOX TO BE PROVIDED WITH VOICE/DATA/RECEPTACLE
 BRACKETS. CONTRACTOR TO PROVIDE RECEPTACLES FOR FLOOR BOX.
 E. PROVIDE VOICE/DATA JACKS, ETC. FOR FLOOR BOXES.
 F. BRASS ACTIVATION COVERPLATE WITH INSERT. PROVIDE EXACT TYPE INSERT TO MATCH
 EXISTING FLOOR COVERING TYPE.
 1. VERIFY WITH THE OWNER THE EXACT LOCATION OF ALL FLOOR BOXES BEFORE
 STARTING INSTALLATION. COORDINATE WITH OWNER FOR FURNITURE TYPE AND LOCATION.

SHEET NOTES:

1. MOUNT RECEPTACLE AND DATA OUTLET AT 48" ABOVE FINISHED FLOOR.
2. MOUNT RECEPTACLE BETWEEN TOP OF BASE CABINET AND BOTTOM OF WALL CABINET.
3. MOUNT RECEPTACLE 9" BELOW WALL CABINET FOR CONNECTION TO MICROWAVE.
4. GROUND BAR, SEE DETAIL THIS SHEET.
5. MOUNT RECEPTACLE AND DATA OUTLET BETWEEN TOP OF BASE CABINET AND BOTTOM OF WALL CABINET.
6. 3/4" CONDUIT FOR DATA CABLE.
7. PROVIDE SEPARATE NEUTRAL FOR EACH CIRCUIT IN OPEN OFFICE AREA, OR AS SHOWN.
8. CONTRACTOR TO LOCATE RECEPTACLE PER OWNERS REQUEST.
9. FIRE ALARM ANNUNCIATOR PANEL.
10. PROVIDE 4' X 8' X 3/4" THICK PLYWOOD BOARD. PAINT 2 COATS OF FIRE RESISTANT PAINT.
11. CEILING MOUNTED PROJECTOR.
12. RECEPTACLE & DATA OUTLET MOUNTED ABOVE CEILING AT PROJECTOR.
13. PROJECTION SCREEN MOUNTED AT CEILING.
14. CONTRACTOR TO PROVIDE & WIRE TRANSFORMER FOR URINAL
ELECTRONIC AUTOMATIC FLUSH VALVES.
15. PROVIDE 2-4" CONDUITS FOR VOICE AND DATA SERVICES. COORDINATE
FINAL TERMINATION OF CONDUITS WITH VOICE AND DATA PROVIDERS.

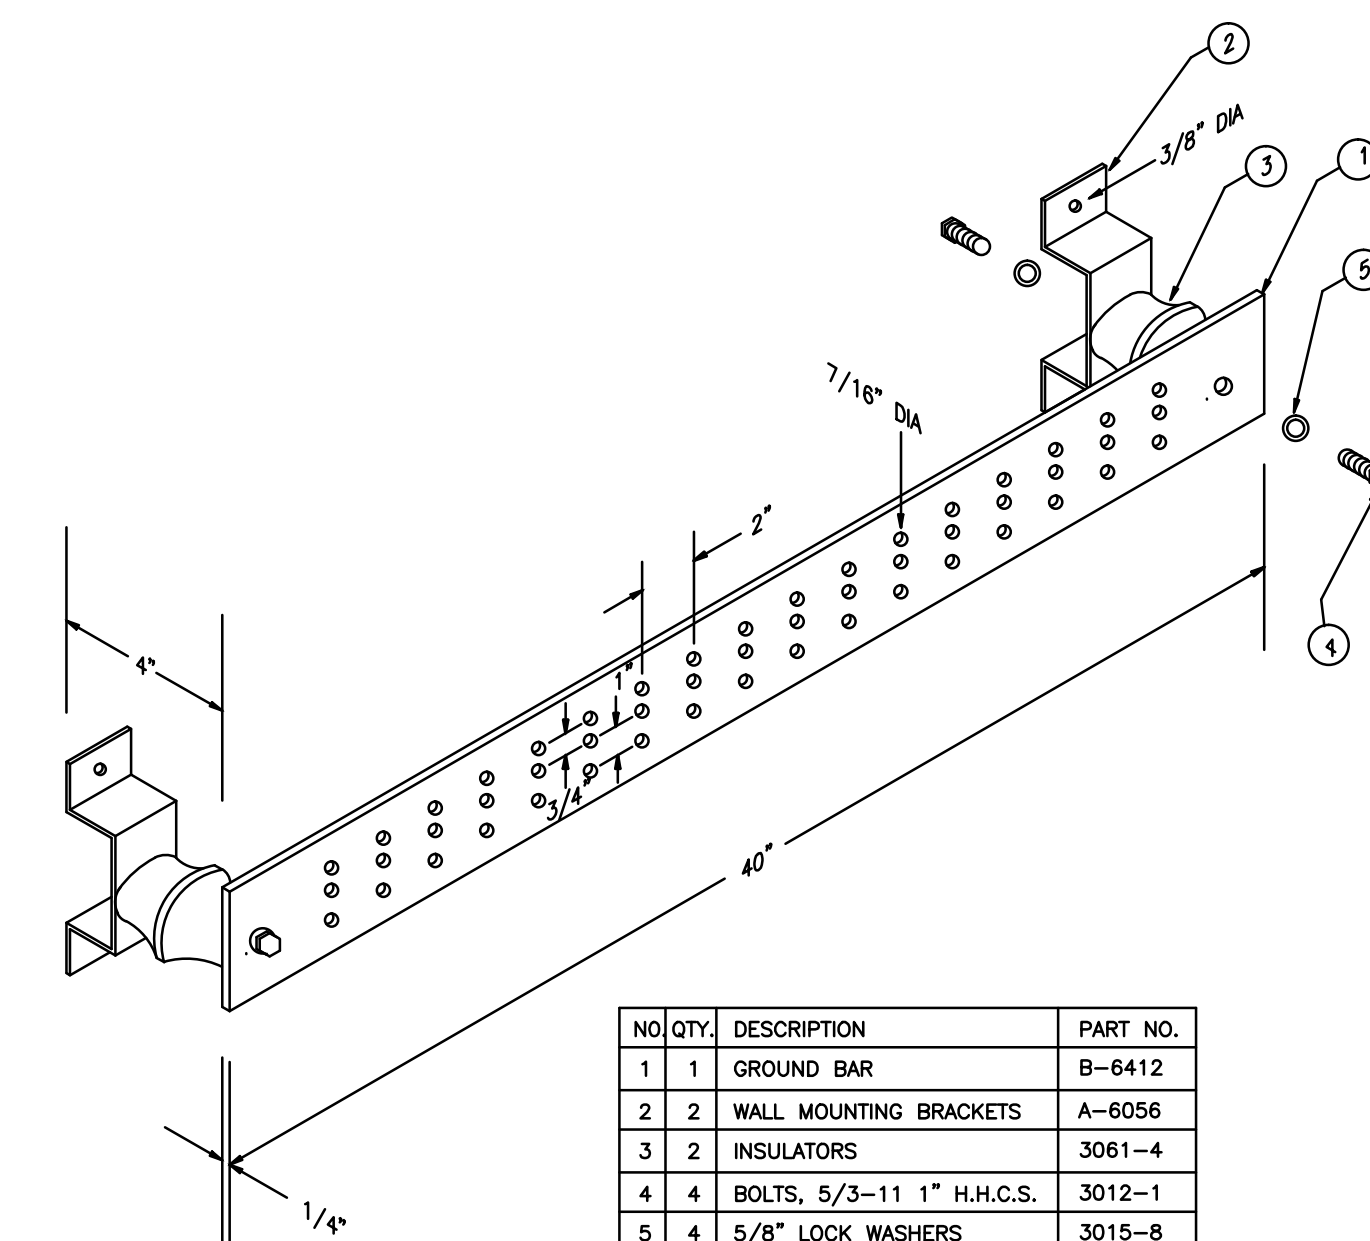

GROUND BAR DETAIL

NOT TO SCALE

ENLARGED OFFICE FLOOR PLAN — RECEPTACLE, SIGNAL, DATA

SCALE: 1/8"= 1'-0"

