


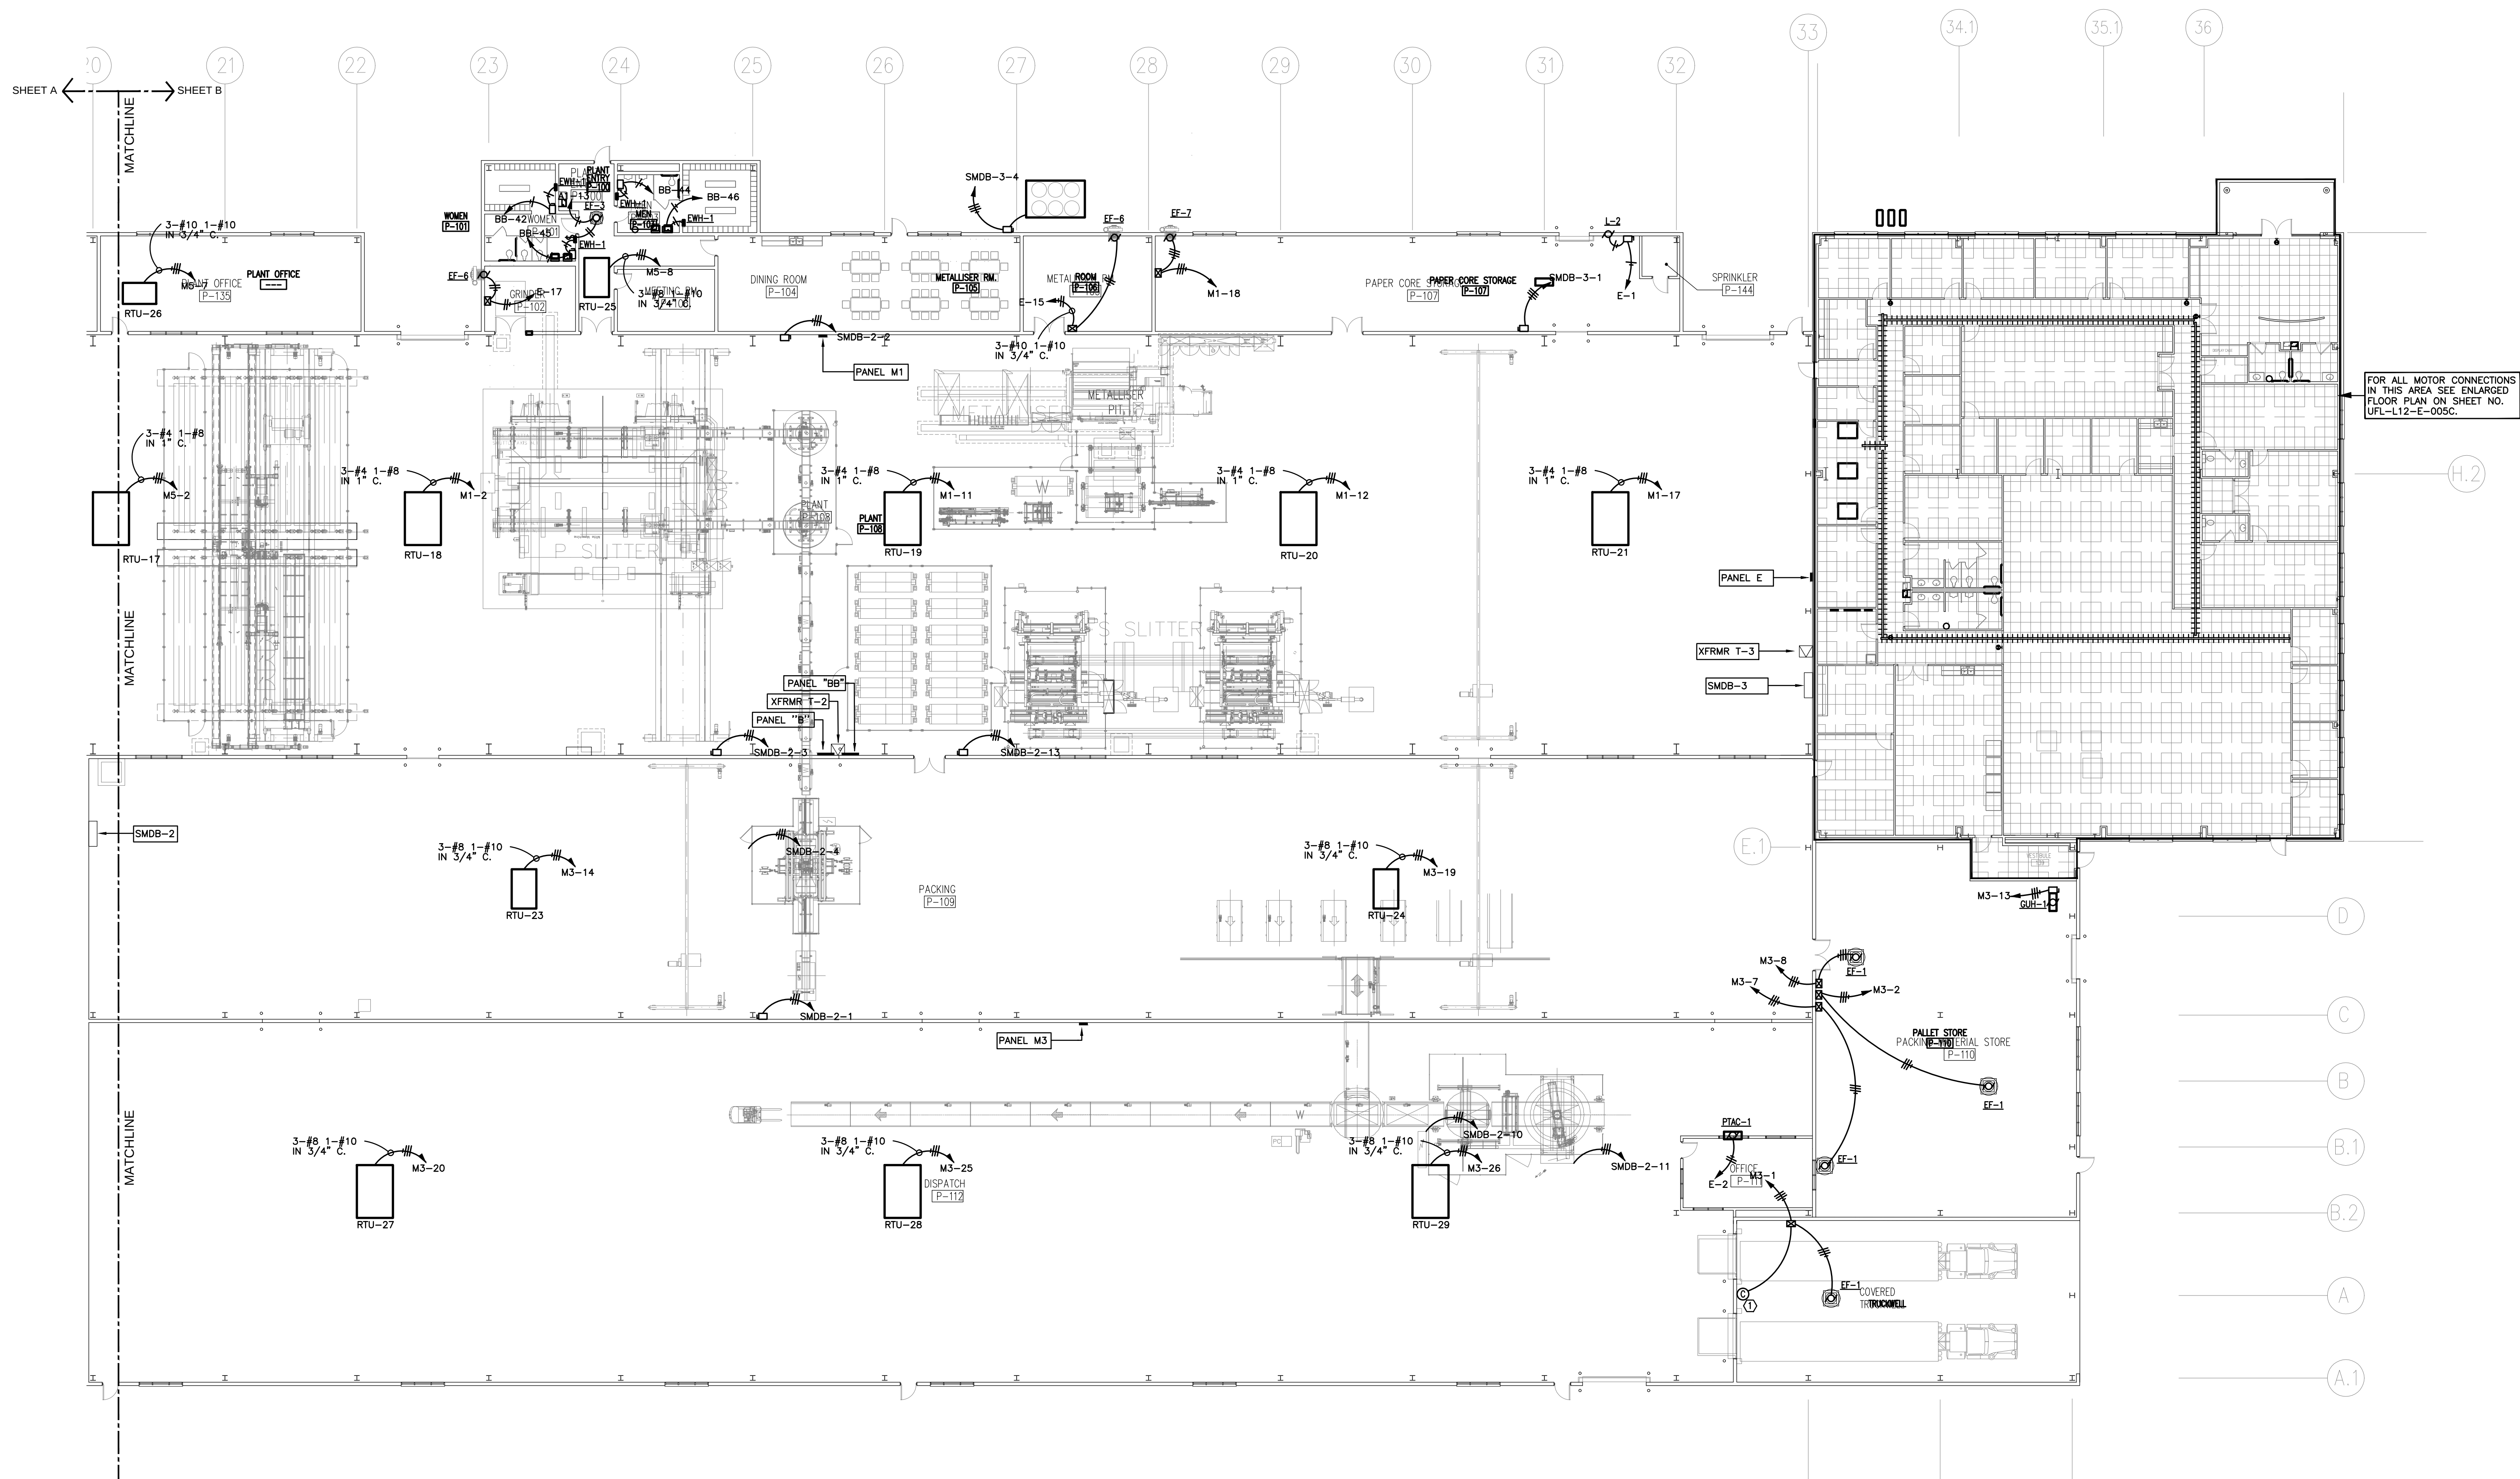

GENERAL NOTES:


- ALL DISCONNECT SWITCHES, MOTOR STARTERS SHALL BE MOUNTED ADJACENT BUT SEPARATE FROM EQUIPMENT SERVED. CONTRACTOR SHALL MOUNT DISCONNECT SWITCHES, STARTERS ON ADJACENT WALLS OR PROVIDE A UNISTRUT MOUNTING FRAME IN ORDER TO MAKE DISCONNECT OF STARTER ACCESSIBLE. "DISCONNECT SWITCHES, MOTOR STARTERS SHALL NOT TO MOUNTED ON EQUIPMENT".
- ALL DISCONNECT SWITCHES, MOTOR STARTERS, COMBINATION STARTER/DISCONNECT SWITCHES SHALL BE 30 AMP., UNLESS OTHERWISE NOTED.
- ALL DISCONNECT SWITCHES, MOTOR STARTERS, COMBINATION STARTER/DISCONNECT SWITCHES TO BE MOUNTED IN CLEAR AREA NOT NECESSARY AT POINT SHOWN ON PLANS.
- ALL FAN MOTOR STARTERS TO HAVE GREEN "ON" INDICATOR LIGHT.

SHEET NOTES:

- ① PROVIDE CARBON MONOXIDE MONITOR TO ACTIVATE EXHAUST FANS WHEN CO LEVEL REACHES 25 PPM.

PARTIAL FIRST FLOOR MOTOR CONNECTION PLAN

SCALE: 1/16" = 1'-0"

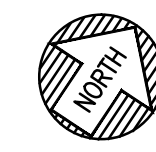

DATE	REVISION	BY
NOV 11	VALUE ENGINEERING RE-DESIGN DOCUMENT	
JAN 20 12	REVISIONS ASSOCIATED WITH REVISED FLOOR PLAN	

THIS DOCUMENT IS THE PROPERTY OF FLEXFILMS, U.S.A., LLC. IT IS TO BE USED ONLY FOR THE PROJECT AND SITE SPECIFICALLY IDENTIFIED HEREIN. IT IS NOT TO BE REPRODUCED, COPIED, OR TRANSMITTED IN ANY FORM OR BY ANY MEANS, ELECTRONIC OR MECHANICAL, INCLUDING PHOTOCOPYING, RECORDING, OR BY ANY INFORMATION STORAGE AND RETRIEVAL SYSTEM, WITHOUT THE WRITTEN PERMISSION OF FLEXFILMS, U.S.A., LLC.

PROJECT NO. 8529-02	DESIGNED BY JVB	DRAWN BY JVB	CHECKED BY SHT	REVIEWED BY SHT	DATE JULY 2011	SCALE AS NOTED
---------------------	-----------------	--------------	----------------	-----------------	----------------	----------------

