

FOR ALL MOTOR CONNECTIONS IN THIS AREA SEE ENLARGED FLOOR PLAN ON SHEET NO. UFL-L12-E-005C.

GENERAL NOTES:



- A. ALL DISCONNECT SWITCHES, MOTOR STARTERS SHALL BE MOUNTED ADJACENT BUT SEPARATE FROM EQUIPMENT SERVED. CONTRACTOR SHALL MOUNT DISCONNECT SWITCHES, STARTERS ON ADJACENT WALLS OR PROVIDE A UNISTRUT MOUNTING FRAME IN ORDER TO MAKE DISCONNECT OF STARTER ACCESSIBLE. "DISCONNECT SWITCHES, MOTOR STARTERS SHALL NOT TO MOUNTED ON EQUIPMENT".
- B. ALL DISCONNECT SWITCHES, MOTOR STARTERS, COMBINATION STARTER/DISCONNECT SWITCHES SHALL BE 30 AMP., UNLESS OTHERWISE NOTED.
- C. ALL DISCONNECT SWITCHES, MOTOR STARTERS, COMBINATION STARTER/DISCONNECT SWITCHES TO BE MOUNTED IN CLEAR AREA NOT NECESSARY AT POINT SHOWN ON PLANS.
- D. ALL FAN MOTOR STARTERS TO HAVE GREEN "ON" INDICATOR LIGHT.

SHEET NOTES:

- ① PROVIDE CARBON MONOXIDE MONITOR TO ACTIVATE EXHAUST FANS WHEN CO LEVEL REACHES 25 PPM.

PARTIAL FIRST FLOOR MOTOR CONNECTION PLAN

SCALE: 1/16" = 1'-0"

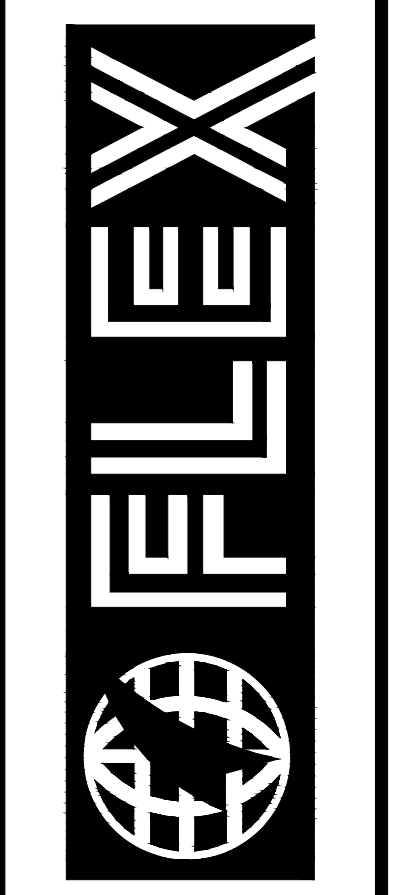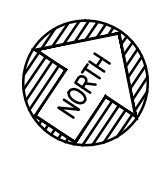

FLEXFILMS, U.S.A., LLC
 1221 NORTH BLACK BRANCH ROAD
 ELIZABETHTOWN, KENTUCKY 42702
 PROJECT L-12 BOPET U.S.A.

| DATE | REVISION |
|-----------|---|
| MAY 11 | VALUE ENGINEERING RE-DESIGN DOCUMENT |
| JAN 20 12 | REVISIONS ASSOCIATED WITH REISED FLOOR PLAN |

This document is the property of M&E Associates, Inc. and is to be used only for the project and location specified. It is not to be reproduced, stored in a retrieval system, or transmitted in any form or by any means, electronic, mechanical, photocopying, recording, or by any information storage and retrieval system, without the prior written permission of M&E Associates, Inc.

| |
|---------------------|
| PROJECT NO. 8529-02 |
| DESIGNED BY JVB |
| DRAWN BY JVB |
| CHECKED BY SHT |
| REVIEWED BY SHT |
| DATE JULY 2011 |
| SCALE AS NOTED |

M&E
 OF KENTUCKY, INC.
 Engineers
 Architects
 Planners
 Phone: (859)223-5694
 624 Wellington Way
 Lexington, KY 40503
 Fax: (859)223-5607
 www.m&e.com

