


**SHEET NOTES:**

1. PANEL TO BE PROVIDED BY MACHINE PROVIDER. ELECTRICIAN TO INSTALL MACHINE CABLING ON ALL MACHINE PANELS PER MACHINE DRAWING.
2. CONTRACTOR TO PROVIDE TRENCH, CONDUIT PER KENTUCKY UTILITIES STANDARD. MIN. DEPTH OF 42".
3. KENTUCKY UTILITIES TO PULL CABLE.
4. CIRCUIT REQUIRES A NEUTRAL.
5. WIRE 4-20 mA 0-480V AND 0-60HZ WIRES FROM EACH INCOMING SERVICE BREAKER TO PANEL CONTROL PANEL 6 H1 IN MAIN CONTROL ROOM P-126.

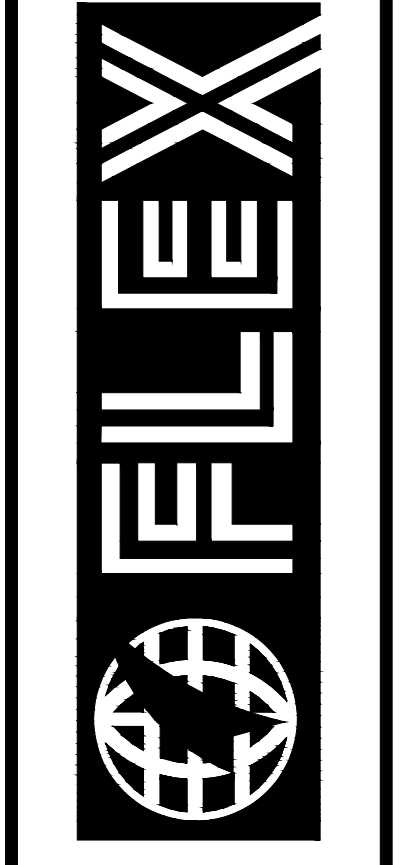

**FLEXFILMS, U.S.A., LLC**  
 1221 NORTH BLACK BRANCH ROAD  
 ELIZABETHTOWN, KENTUCKY 42702  
 PROJECT L-12 BOPET U.S.A.

DATE	REVISION
NOV 11 11	VALUE ENGINEERING RE-DESIGN DOCUMENT
NOV 23 11	ADDENDUM
JAN 09 12	REVISION ASSOCIATED WITH REVISED FLOOR PLAN


DESIGN DOCUMENTS ARE THE PROPERTY OF ENGINEERS ARCHITECTS PLANNERS OF KENTUCKY, INC. AND ARE TO BE USED ONLY FOR THE PROJECT AND SITE SPECIFICALLY IDENTIFIED IN THESE DOCUMENTS. ANY REUSE OR REPRODUCTION OF THESE DOCUMENTS WITHOUT THE WRITTEN PERMISSION OF ENGINEERS ARCHITECTS PLANNERS OF KENTUCKY, INC. IS STRICTLY PROHIBITED.

**Engineers  
Architects  
Planners**

**OF KENTUCKY, INC.**

624 Washington Way  
 Lexington, KY 40503  
 Phone: (502) 223-6544  
 Fax: (502) 223-2607  
 www.msbkva.com

DRAWING NO.  
 UFL-L12  
 E-007-B

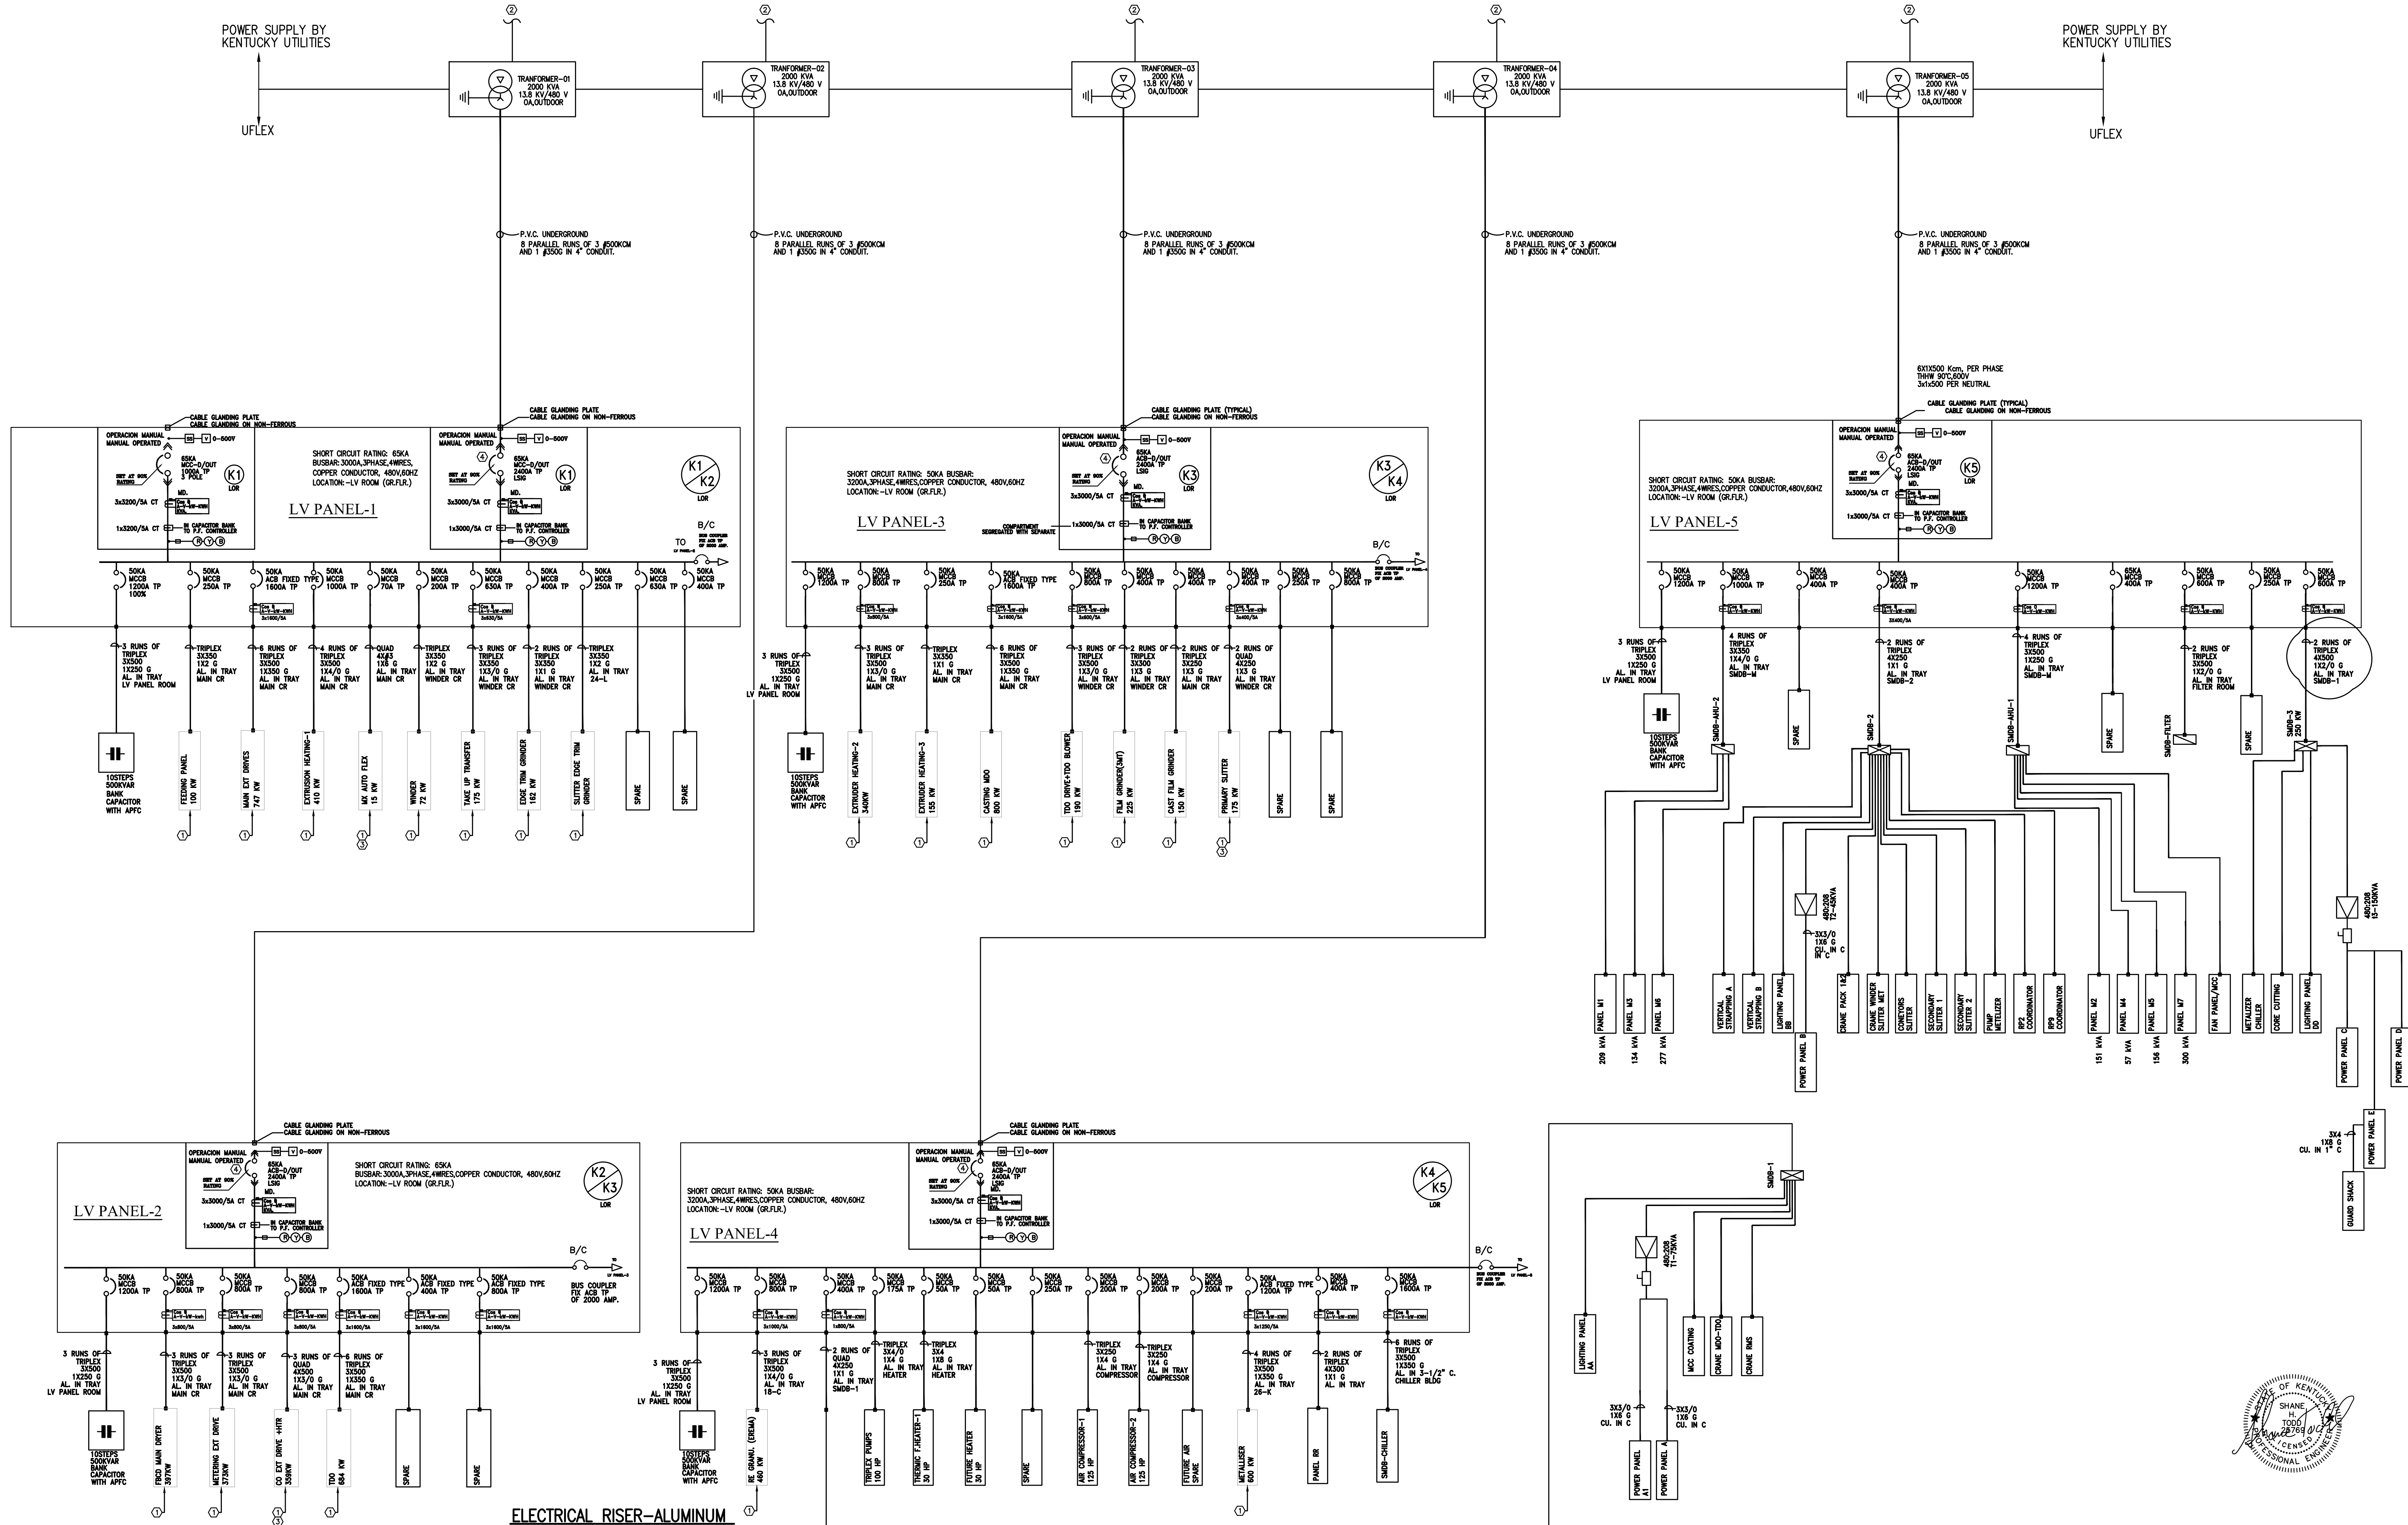

**ELECTRICAL RISER-ALUMINUM**

VALUE ENGINEERING RE-DESIGN DOCUMENT, NOVEMBER 11, 2011

**ELECTRICAL RISER-ALUMINUM**

