






FIRE ALARM LEGEND	
SYMBOL	DESCRIPTION
	SMOKE DETECTOR (ADDRESSABLE)
	HEAT DETECTOR (ADDRESSABLE)
	MONITOR MODULE
	BREAK GLASS UNIT
	4 LOOP ADD. FIRE ALARM CONTROL PANEL
	A/V FIRE ALARM DEVICE
	STROBE FLASHER
	BEAM DETECTOR TRANSMITTER
	BEAM DETECTOR RECEIVER

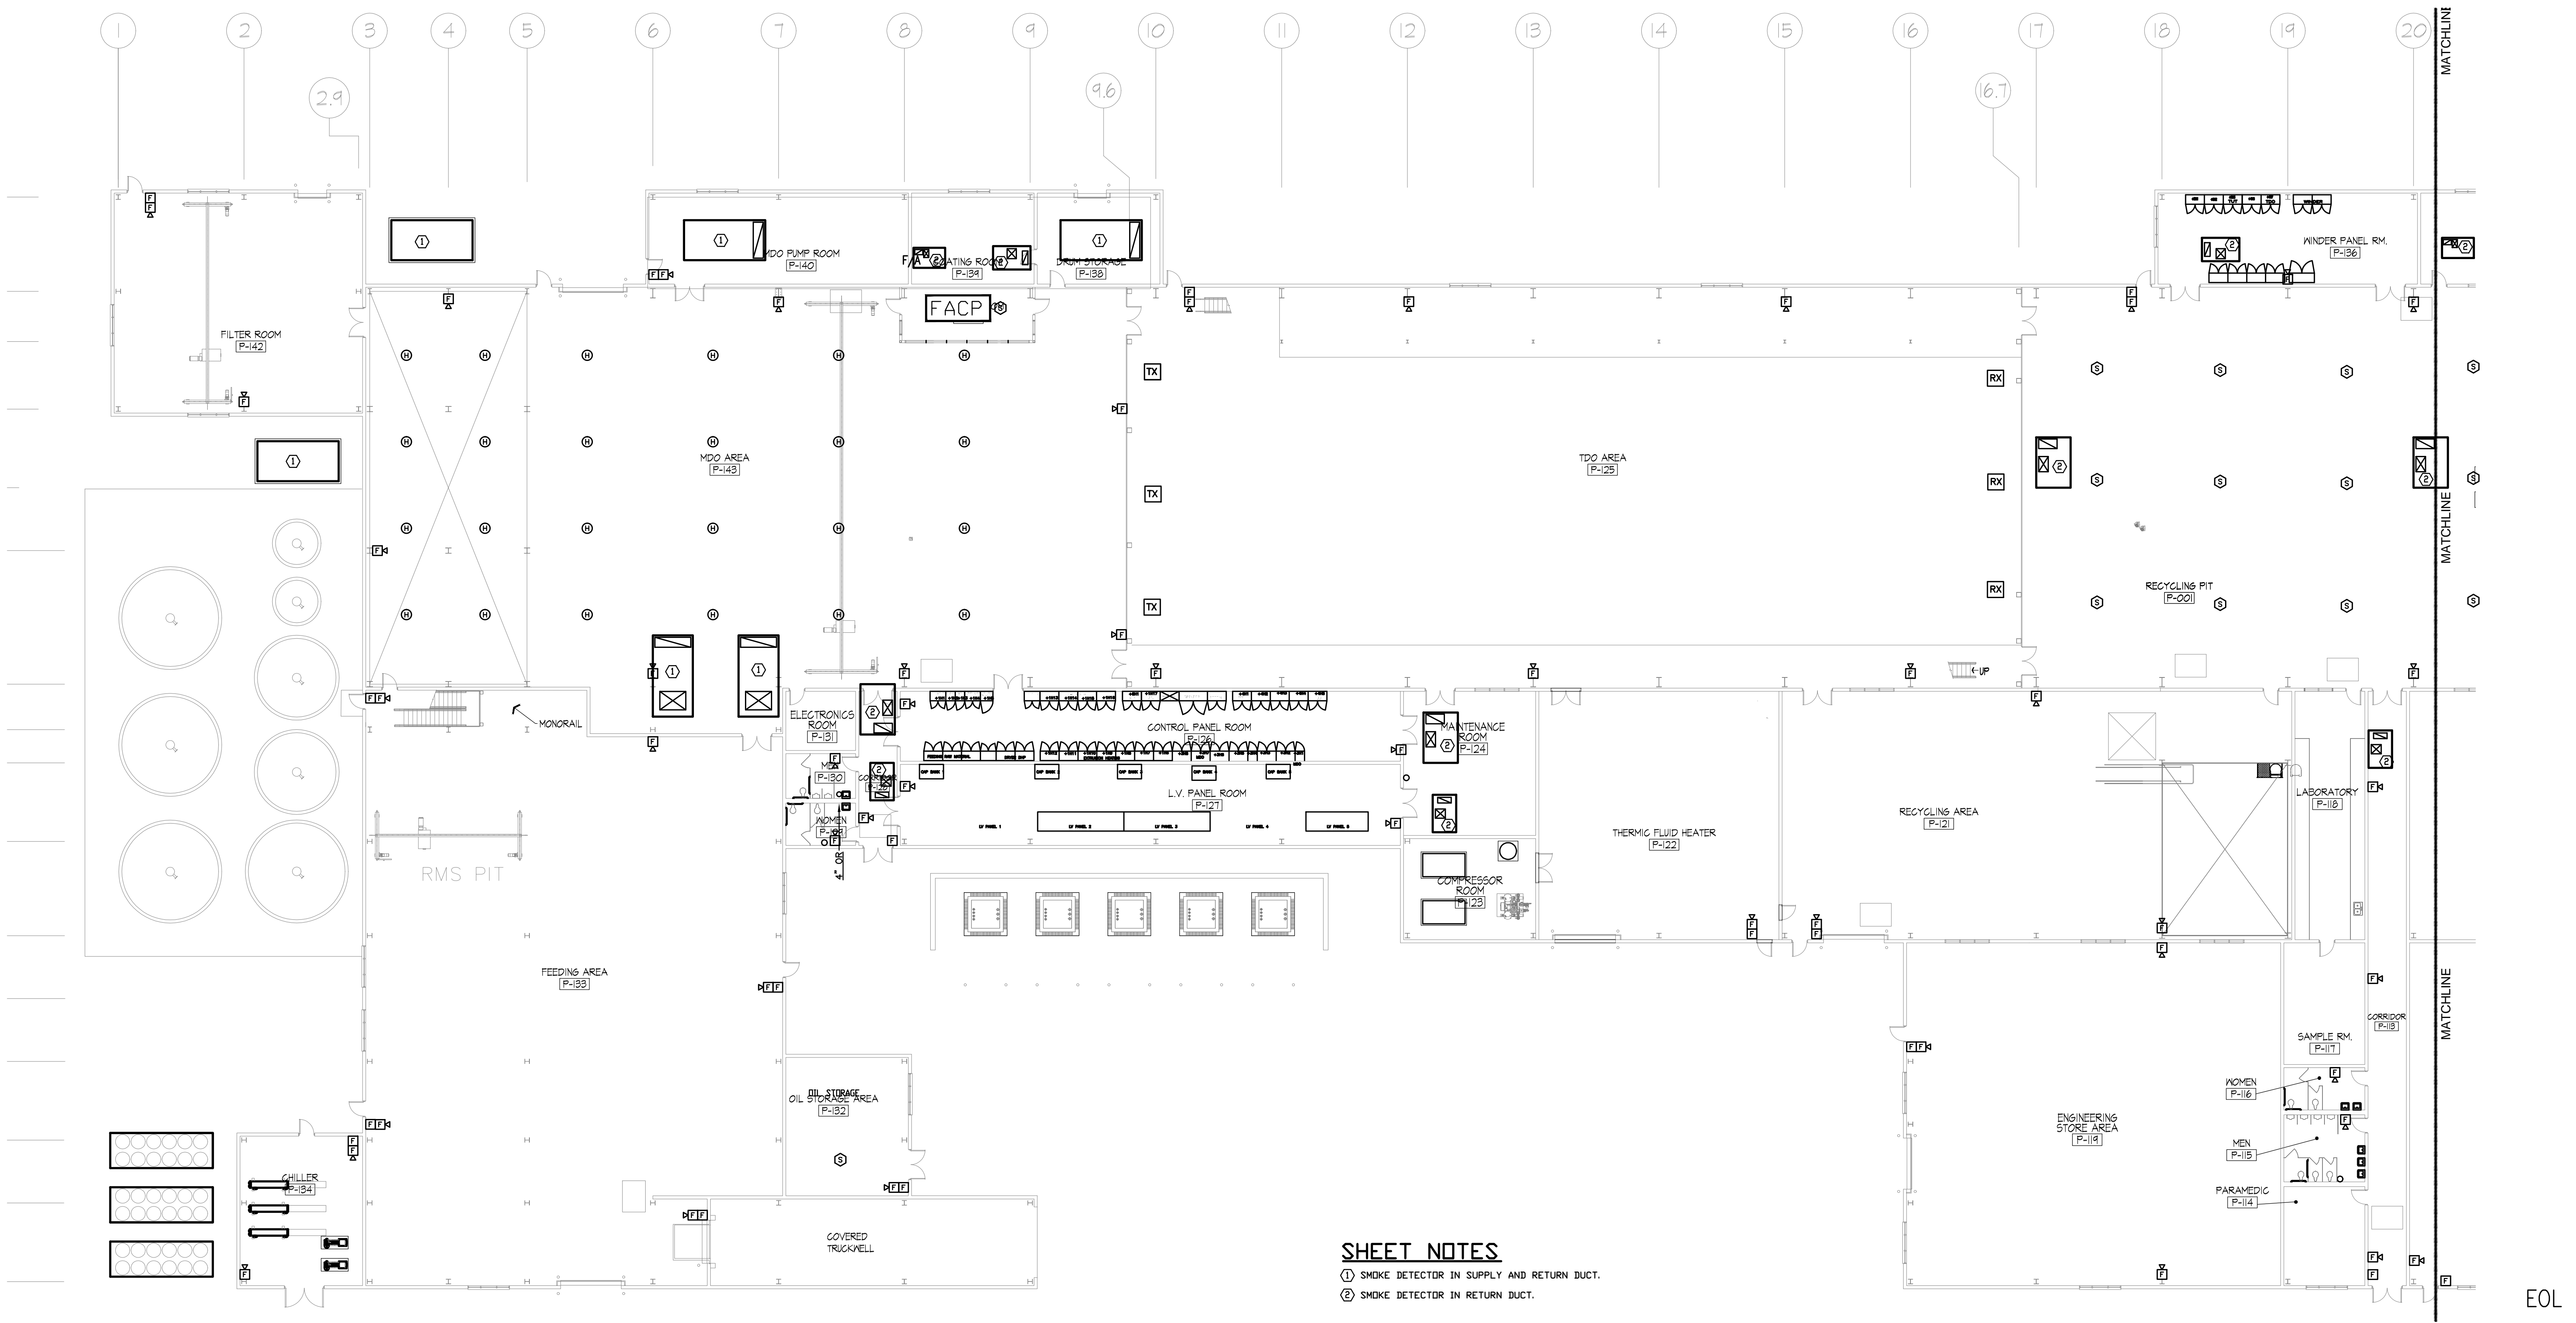

SHEET NOTES
 ① SMOKE DETECTOR IN SUPPLY AND RETURN DUCT.
 ② SMOKE DETECTOR IN RETURN DUCT.

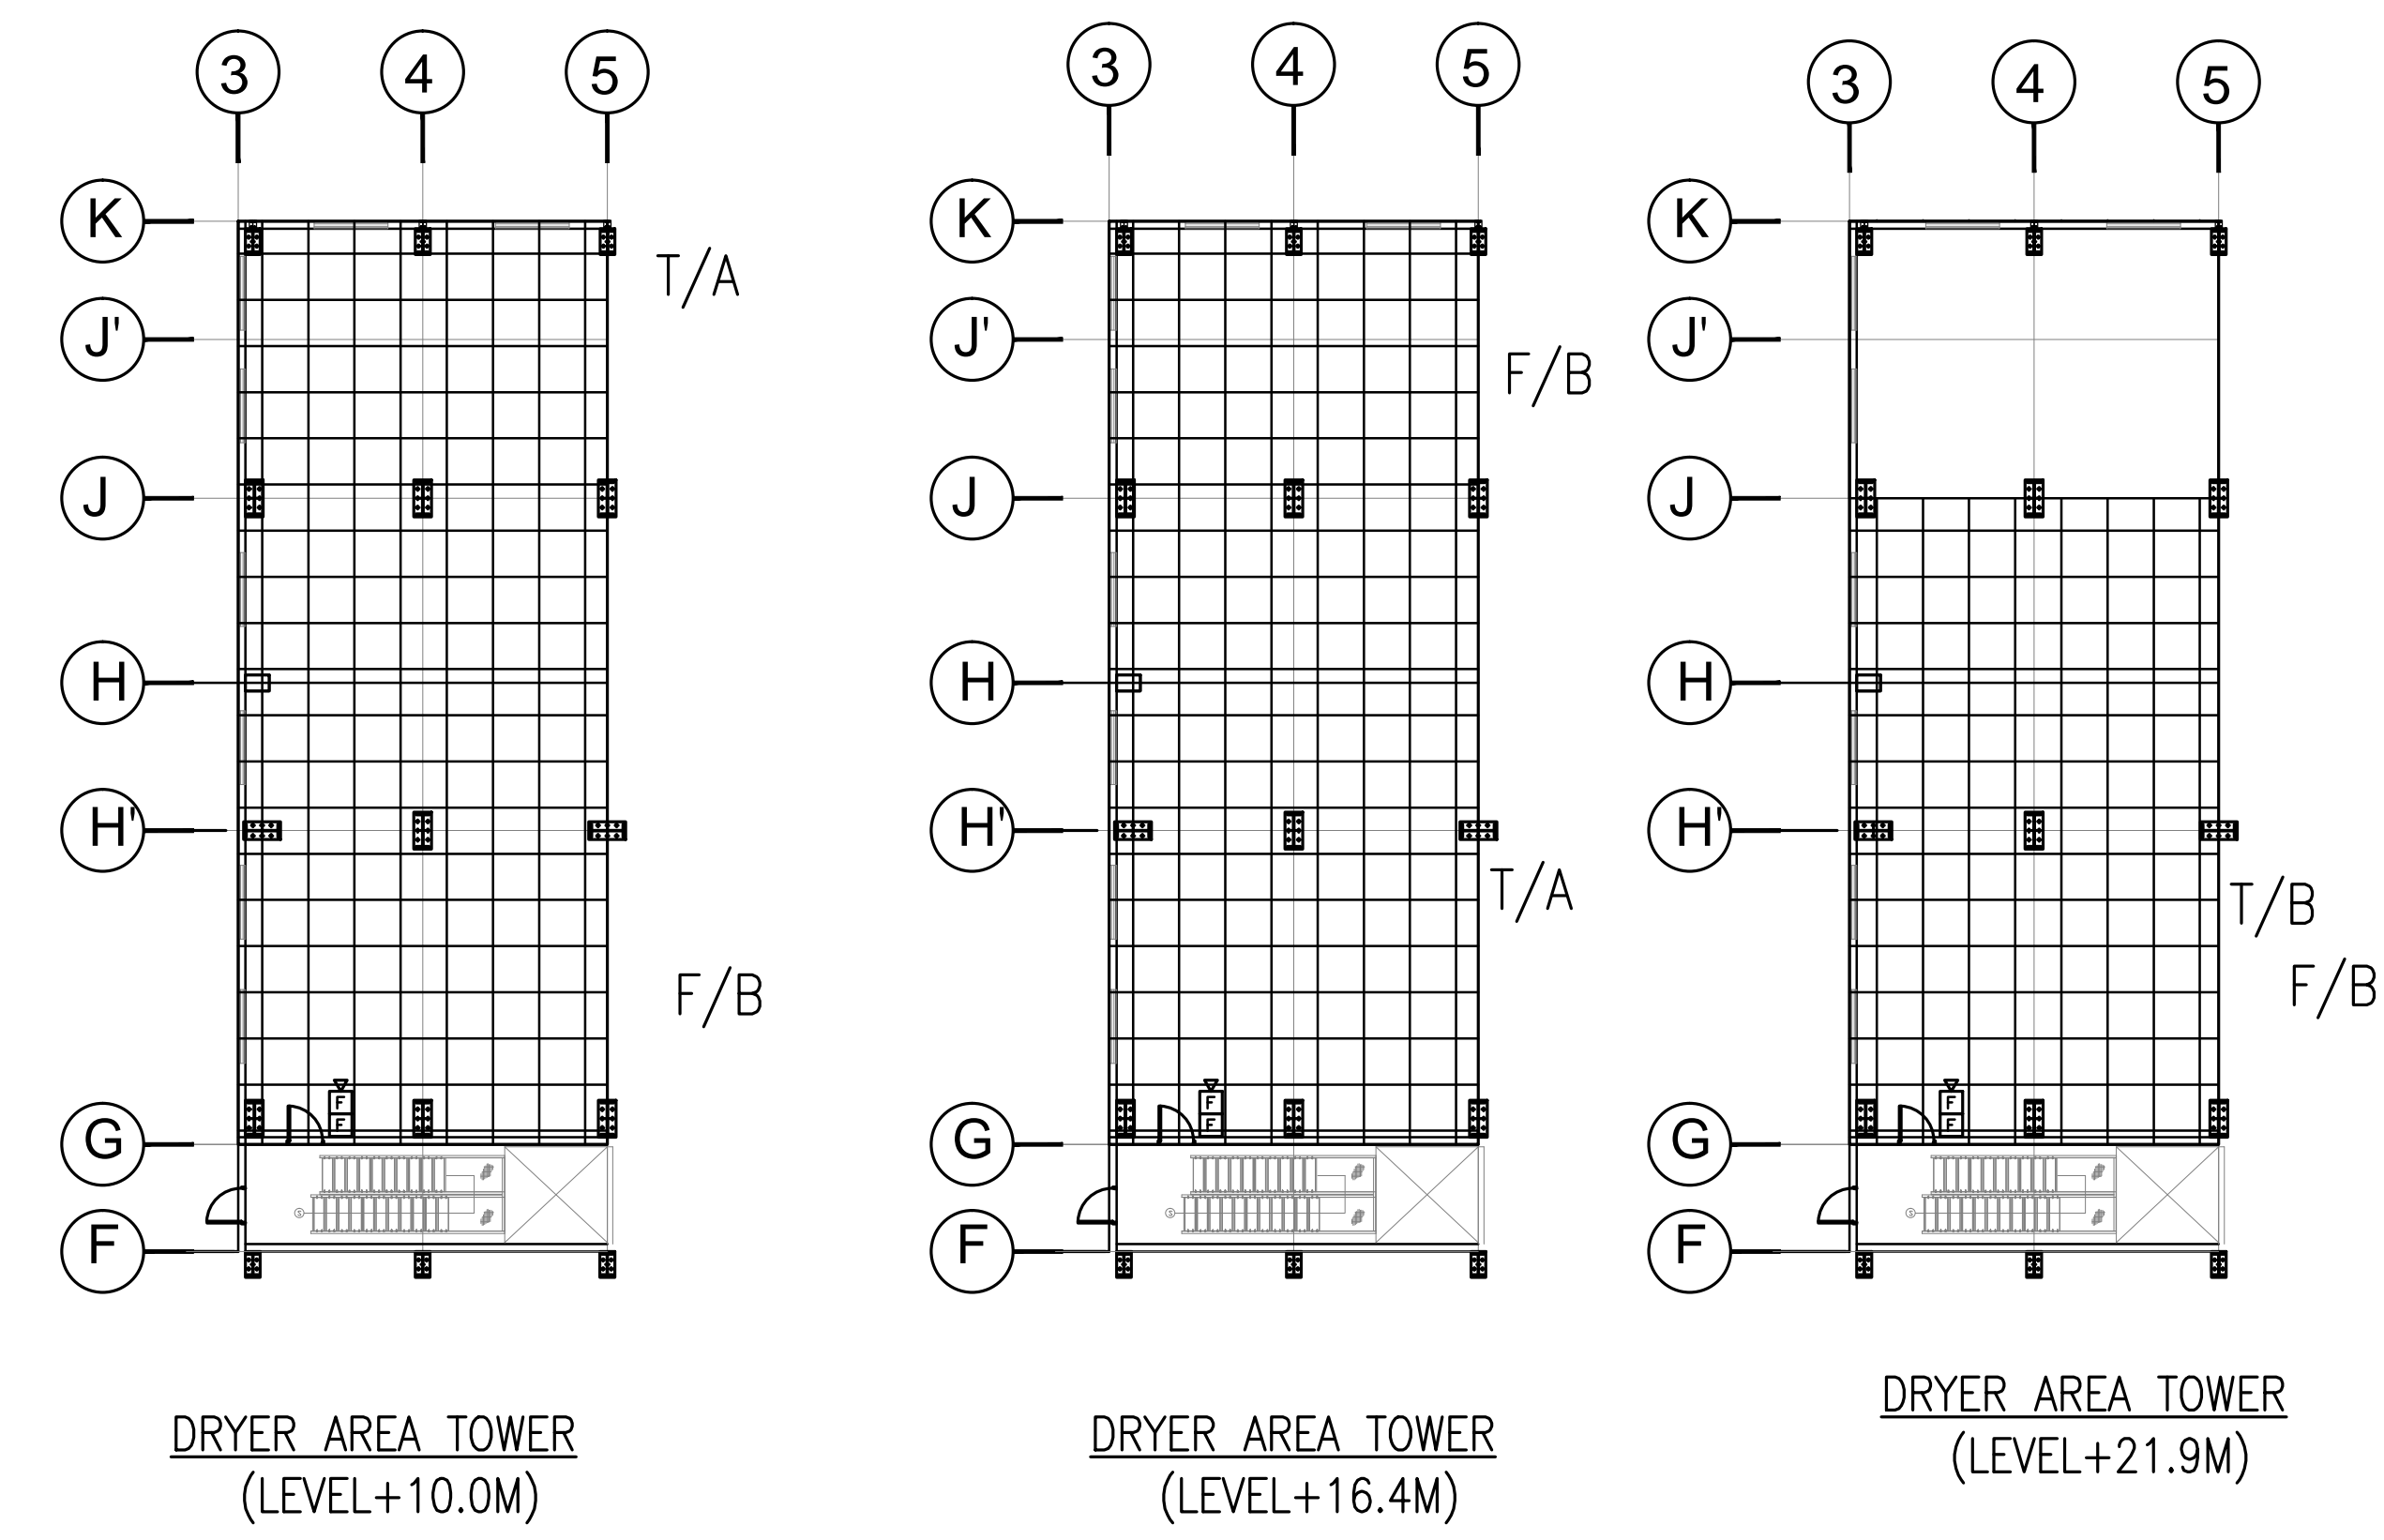

PARTIAL FIRE ALARM PLAN
 SCALE: 1/16" = 1'-0"

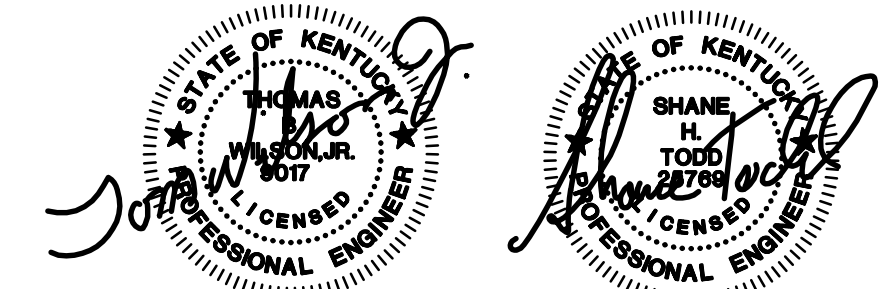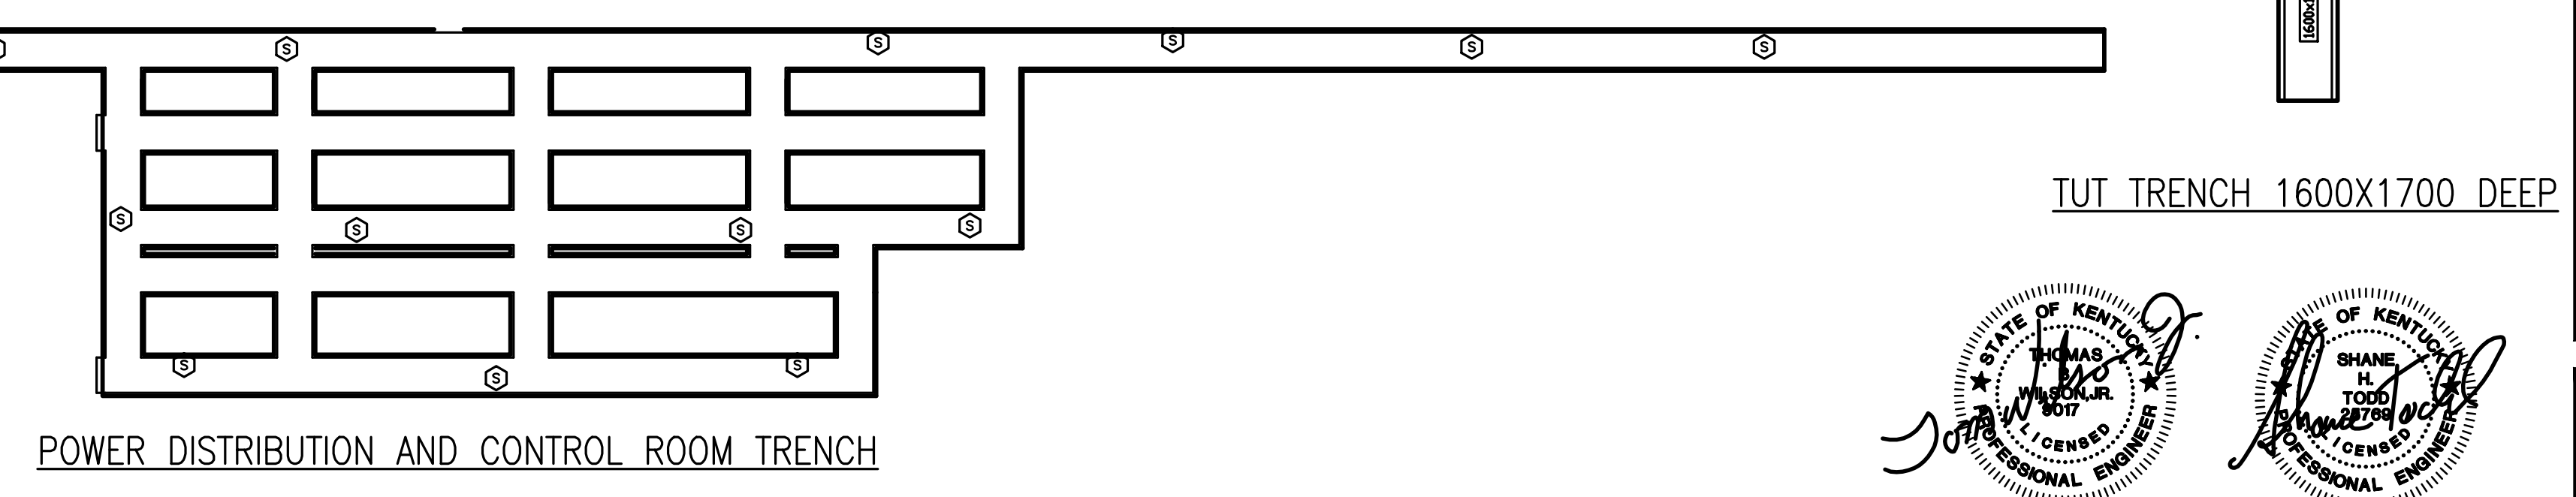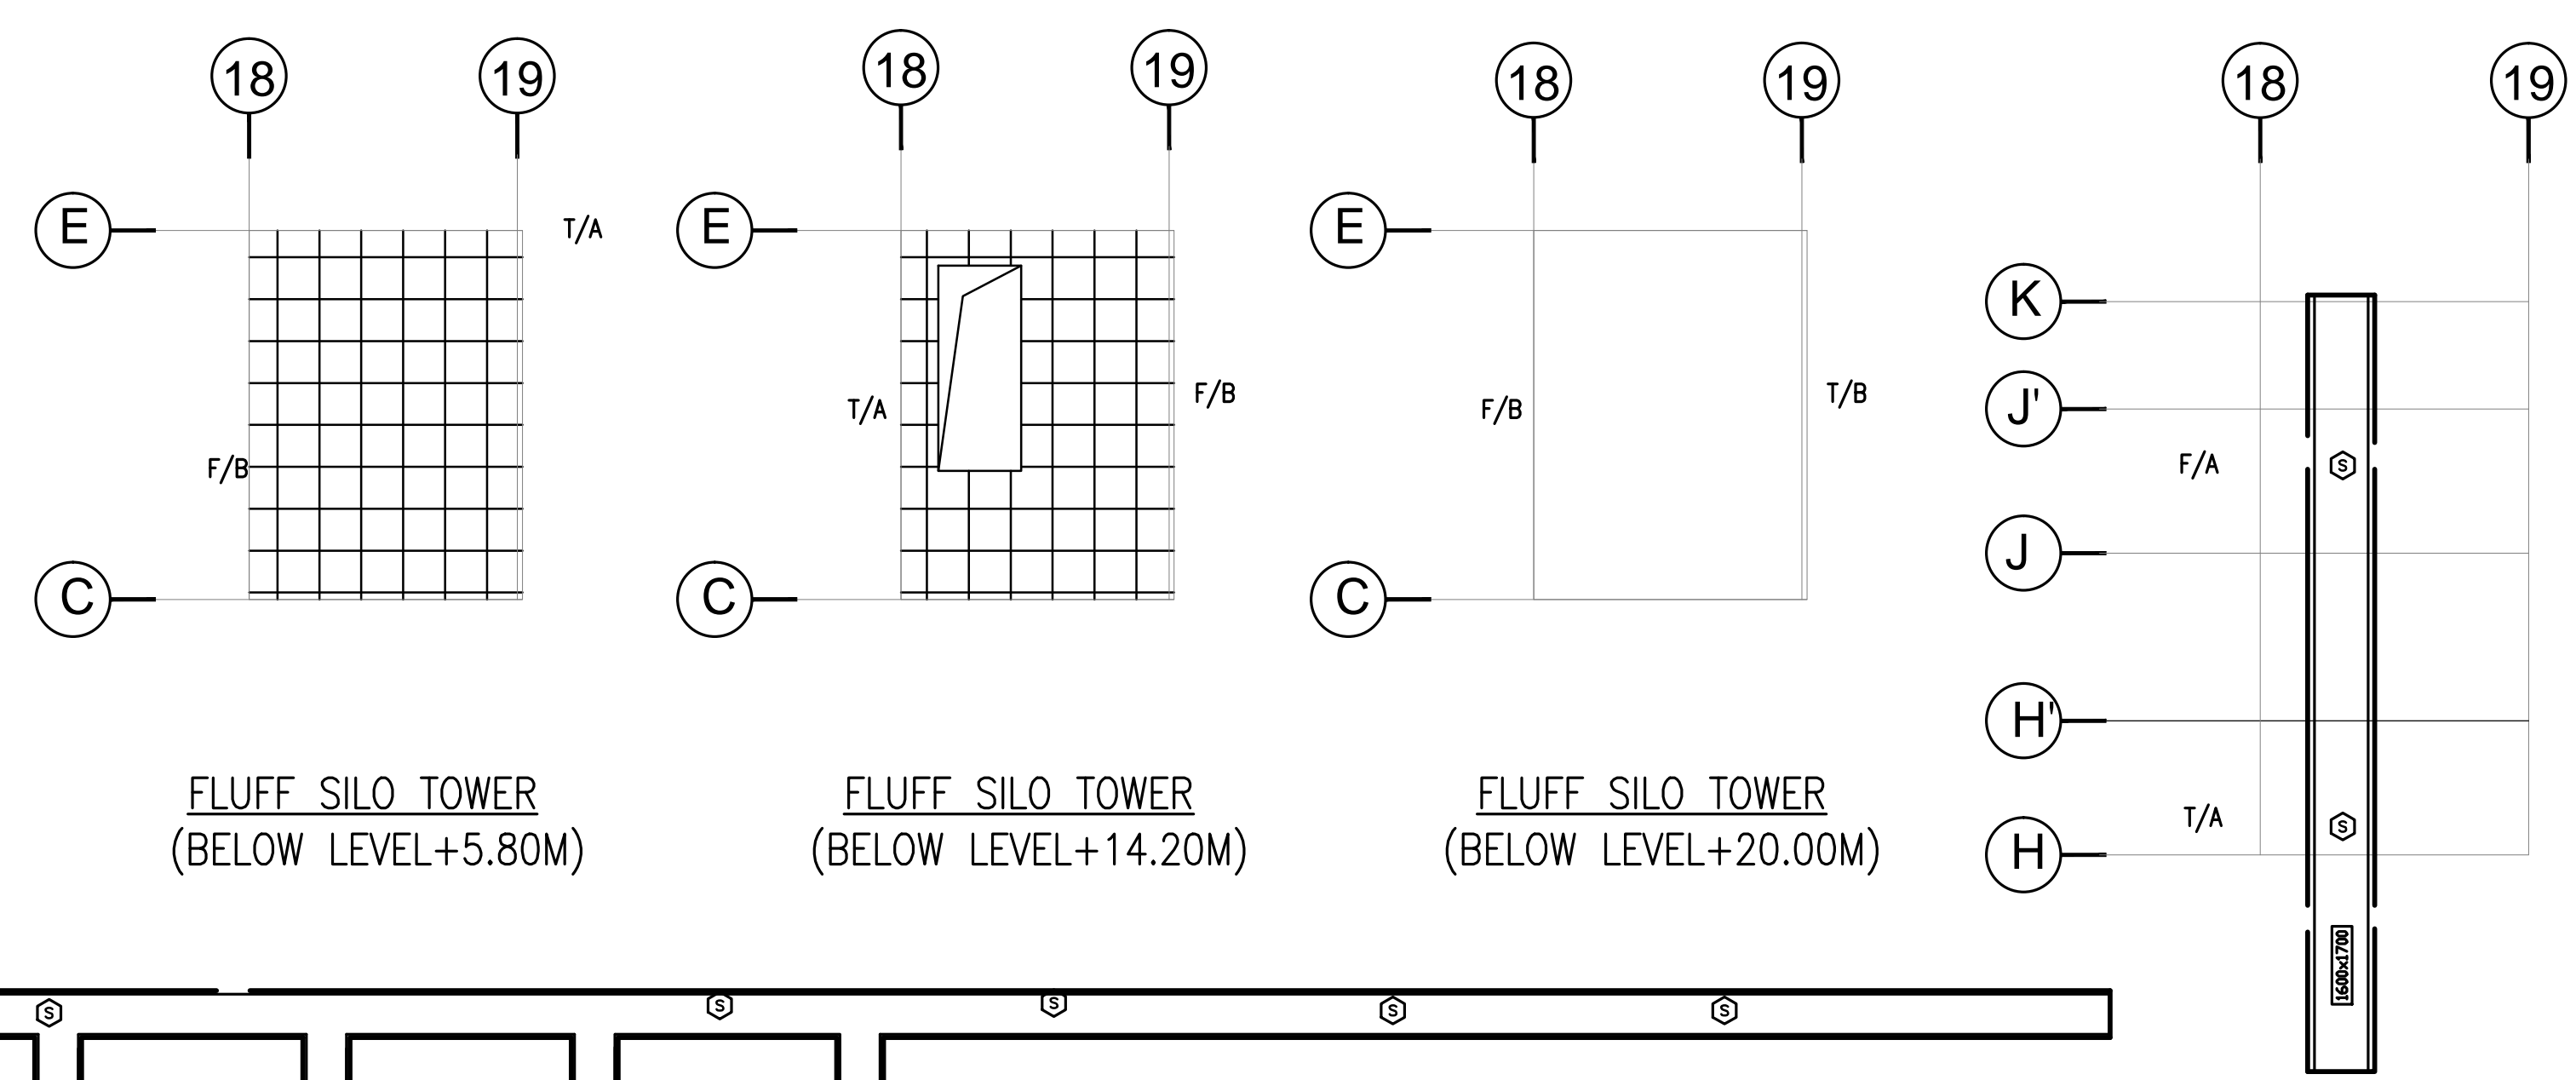

AMERICAN INSTITUTE OF ARCHITECTS

FLEXFILMS, U.S.A., LLC
 1221 NORTH BLACK BRANCH ROAD
 ELIZABETHTOWN, KENTUCKY 42702

PROJECT L-12 BOPET U.S.A.

DATE	REVISION
NOV. 11, 2011	VALUE ENGINEERING RE-DESIGN DOCUMENT
JAN. 28, 2012	REVISIONS ASSOCIATED WITH REVISED FLOOR PLAN

PROJECT NO.	DESIGNED BY	CHECKED BY	DATE
8529-02	TBW	TBW	JULY 2011

BY	DATE	SCALE
DESIGNED BY	JULY 2011	1/8" = 1'-0"
CHECKED BY	JULY 2011	1/8" = 1'-0"
DATE	JULY 2011	1/8" = 1'-0"

**Engineers
Architects
Planners**
OF KENTUCKY, INC.
 Phone: (859) 223-5884
 Fax: (859) 223-2807
 www.nseflex.com

**UFL-L12
FF-002A**