


DATE	REVISION	BY
NOV. 1, 11	VALUE ENGINEERING RE-DESIGN DOCUMENT	
JAN. 20, 12	REVISIONS ASSOCIATED WITH REISED FLOOR PLAN	



PROJECT NO.	DESIGNED BY	DRAWN BY	CHECKED BY	REVIEWED BY	DATE	SCALE
8529-02	TBW	RCD	JLM	JLM	JULY 2011	AS NOTED

Engineers
 Architects
 Planners
nse
 OF KENTUCKY, INC.

Phone: (859) 233-5884
 824 Wellington Way
 Lexington, KY 40503
 Fax: (859) 233-2607
 www.nseflex.com

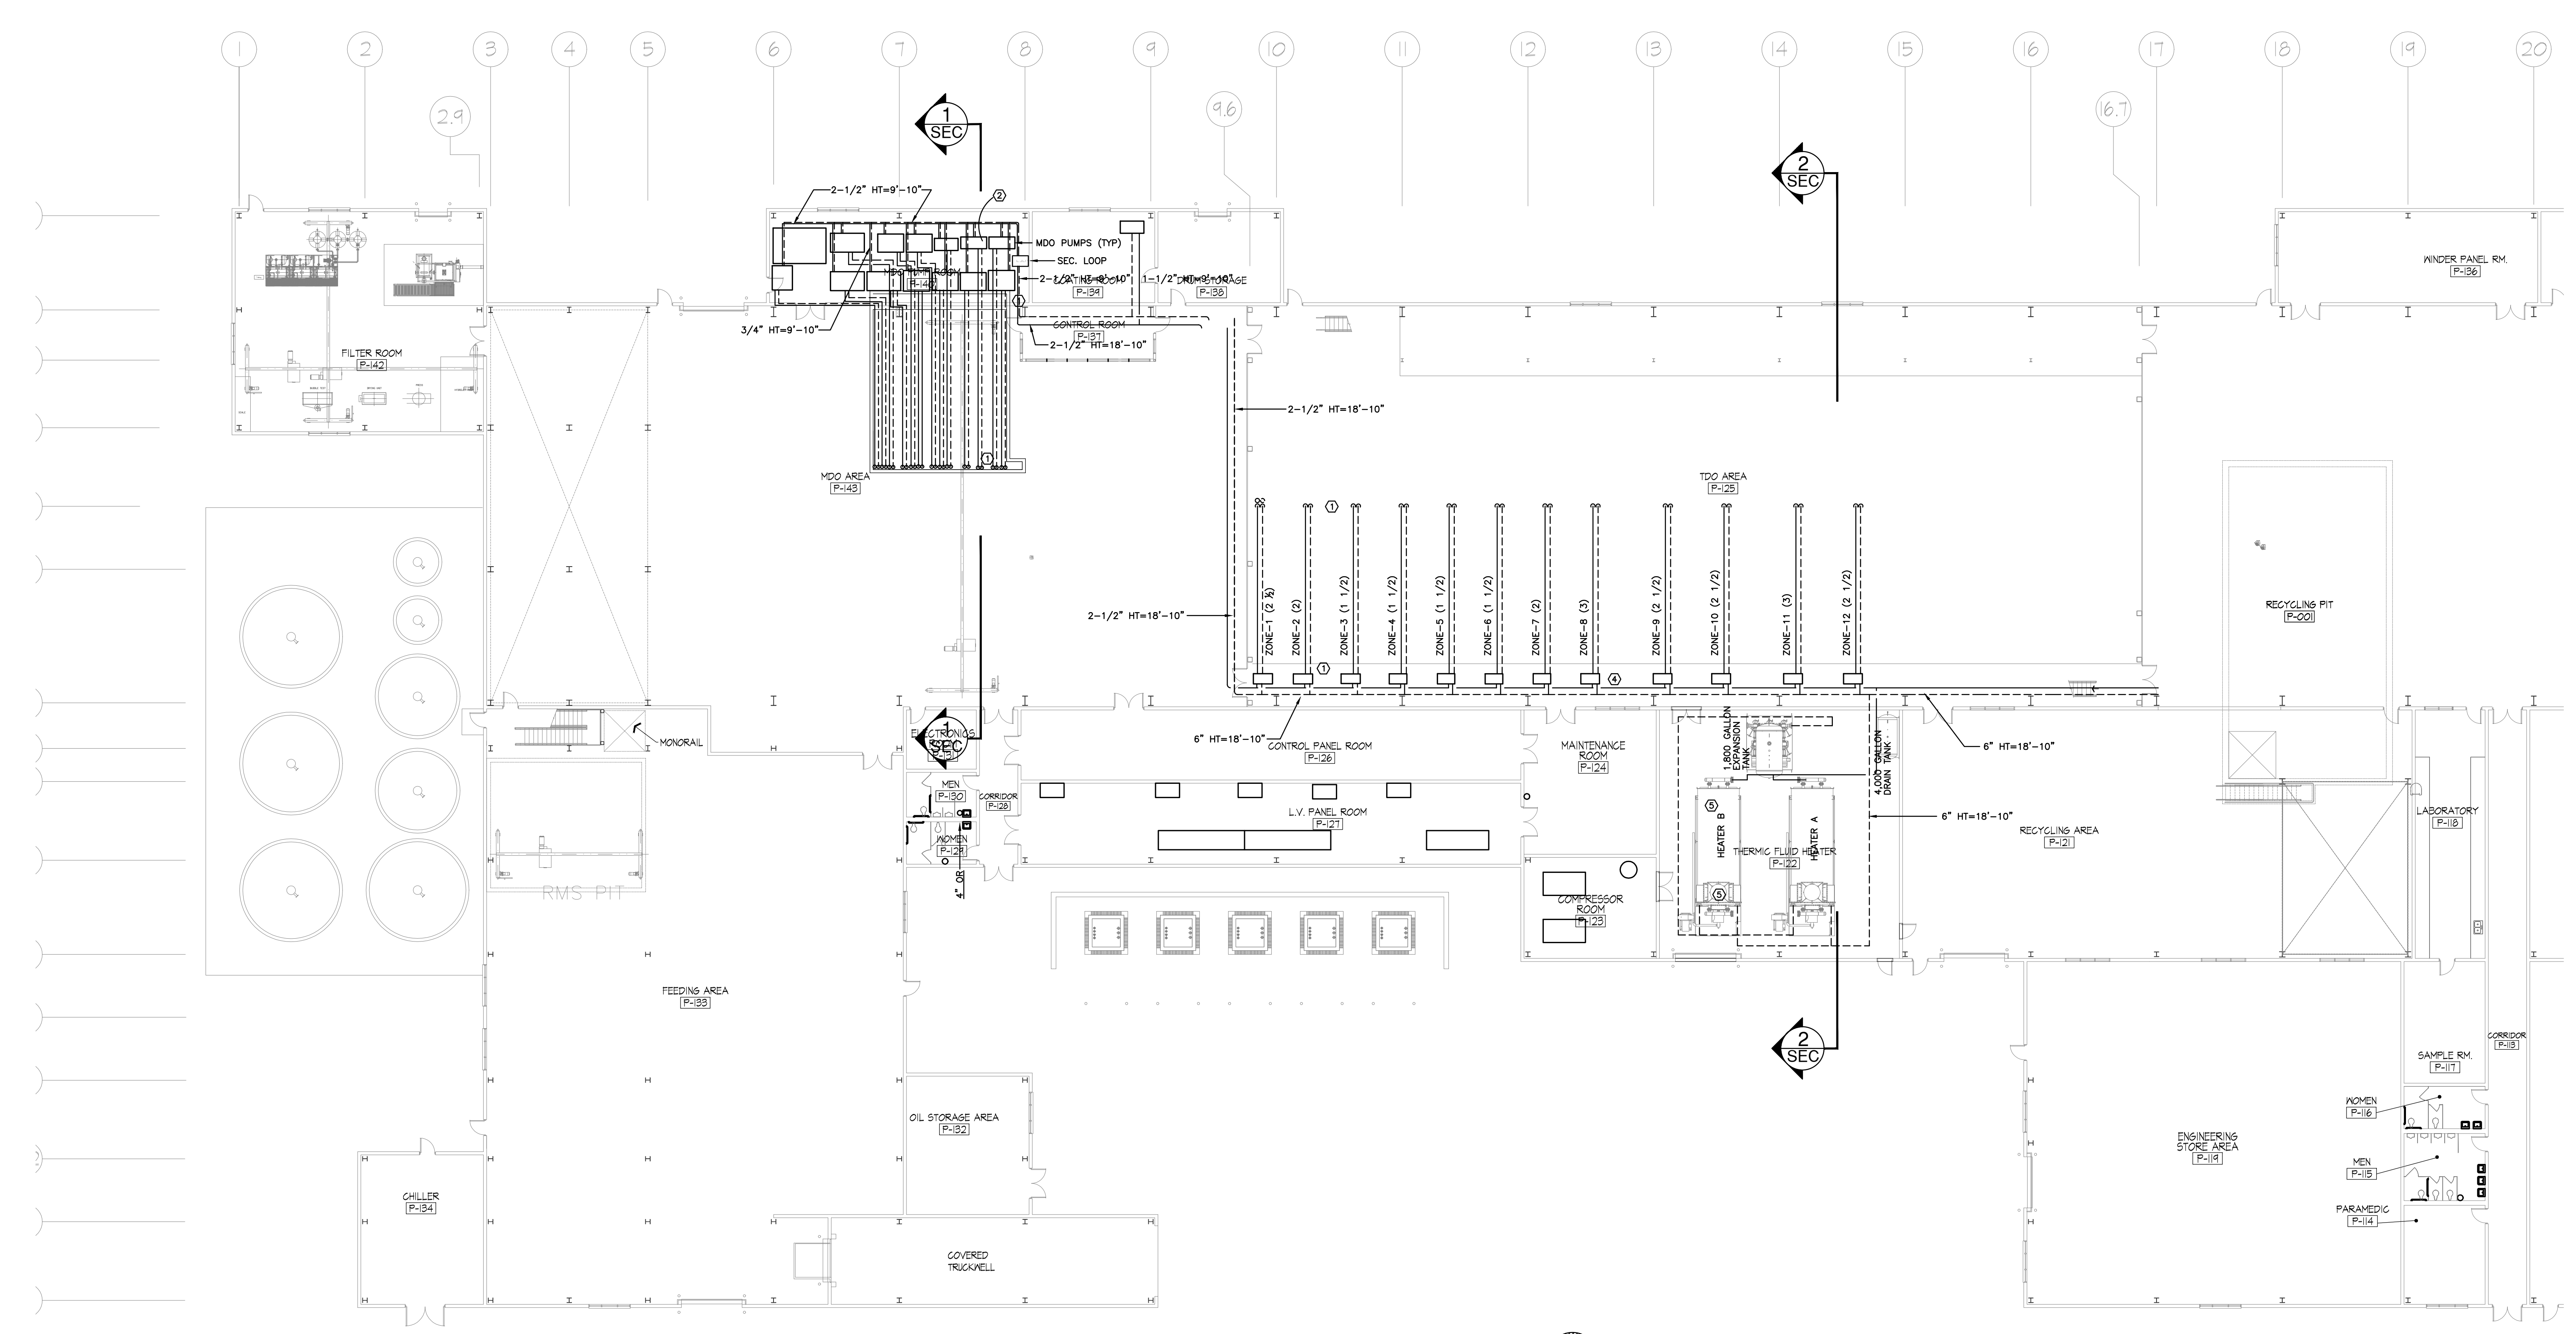

HOT OIL LAYOUT
 SCALE: 1/16" = 1'-0"

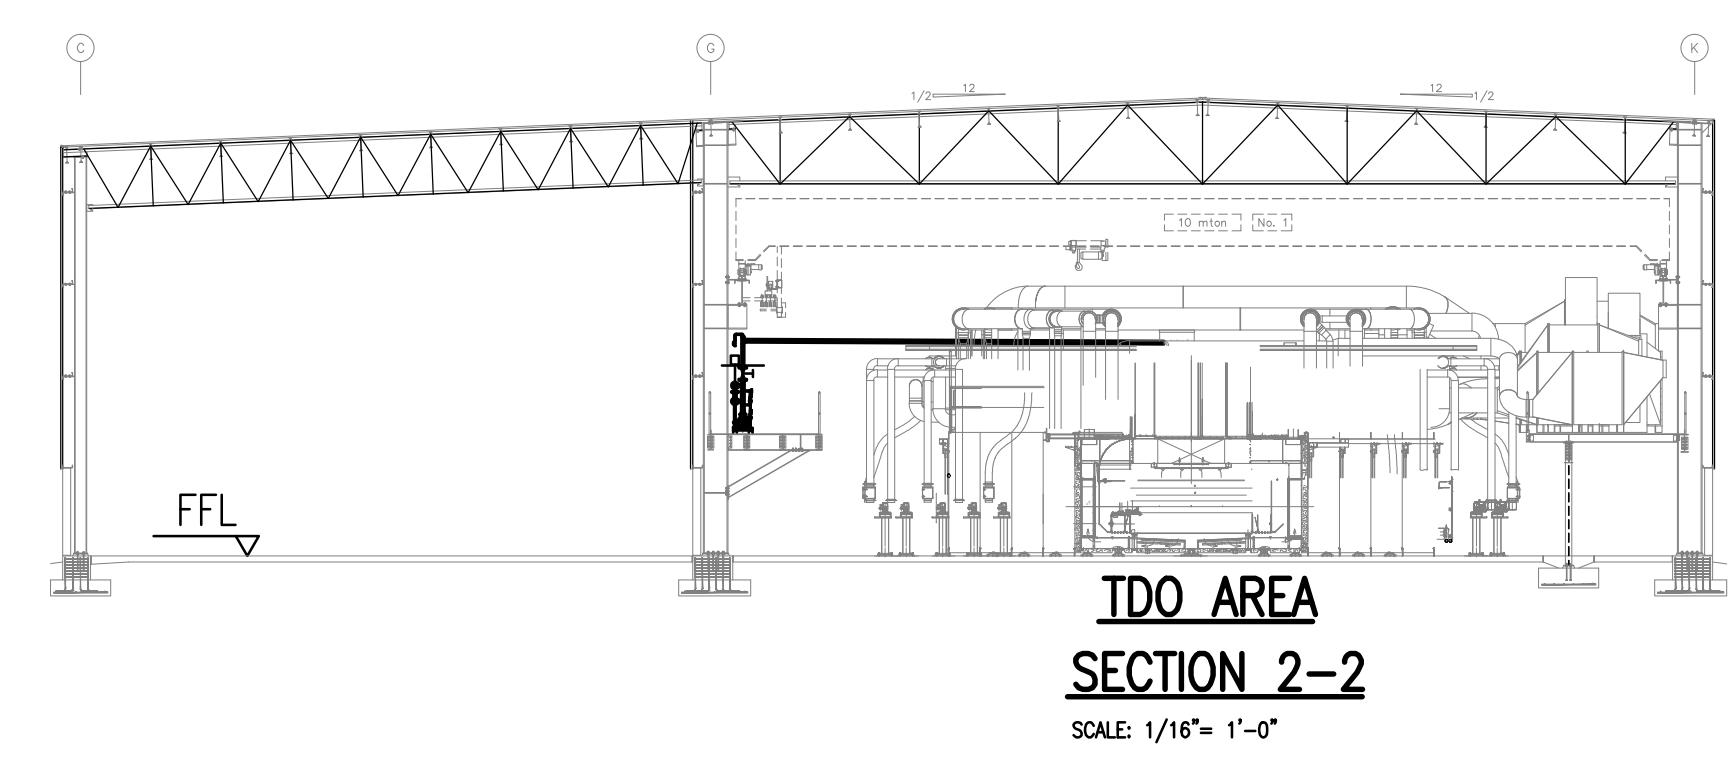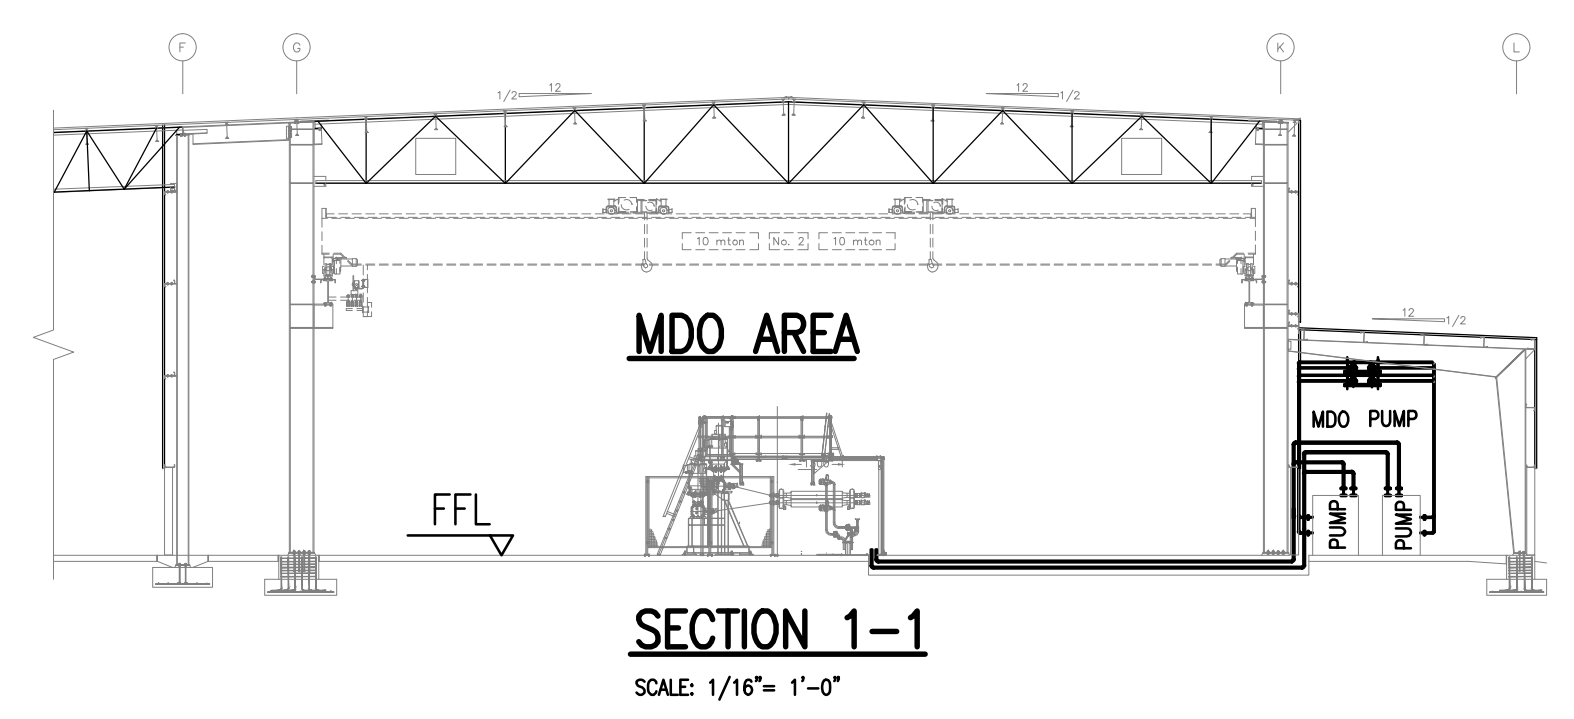

SHEET NOTES:

- ① BALL JOINTS, 2 PER PIPE, TYPICAL.
- ② BOX REPRESENTS MDO SEC. PUMP EQUIPMENT SUPPLIED BY CLIENT. TYPICAL.
- ③ FROM THE CHILLED WATER HEADER
- ④ BOX REPRESENTS IDO SEC. PUMP EQUIPMENT SUPPLIED BY CLIENT. TYPICAL.
- ⑤ HEATER A AND ECONOMIZER A WILL NOT BE INSTALLED AS PART OF THIS CONTRACT. CONTRACTOR SHALL INSTALL HOUSEKEEPING PAD AND SHALL INSTALL VALVES AND BLIND FLANGES AT EACH POINT REQUIRED FOR FUTURE INSTALLATION OF HEATER A AND ECONOMIZER A.

