

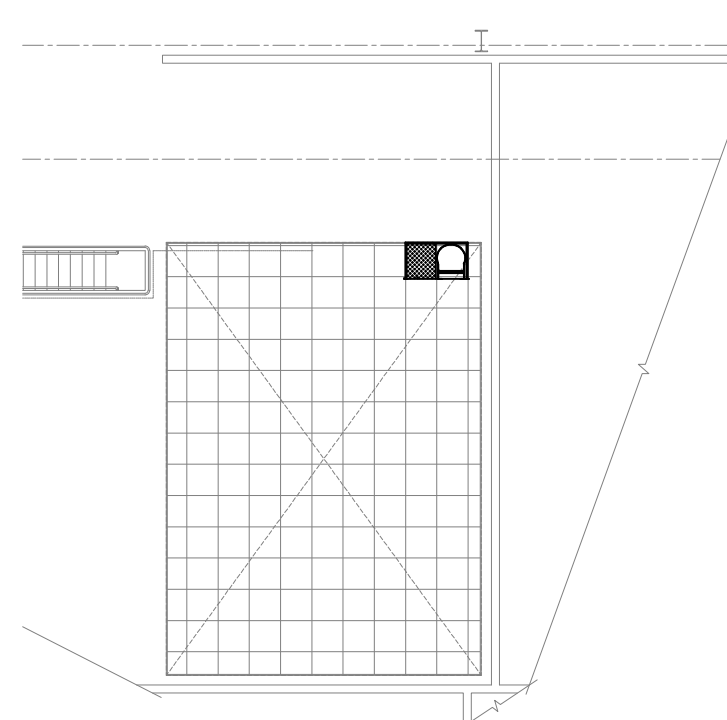


SHEET NOTES: ○

- 1\"/>

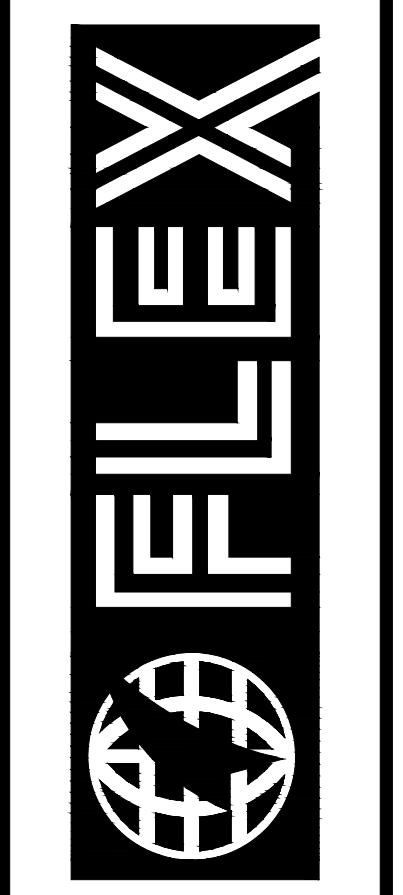

PLUMBING ROOF PLANS
SCALE: 1/16" = 1'-0"

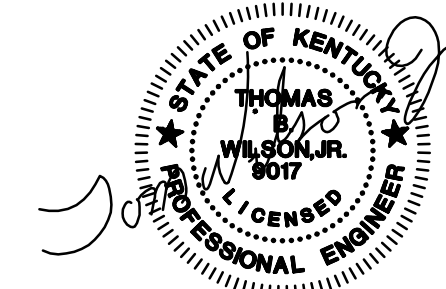

FLEXFILMS, U.S.A., LLC
1221 NORTH BLACK BRANCH ROAD
ELIZABETHTOWN, KENTUCKY 42702
PROJECT L-12 BOPET U.S.A.

DATE	REVISION	BY
NOV. 11, 2011	VALUE ENGINEERING RE-DESIGN DOCUMENT	
JAN. 20, 2012	REVISION ASSOCIATED WITH REISED FLOOR PLAN	

DESIGN DOCUMENTS: Weiskauer and all responsibility and liability for problems which arise from failure to follow these plans, specifications and the design thereof shall remain with the client.

This document contains subject matter considered confidential by FLEXFILMS, U.S.A., LLC and on which FLEXFILMS, U.S.A., LLC has a proprietary interest. It is to be used only for the project and for the exclusive use of the client. No part of this document is to be reproduced, stored in a retrieval system, or transmitted in any form or by any means, electronic, mechanical, photocopying, recording, or by any information storage and retrieval system, without the prior written permission of FLEXFILMS, U.S.A., LLC.

PROJECT NO.	8529-02
DESIGNED BY	TBW
DRAWN BY	RCD
CHECKED BY	TBW
REVIEWED BY	JLM
DATE	JULY 2011
SCALE	AS NOTED

nse
OF KENTUCKY, INC.
Engineers
Architects
Planners
624 Wellington Way
Lexington, KY 40503
Phone: (859)223-5884
Fax: (859)223-2607
www.nseflex.com

DRAWING NO.
UFL-L12
P-002