




**ENLARGED RESTROOM  
P-129 & P-130 PLAN**  
SCALE: 1/4" = 1'-0"

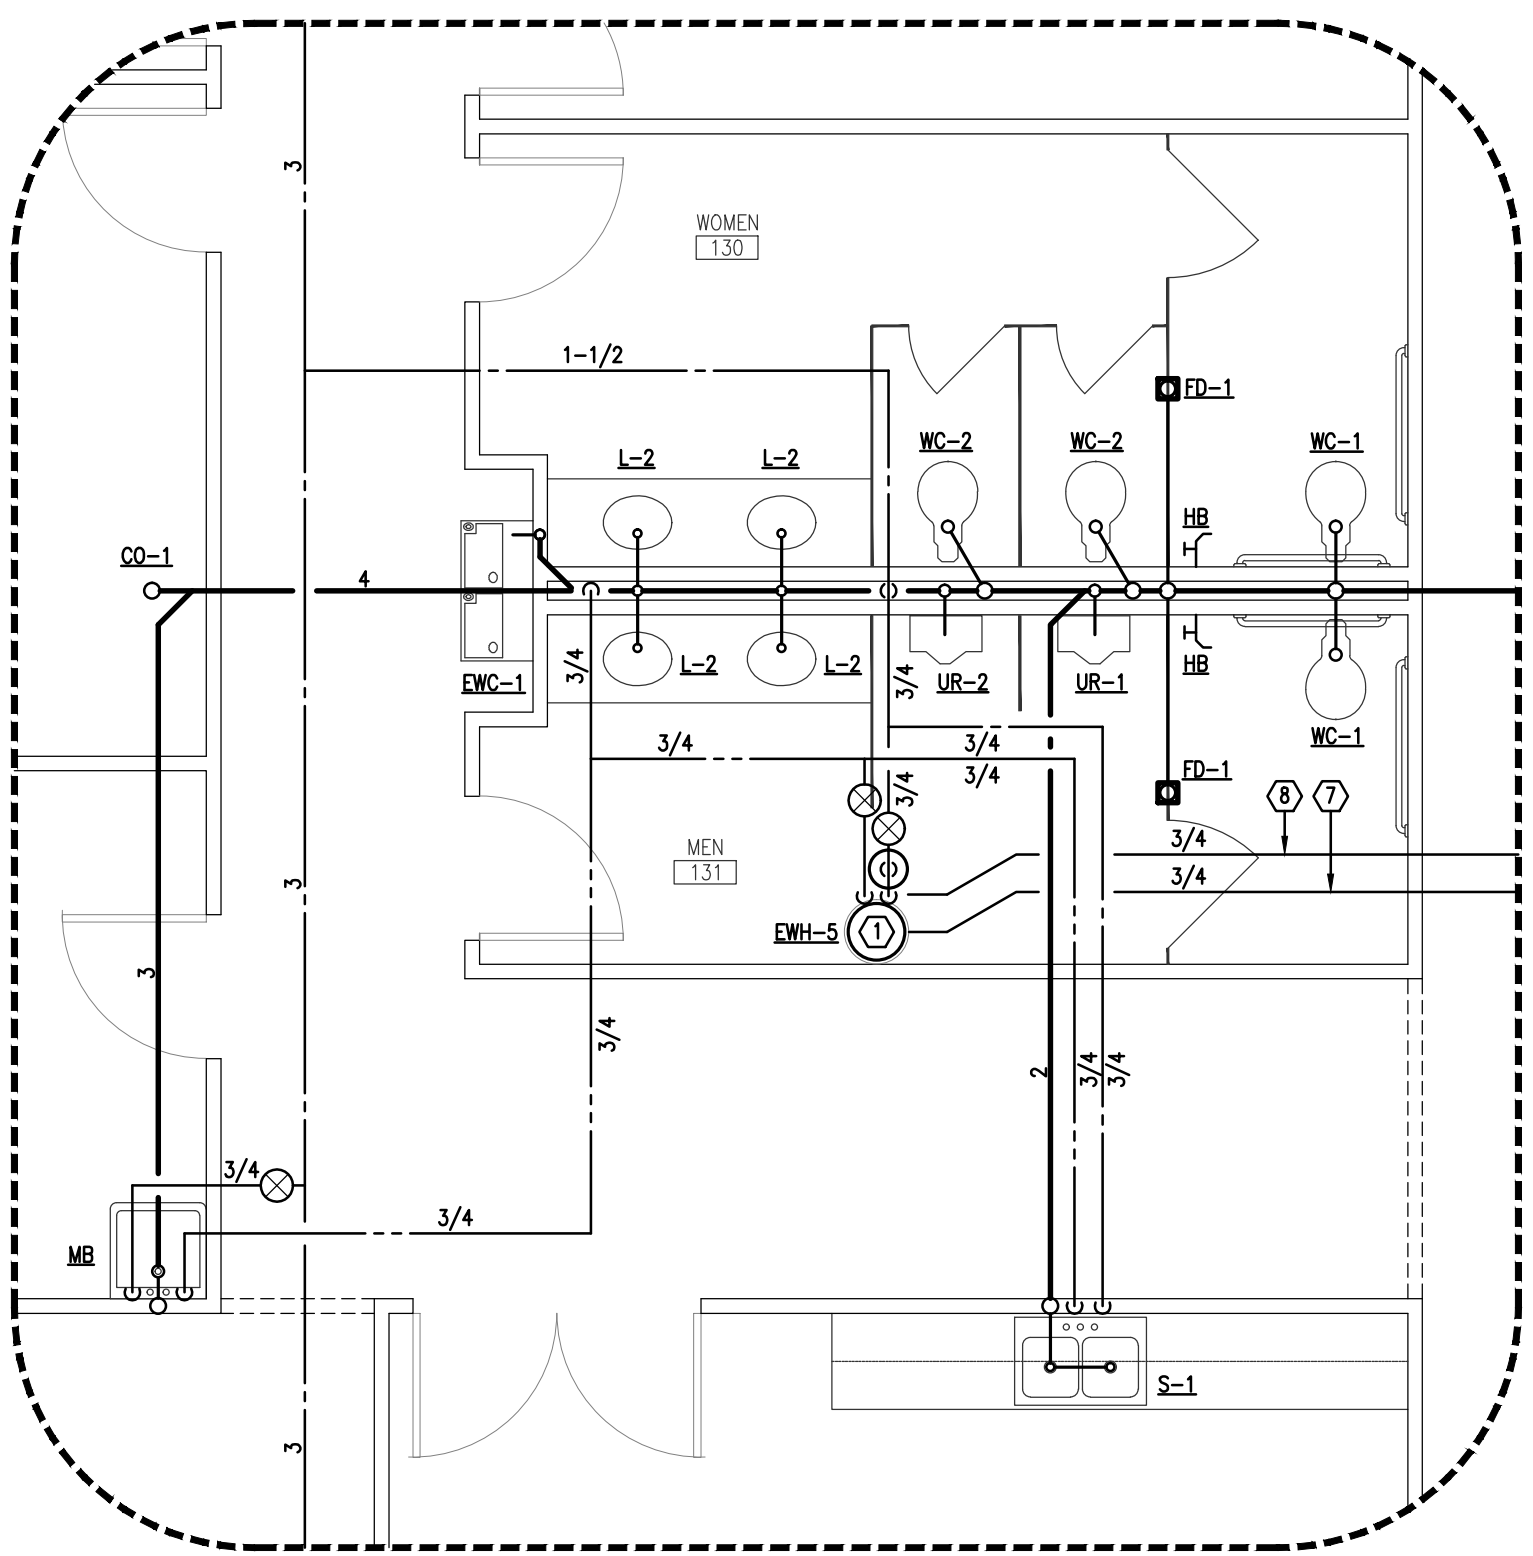


**ENLARGED RESTROOM  
130 & 131 PLAN**  
SCALE: 1/4" = 1'-0"

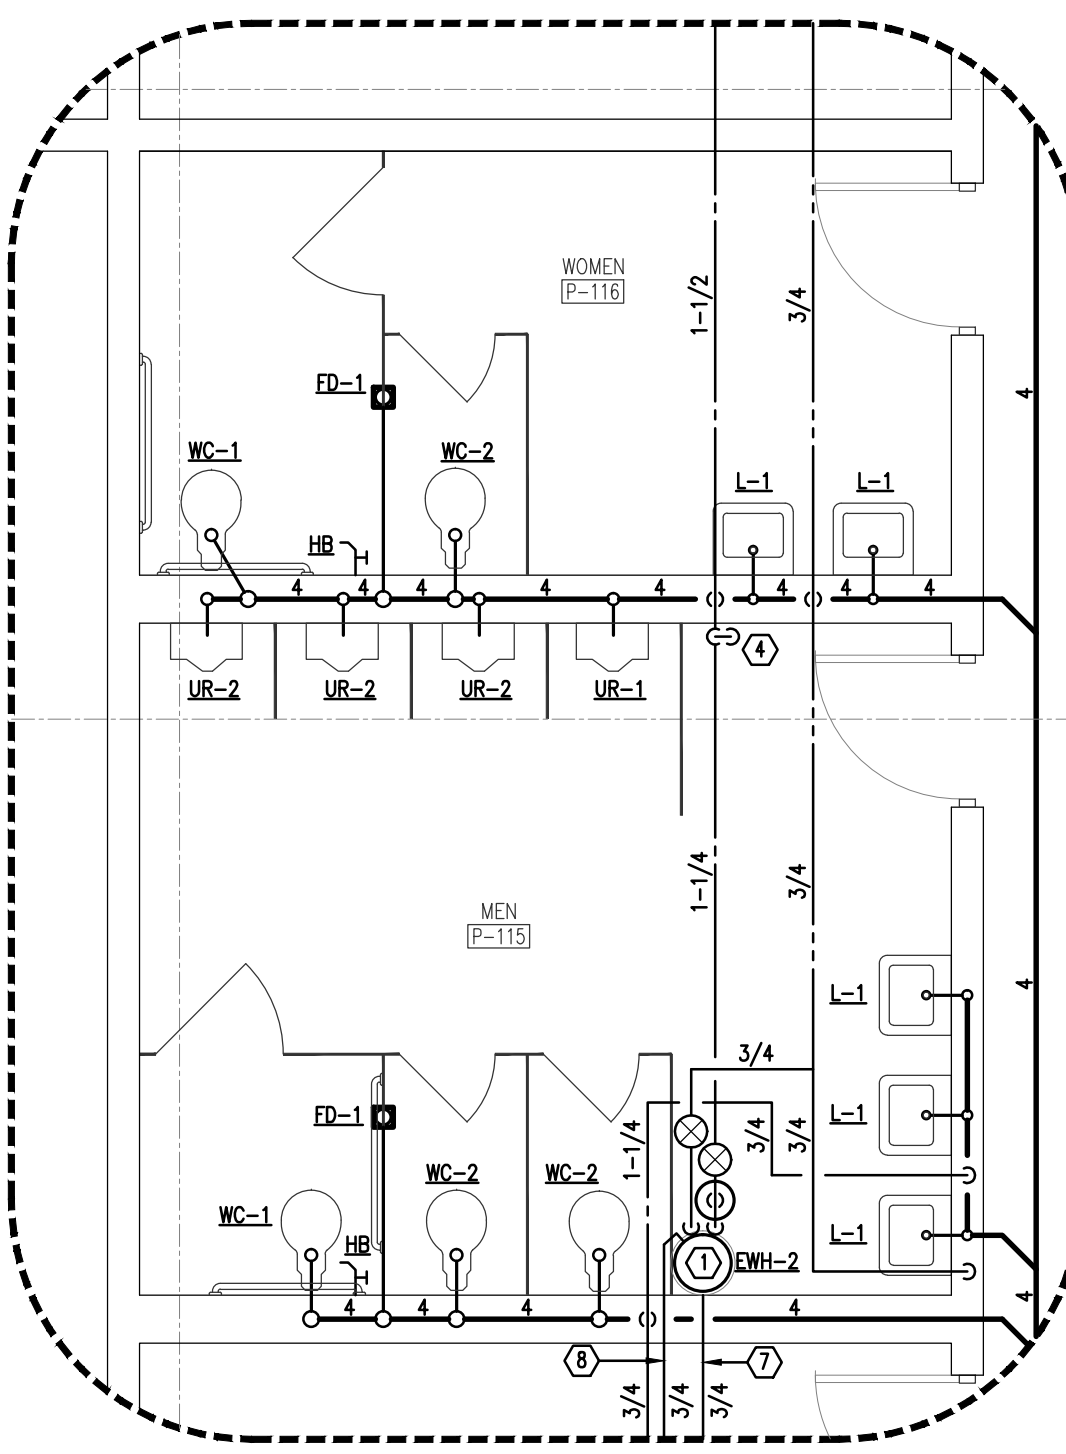


**ENLARGED RESTROOM  
P-115 & P-116 PLAN**  
SCALE: 1/4" = 1'-0"

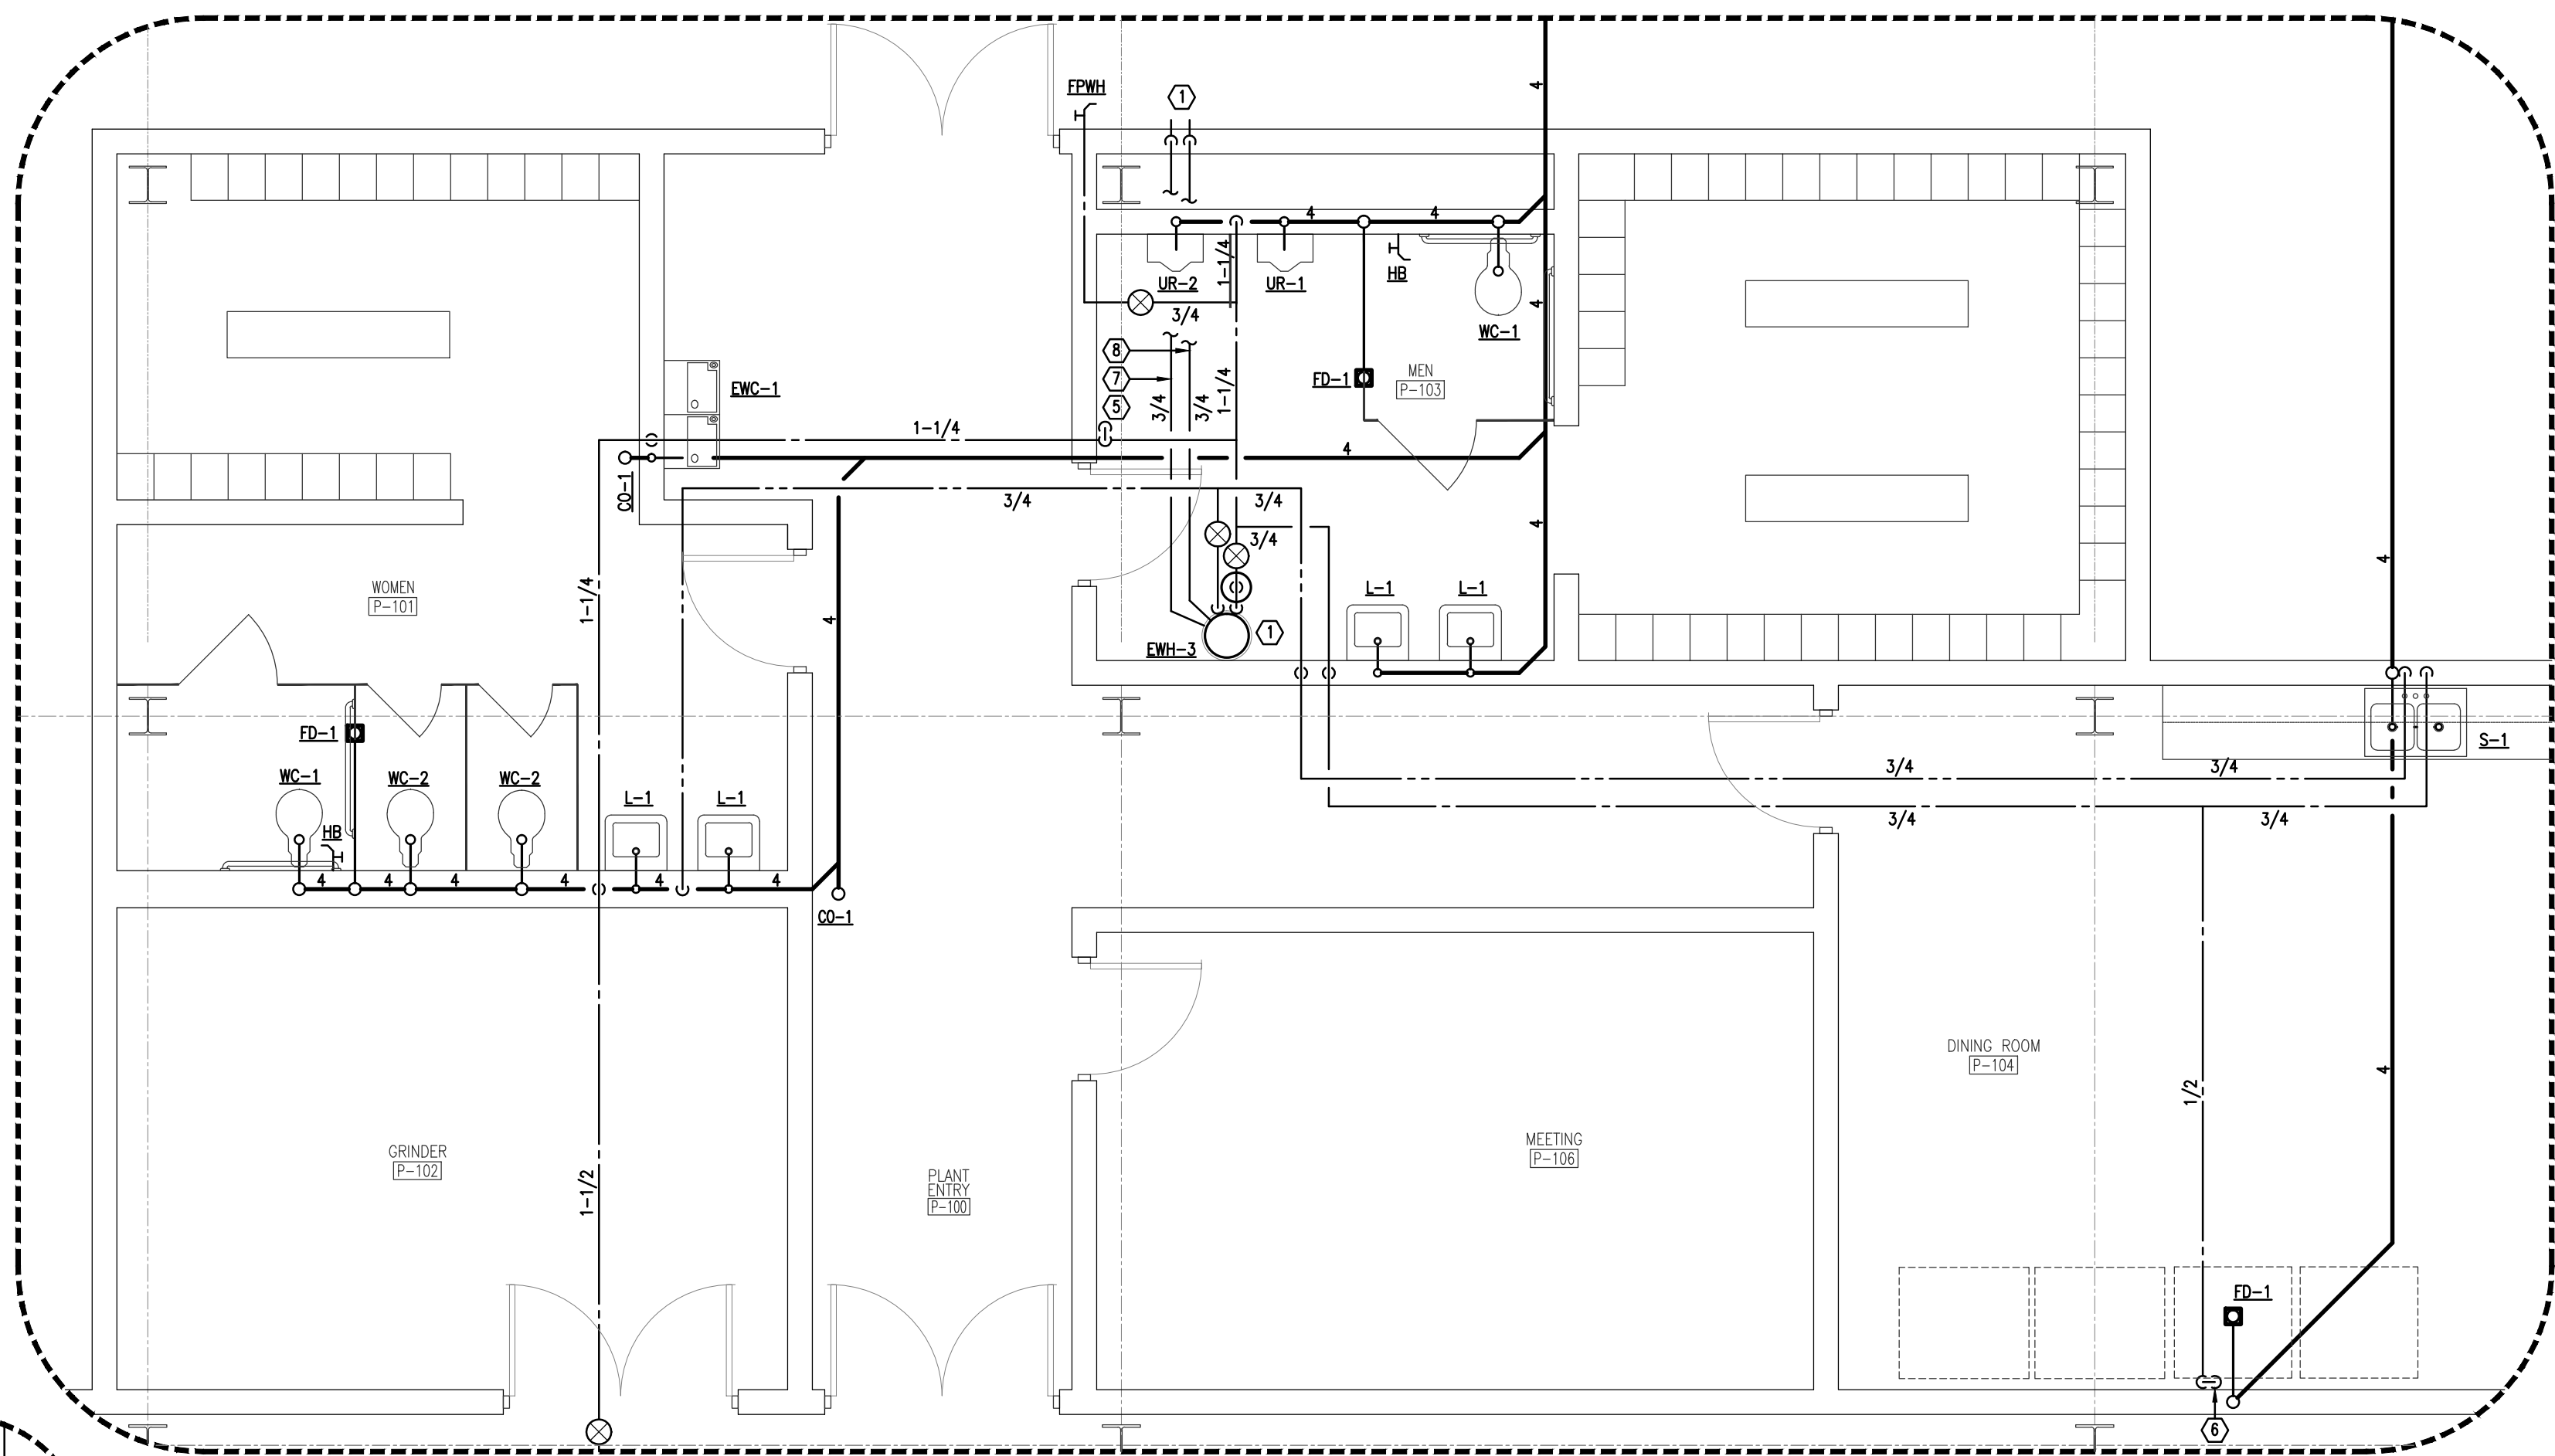


**ENLARGED RESTROOM P-101 & P-103, & DINING ROOM P-104 PLAN**  
SCALE: 1/4" = 1'-0"

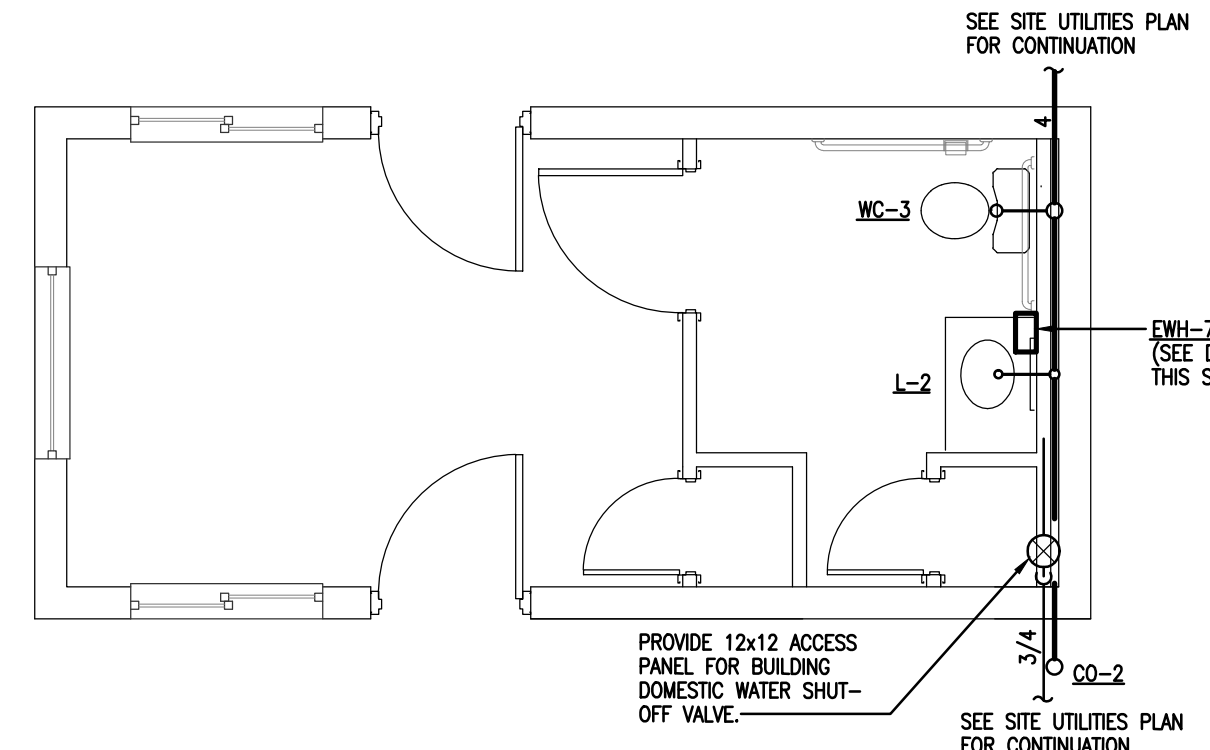


**GUARD SHACK PLUMBING FLOOR PLAN**  
SCALE: 1/4" = 1'-0"

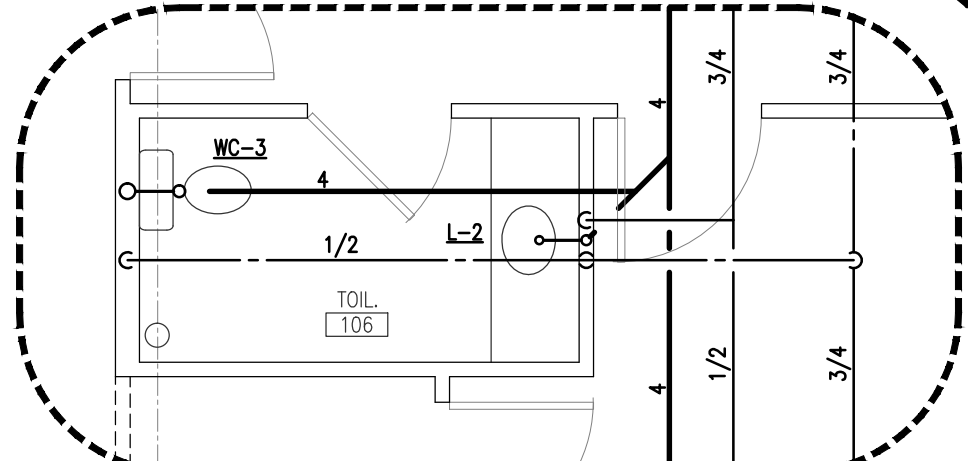

**ENLARGED TOILET 106 PLAN**  
SCALE: 1/4" = 1'-0"

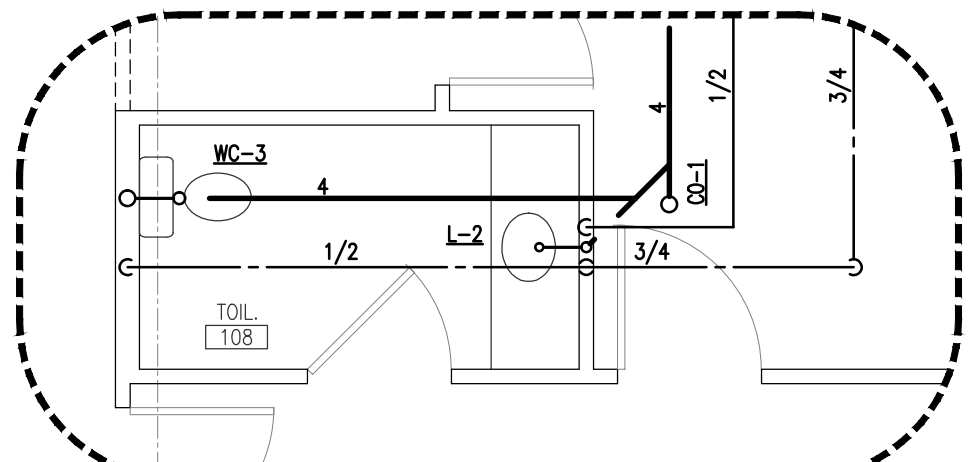


**ENLARGED TOILET 108 PLAN**  
SCALE: 1/4" = 1'-0"

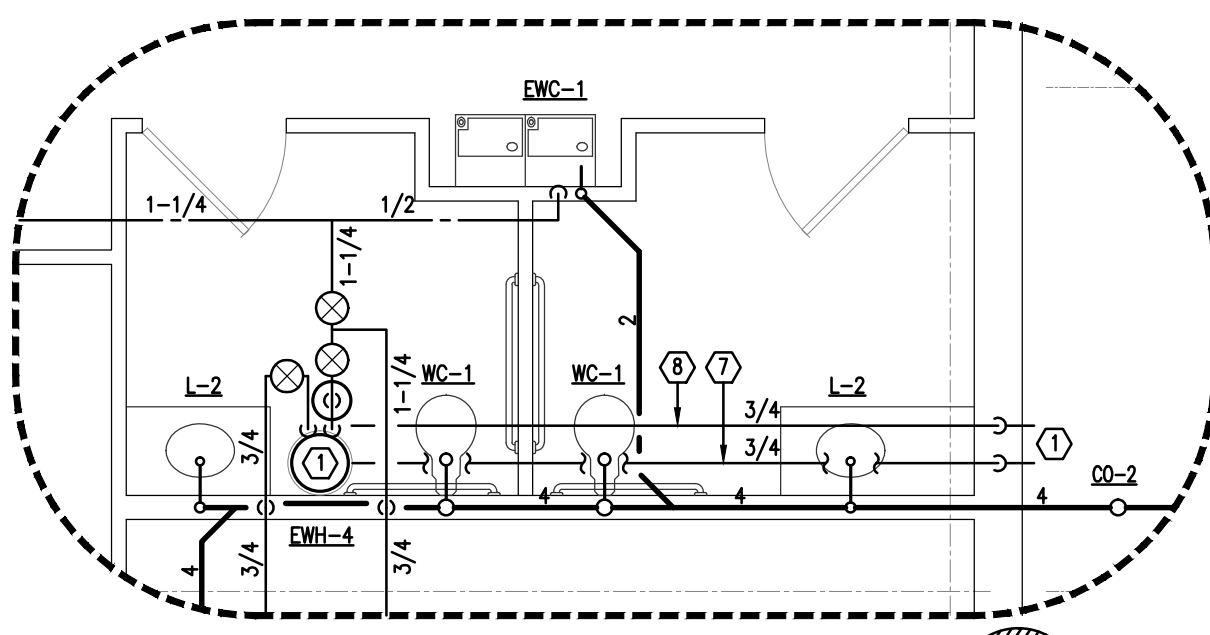


**ENLARGED RESTROOM 101 & 102 PLAN**  
SCALE: 1/4" = 1'-0"

**SHEET NOTES:**


1. PROVIDE ELECTRIC WATER HEATER, ASSOCIATED EXPANSION ABSORBER, DRAIN PAN AND STAND. INSTALL ABOVE CEILING AND ATTACH TO WALL IN ACCORDANCE WITH MANUFACTURER'S RECOMMENDATIONS (SEE DETAIL THIS SHEET). EXTEND DRAIN PAN AND PRESSURE TEMPERATURE RELIEF VALVE PIPING OUT EXTERIOR WALL AND DOWN. TERMINATE AT ABOVE FINISHED GRADE AND STUB OUT AWAY FROM WALL WITH TYPE "M" COPPER "ELL".
2. PROVIDE IAW MANUFACTURER'S RECOMMENDATIONS, A PPP MODEL "OREGON #1" TRAP PRIMER OR EQUAL WITH A PPP MODEL DU-U DISTRIBUTION UNIT. CONNECT TO ED-1 IN MEN'S RESTROOM P-130 & ED-1 IN WOMEN'S RESTROOM P-129 (SEE DETAIL THIS SHEET).
3. PROVIDE IAW MANUFACTURER'S RECOMMENDATIONS, A PPP MODEL "OREGON #1" TRAP PRIMER OR EQUAL WITH A PPP MODEL DU-U DISTRIBUTION UNIT. CONNECT TO ED-1 IN MEN'S RESTROOM 130 & ED-1 IN WOMEN'S RESTROOM 131 (SEE DETAIL THIS SHEET).
4. PROVIDE IAW MANUFACTURER'S RECOMMENDATIONS, A PPP MODEL "OREGON #1" TRAP PRIMER OR EQUAL WITH A PPP MODEL DU-U DISTRIBUTION UNIT. CONNECT TO ED-1 IN MEN'S RESTROOM P-115 & ED-1 IN WOMEN'S RESTROOM P-116 (SEE DETAIL THIS SHEET).
5. PROVIDE IAW MANUFACTURER'S RECOMMENDATIONS, A PPP MODEL "OREGON #1" TRAP PRIMER OR EQUAL WITH A PPP MODEL DU-U DISTRIBUTION UNIT. CONNECT TO ED-1 IN MEN'S RESTROOM P-103, ED-1 IN WOMEN'S RESTROOM P-101 (SEE DETAIL THIS SHEET).
6. PROVIDE IAW MANUFACTURER'S RECOMMENDATIONS, A PPP MODEL "OREGON #1" TRAP PRIMER OR EQUAL. CONNECT TO ED-1 IN DINING ROOM P-104 (SEE DETAIL THIS SHEET).
7. 3/4" DRAIN PAN PIPING. ROUTE TO OUTSIDE.
8. 3/4" PRESSURE TEMPERATURE RELIEF VALVE PIPING. ROUTE TO OUTSIDE.
9. INSTALL 4" OPEN RECEPTACLE ABOVE CEILING.

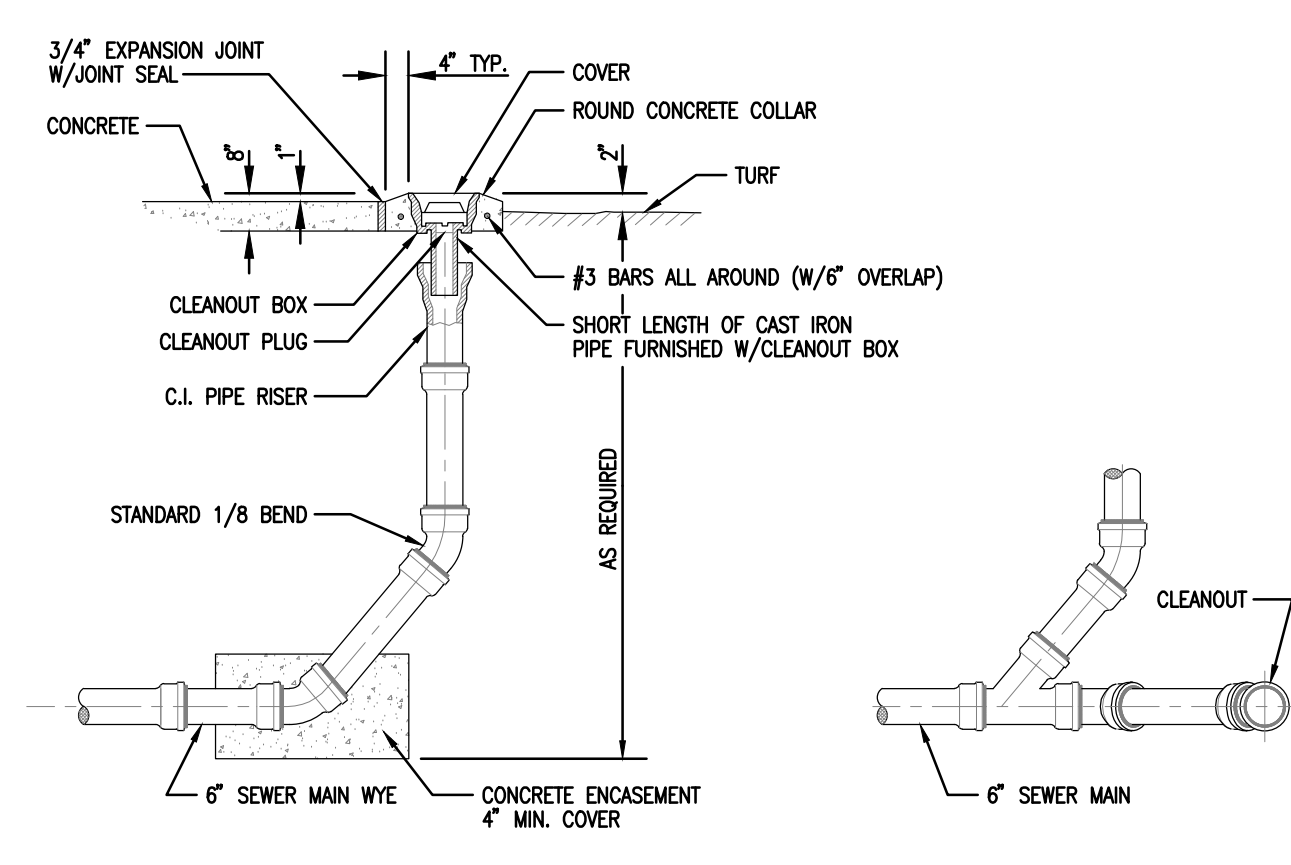


**TYPICAL EXTERIOR CLEANOUT DETAIL**  
NOT TO SCALE

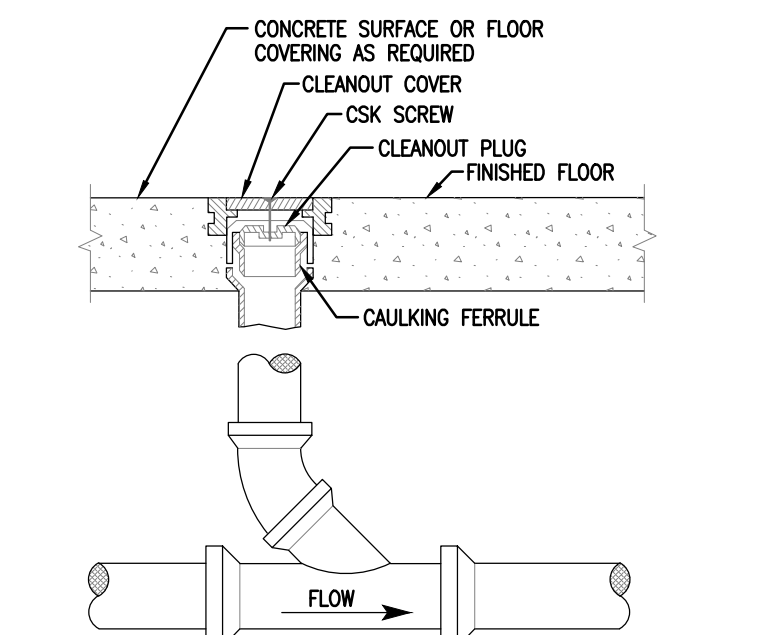


**FLOOR CLEANOUT-FINISHED ROOM**  
NOT TO SCALE

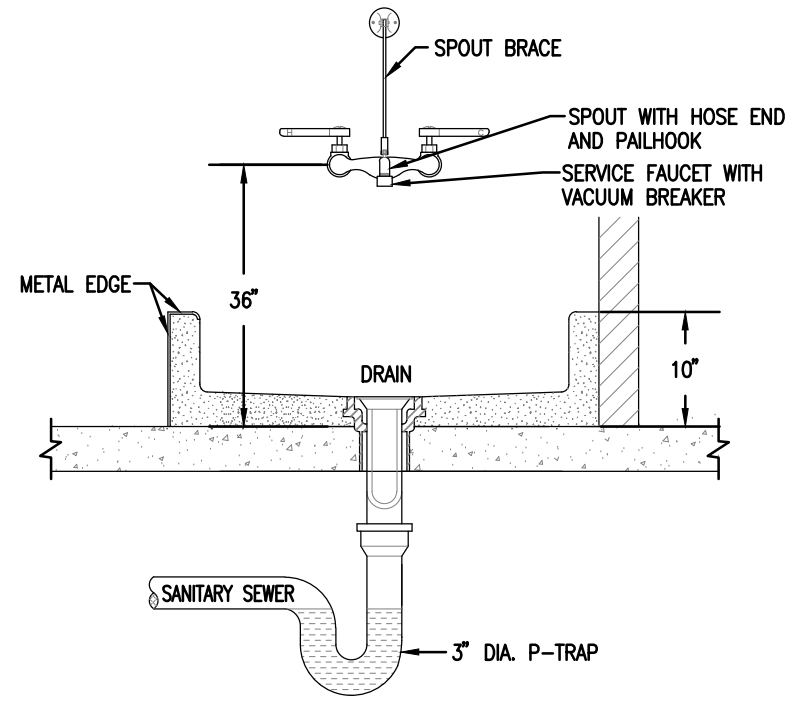


**MOP SINK DETAIL**  
NOT TO SCALE

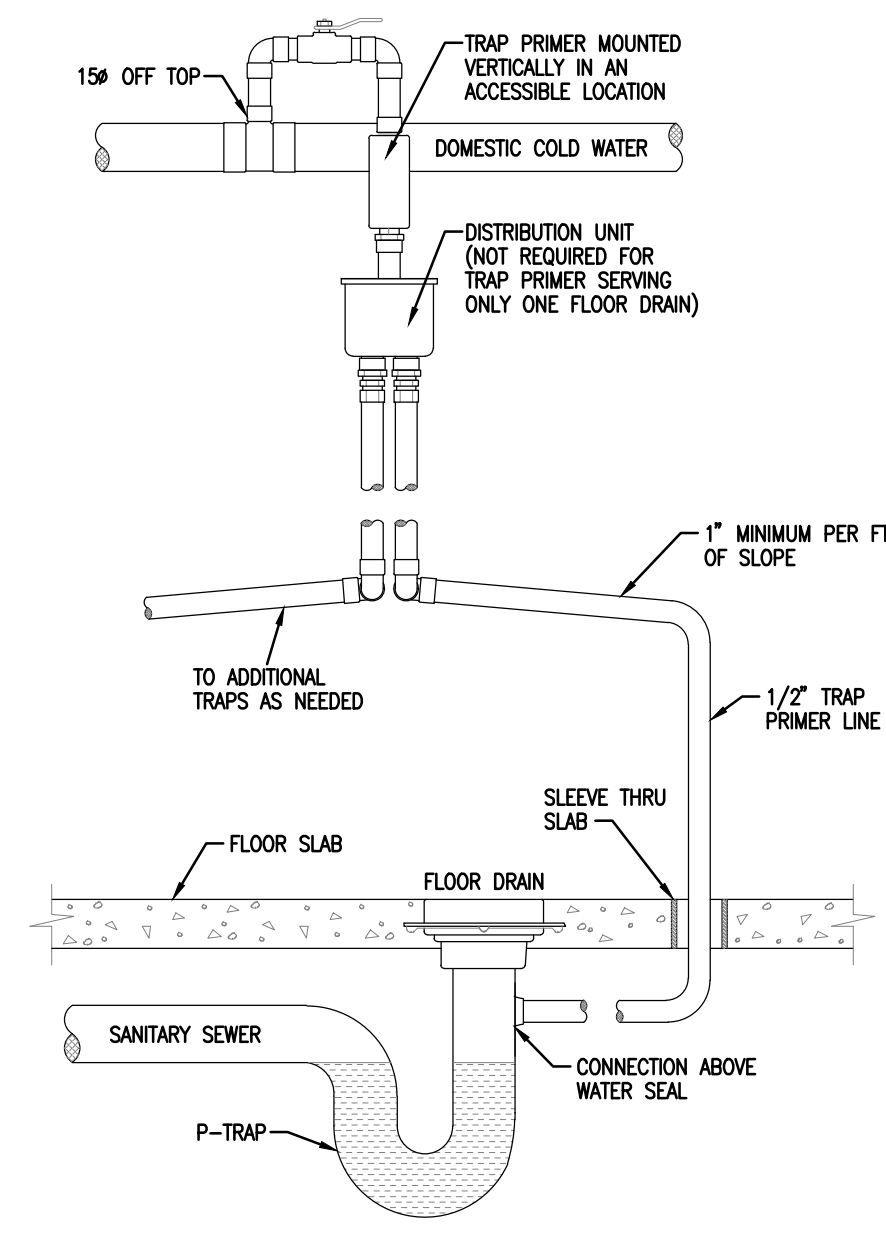

**TYPICAL TRAP PRIMER DETAIL**  
NOT TO SCALE

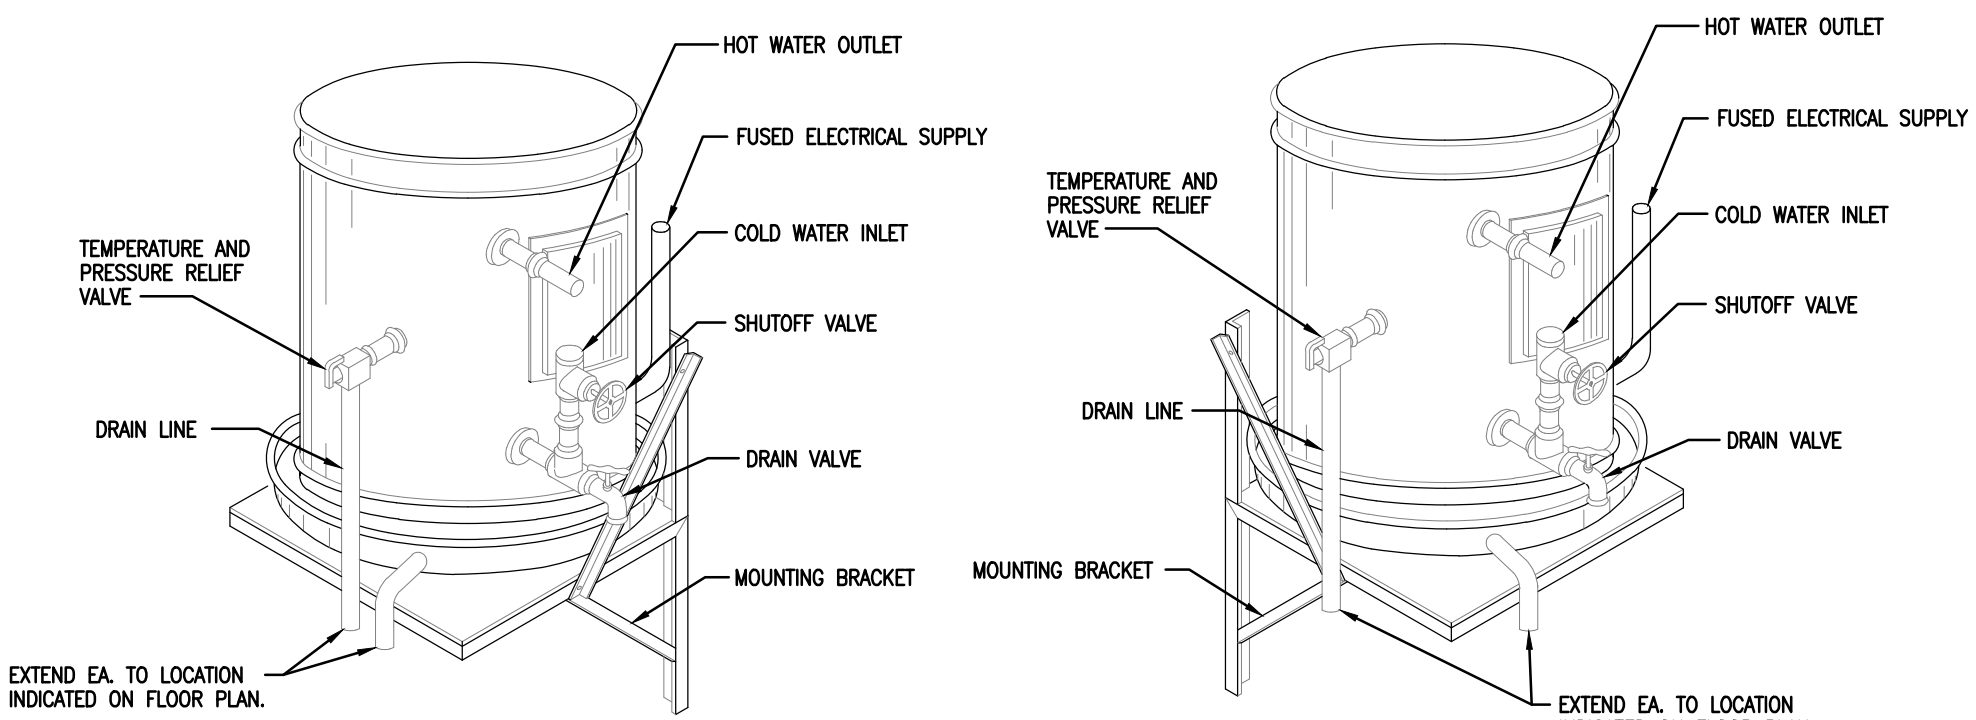


**WALL MOUNTED ELECTRIC WATER HEATER**  
NOT TO SCALE

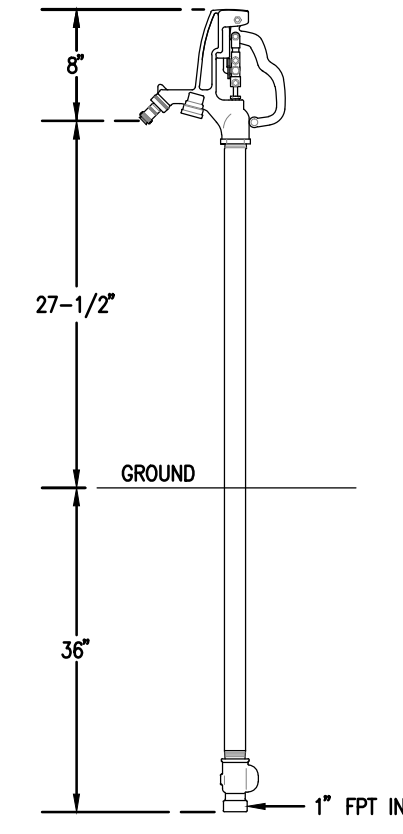

**WOODFORD Y2 YARD HYDRANT DETAIL**  
NOT TO SCALE

**ENLARGED PLUMBING PLANS & DETAILS**  
SCALE: 1/4" = 1'-0"

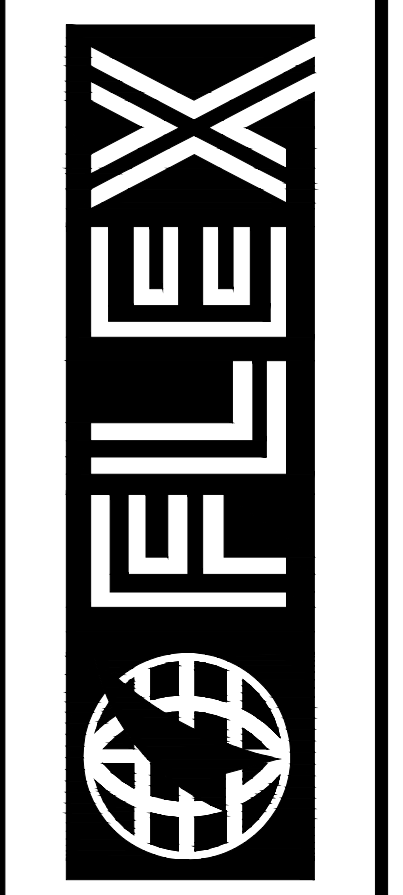

**FLEXFILMS, U.S.A., LLC**  
1221 NORTH BLACK BRANCH ROAD  
ELIZABETHTOWN, KENTUCKY 42702  
PROJECT L-12 BOPET U.S.A.

DATE	REVISION	BY
NOV. 11	VALUE ENGINEERING RE-DESIGN DOCUMENT	

PROJECT NO. 8529-02  
DESIGNED BY TBW  
DRAWN BY RCD  
CHECKED BY TBW  
REVIEWED BY JLM  
DATE JULY 2011  
SCALE AS NOTED

**nse**  
OF KENTUCKY, INC.  
Engineers  
Architects  
Planners  
624 Wellington Way  
Lexington, KY 40503  
Phone: (859) 223-5664  
Fax: (859) 223-5607  
www.nseinc.com

**DRAWING NO.**  
UFL-L12  
P-003