


ENLARGED EQUIPMENT FOUNDATION PLAN

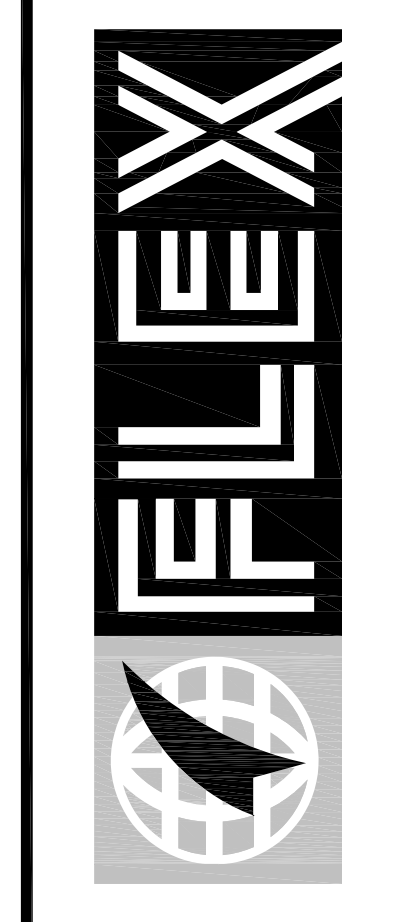

FLEX FILMS (USA) INC.
 1221 NORTH BLACK BRANCH ROAD
 ELIZABETHTOWN, KENTUCKY 42702

PROJECT L-12 BOPET U.S.A.

DATE	REVISION
11-15-11	REVISION NUMBER ONE
01-04-12	REVISION NUMBER TWO
01-04-12	REVISION NUMBER THREE

PROJECT NO. 9524-02
DESIGNED BY EPH
DRAWN BY GPT/EFH
CHECKED BY FH
REVIEWED BY
DATE JULY 2011
SCALE AS NOTED

nse
 OF KENTUCKY, INC.
 Engineers
 Architects
 Planners
 Phone: (609)223-8694
 624 Wellington Way
 Lexington, KY 40503
 Fax: (609)223-8697
 www.nseinc.com

DRAWING NO.
UFL-L12
PS-101