



MSE of Kentucky, Inc.

Engineers/Architects/Planners

**624 Wellington Way
Lexington,
Kentucky 40503
859-223-5694
FAX 859-223-2607
E-Mail: mseinc@mselex.com**

**Addendum No. 3
Bid Date: Feb 13th, 2024
Plans, Specifications and Contract Documents
for
McCreary Co. Spec. Building Fit-up for
McCreary Co. Industrial
Development Authority**

ADDENDUM NO. 3 - ISSUE DATE: 2-8-24

The following additions, deletions, changes or revisions are issued herewith and become a part of the Project Documents. Addendum No. 3 consists of two (2) 8.5x11 pages, two (2) 24x36 sheets.

Item 1: Regarding HVAC thermostat locations and type, refer to specification 230900, and attached MPE Addendum #3 McCreary Co. Spec Building Fit-up, and updated attached sheets M-1 and M-2.

END OF ADDENDUM NO. 3

McCreary County Spec Building Fit-up
Pine Knot, KY

MEP ADDENDUM #3

Refer to Drawings; Sheet M-1 and M-2:

1. Please provide thermostats as indicated in attached drawings M-1 and M-2.

McCREARY CO. SPEC BUILDING FIT-UP
FOR
McCreeary Co. Industrial
Development Authority
PINE KNOT, KENTUCKY

PROJECT NO.	DATE	REVISION	BY
DESIGNED BY	02/07/24	1	ADDENDUM #1
DRAWN BY	02/07/24	2	ADDENDUM #3
CHECKED BY			
REVIEWED BY			
DATE	DEC 20, 2023		
SCALE	AS NOTED		


DESIGNER'S NOTE:
The design professional warrants any and all responsibility and liability for problems which arise from failure to follow these plans, specifications and the design intent they convey.
COPYRIGHT © 2023 by McCreeary Co. Industrial Development Authority. All rights reserved. No part of this publication may be reproduced, stored in a retrieval system, or transmitted in any form or by any means, electronic, mechanical, photocopying, recording, or by any information storage and retrieval system, without the prior written permission of McCreeary Co. Industrial Development Authority.

Engineers
Architects
Planners

nse
OF KENTUCKY, INC.


624 Wellington Way
Lexington, KY 40503
Phone: (859) 223-5894
Fax: (859) 223-2807
www.nselex.com

DRAWING NO.
M-1
SHEET OF

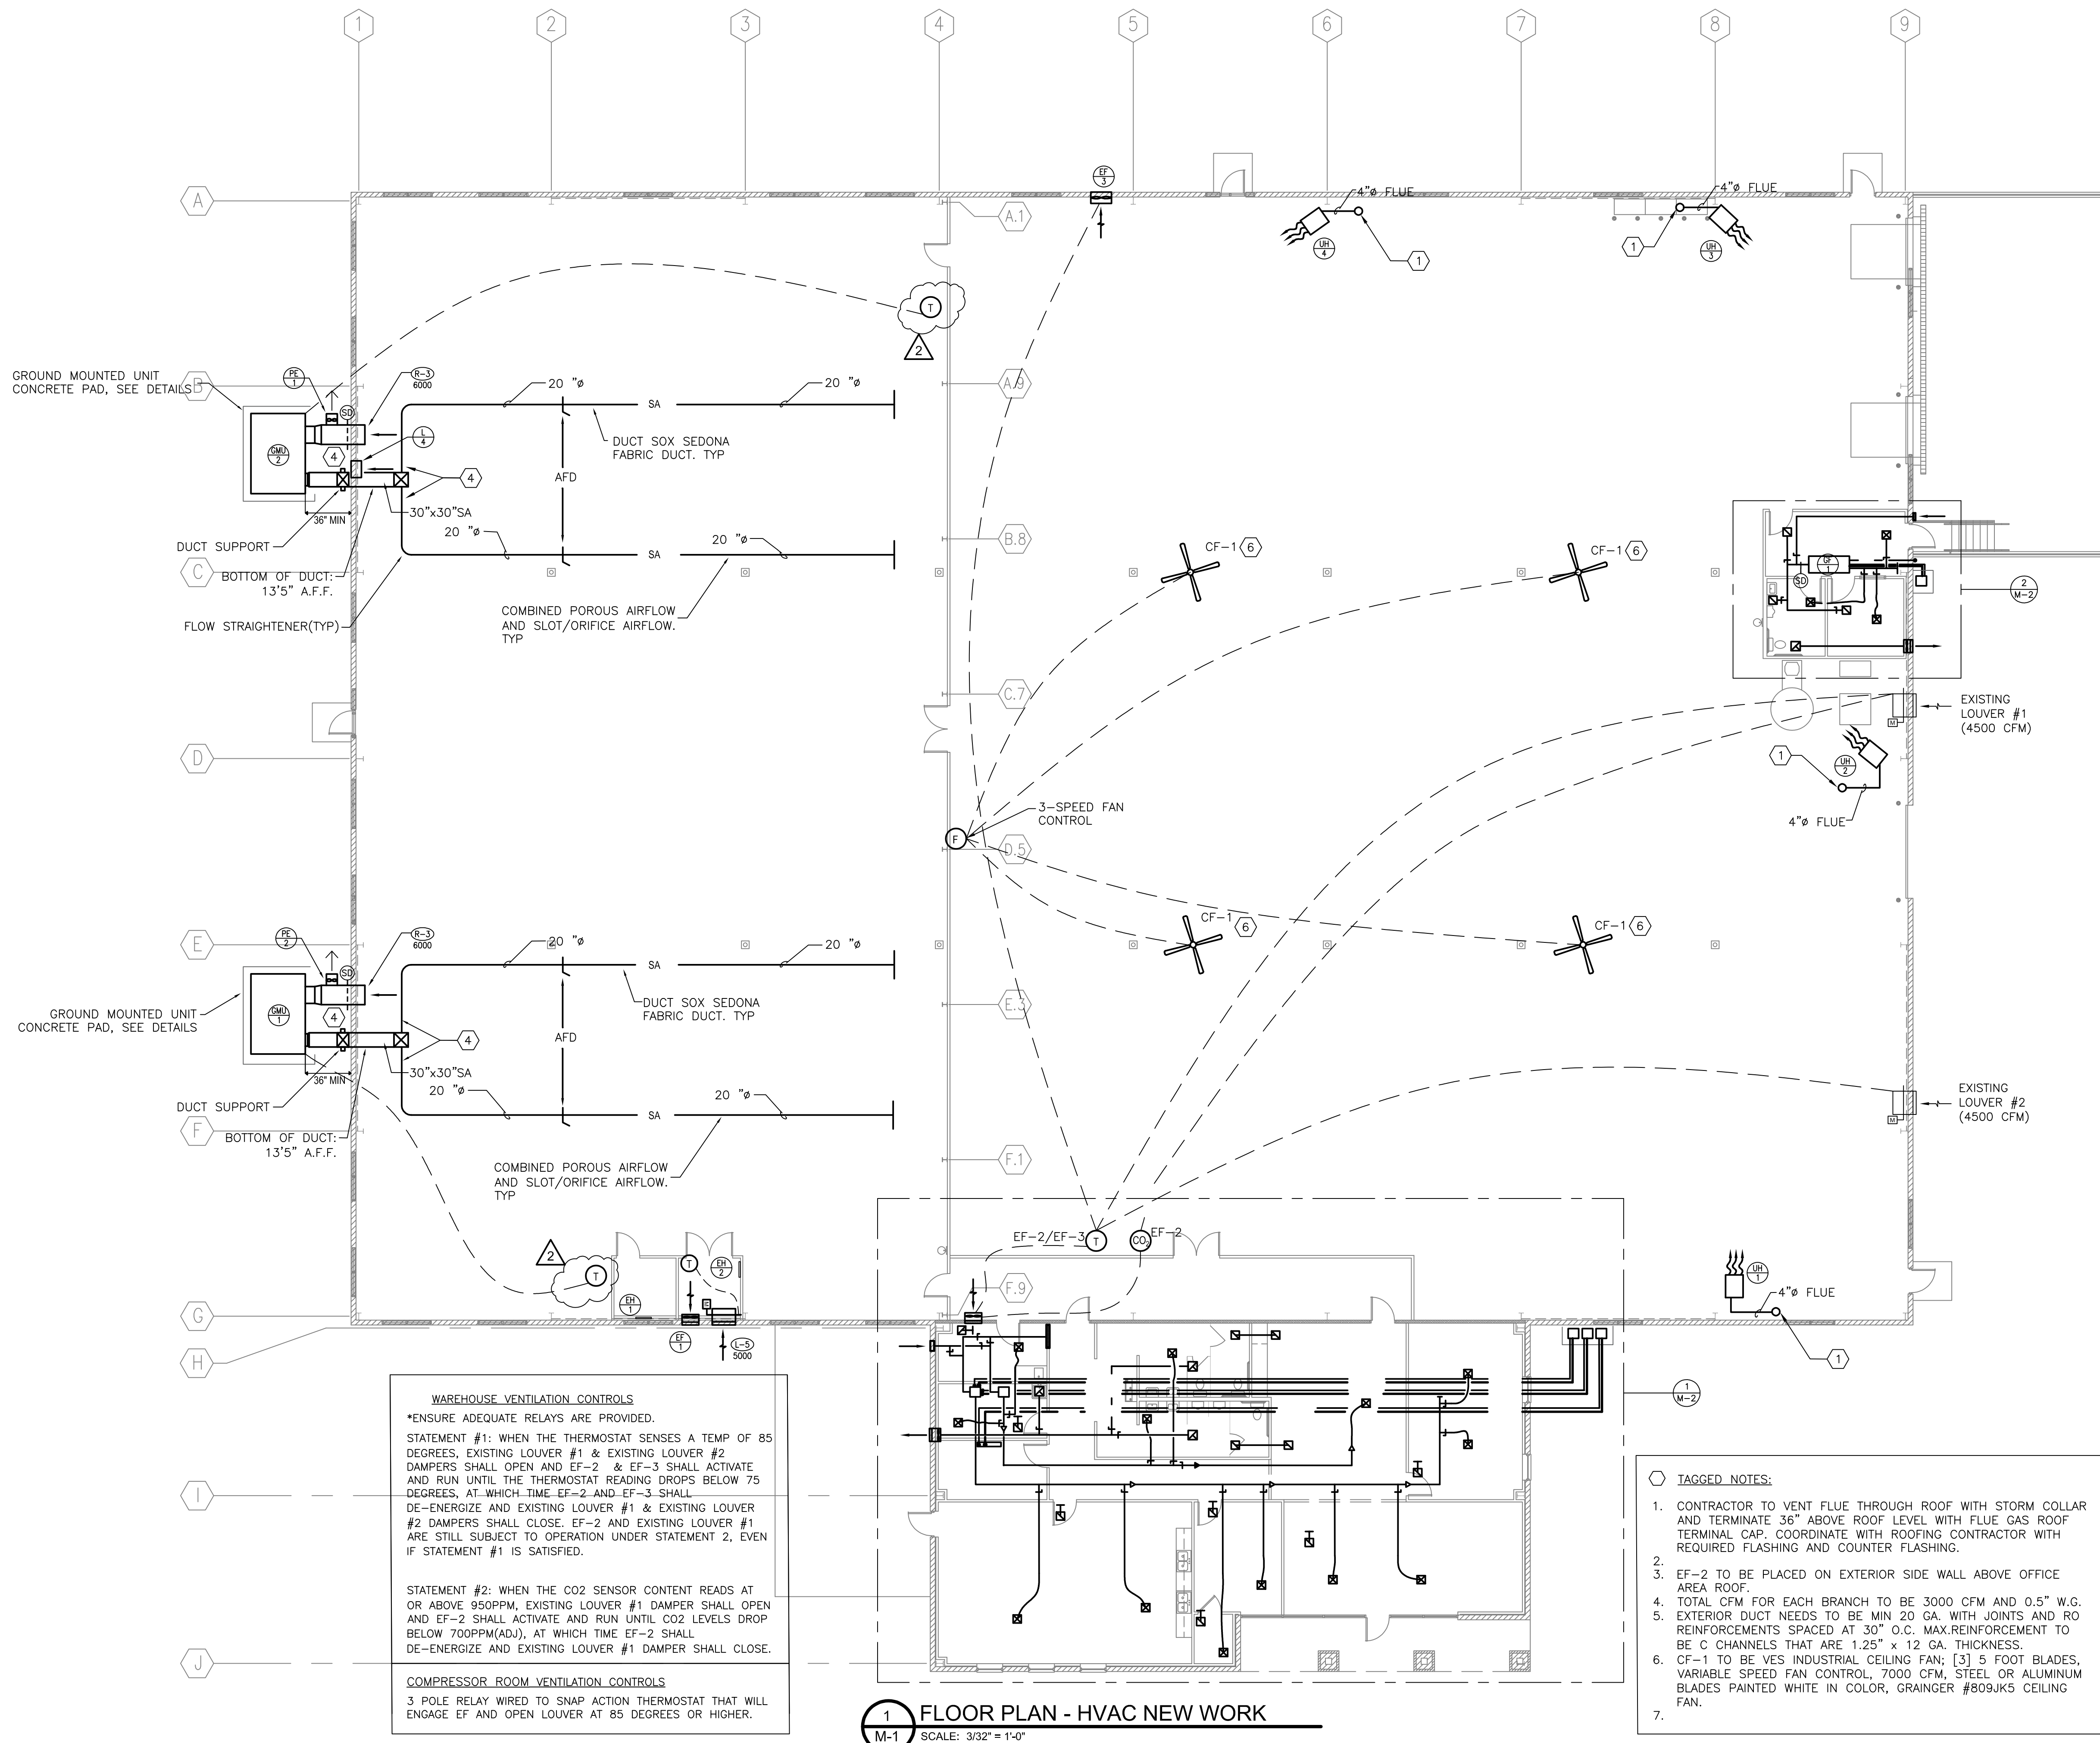

TECHNICAL HORIZONS
Industrial • Commercial • Institutional

CONSULTING ENGINEERING
501 Darby Creek Road, Suite #31
Lexington, KY 40509
Phone: (859) 263-5893

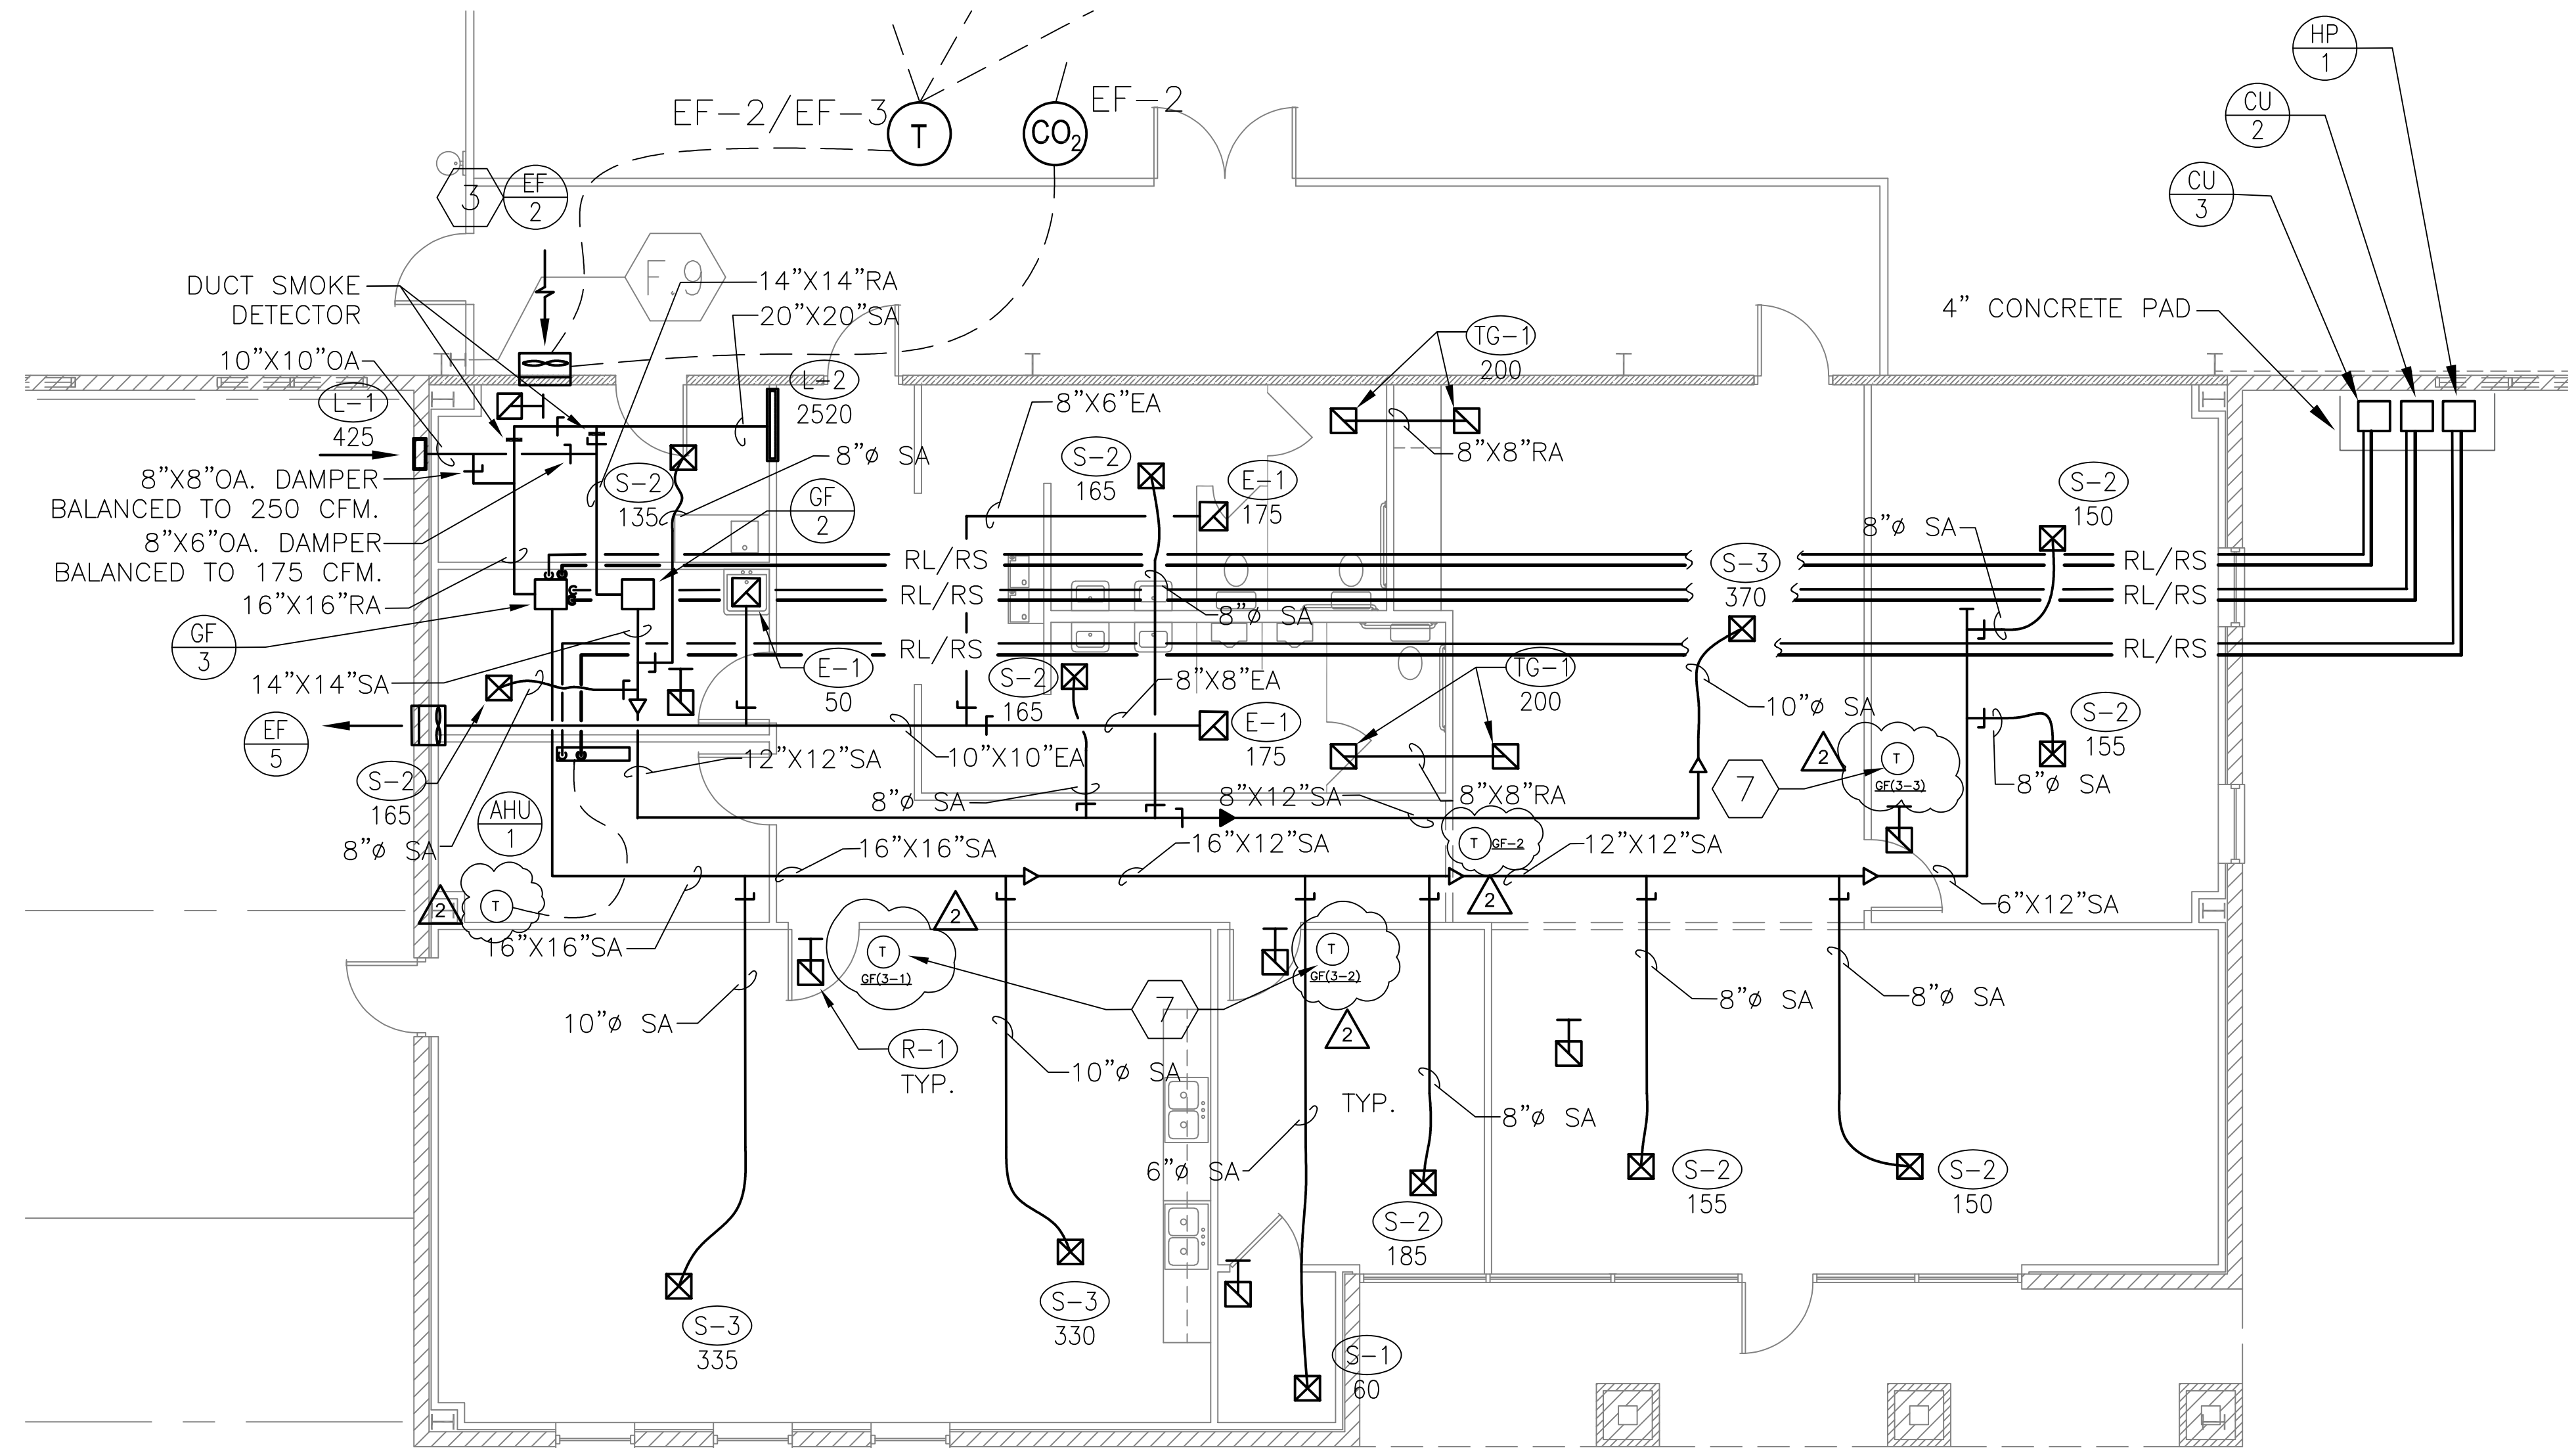


1 ENLARGED HVAC FLOOR PLAN
SCALE: 3/16" = 1'-0"

NOTE:

- CONTRACTOR TO PIPE THE CONDENSATE DRAIN LINE FROM AHU-1 TO MOP SINK IN THE MECHANICAL/JANITOR ROOM (109). AND THE CONDENSATE DRAIN LINE FROM GF-2 AND GF-3 TO FLOOR DRAIN IN SAME ROOM.

TAGGED NOTES:

- ELBOW DOWN CONDENSATE LINE AND SPILL TO GRADE. TERMINATE 15" ABOVE GRADE AND PROVIDE SPLASH BLOCK.
- ALL THERMOSTATS SERVING GF-3 ARE TO BE AVERAGED. THERMOSTATS ARE DESIGNATED BY GF(3-#). MASTER THERMOSTAT TO BE GF(3-2).

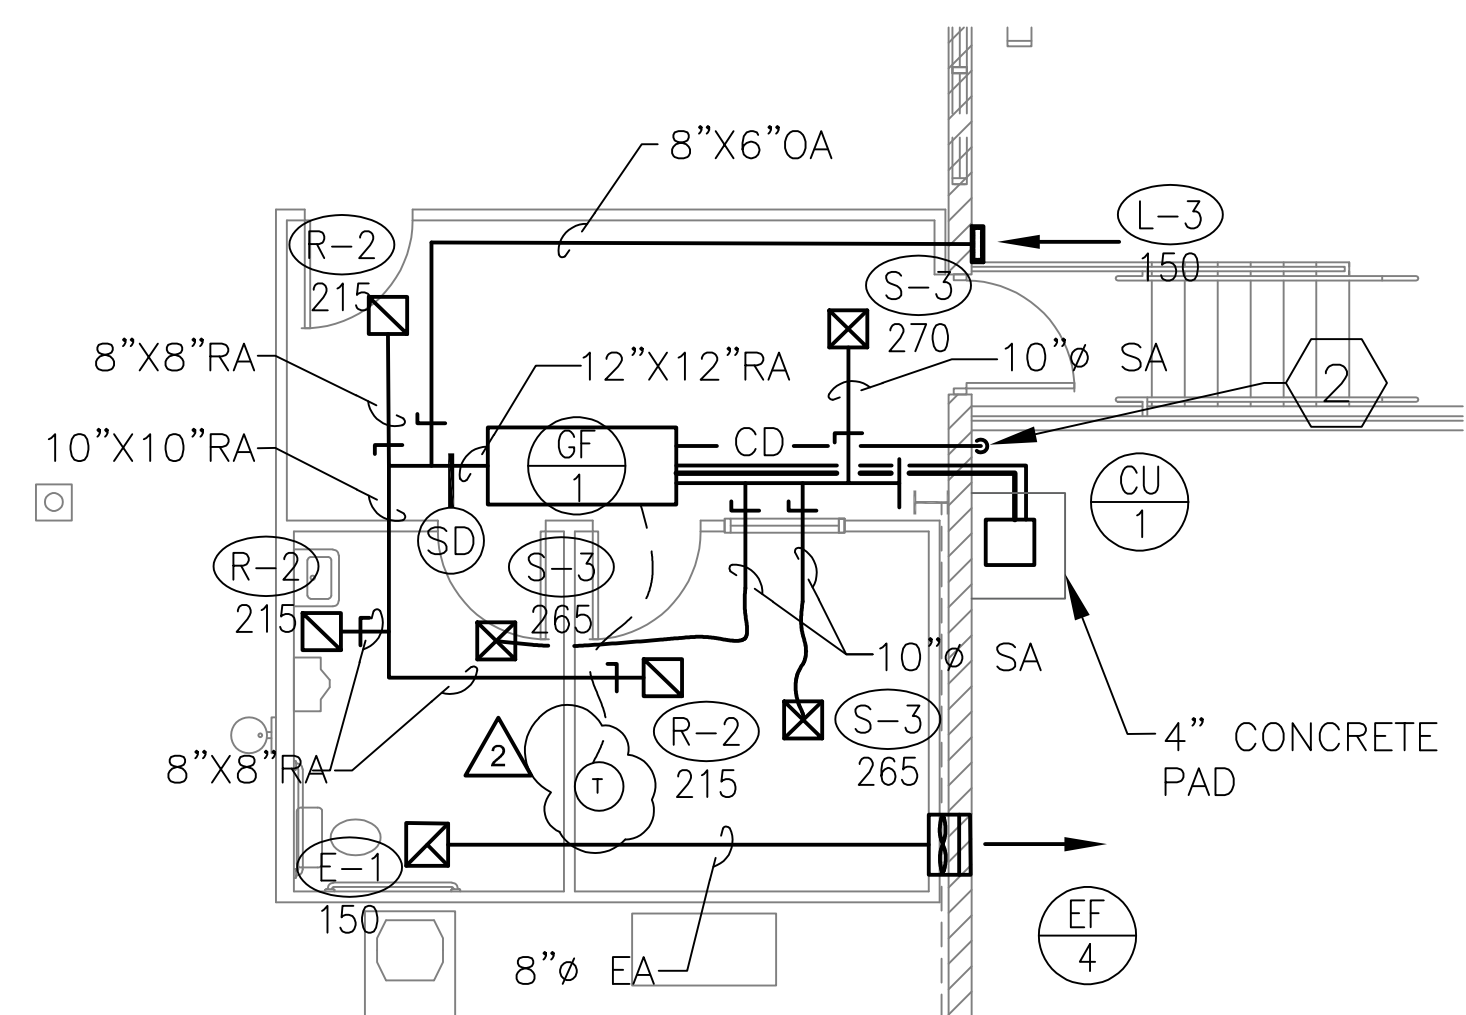

2 ENLARGED HVAC FLOOR PLAN
SCALE: 3/16" = 1'-0"



McCREARY CO. SPEC BUILDING FIT-UP
FOR
McCreary Co. Industrial Development Authority
PINE KNOT, KENTUCKY

DATE	REVISION	BY
02/07/24	1 ADDENDUM #1	
02/07/24	2 ADDENDUM #3	

DESIGN PROFESSIONAL'S NOTICE:
The design professional warrants any and all responsibility and liability for problems which arise from failure to follow these plans, specifications and the design intent they convey.
COPYRIGHT © 2023 by MSEE of Kentucky, Inc. All rights reserved. No part of this publication may be reproduced, stored in a retrieval system, or transmitted in any form or by any means, electronic, mechanical, photocopying, recording, or by any information storage and retrieval system, without the prior written permission of MSEE of Kentucky, Inc.

PROJECT NO.	DESIGNED BY	AT
DRAWN BY	CHECKED BY	REVIEWED BY
DATE	SCALE	AS NOTED
DEC 20, 2023		

msee
OF KENTUCKY, INC.
Engineers
Architects
Planners
624 Wellington Way
Lexington, KY 40503
Phone: (859) 223-5894
Fax: (859) 223-2807
www.mseelex.com

DRAWING NO.
M-2
SHEET OF